

01
-

SITUATION
1:400

NOTES
THESE DRAWINGS ARE AN INSTRUMENT OF SERVICE AND ARE THE PROPERTY OF THE CREATOR. ANY USE OF THE DRAWINGS WITHOUT THE PRIOR EXPRESS WRITTEN PERMISSION OF THE CREATOR IS A VIOLATION OF COPYRIGHT AND WILL BE LIABLE TO PROSECUTION. DO NOT SCALE FROM DRAWINGS. USE ONLY GIVEN DIMENSIONS. ALL DIMENSIONS ARE IN MILLIMETERS UNLESS OTHERWISE NOTED.

△			
△			
△			
△			

REV	DATE	REVISION STATUS	STATUS

PROJECT		<i>Sakawic</i>
HOTEL BACKPACKER DI PASAR LEMPUYANGAN YOGYAKARTA		
INSTITUTION		DEPARTMENT OF ARCHITECTURE
DEPARTMENT OF ARCHITECTURE FACULTY OF CIVIL AND ENGINEERING PLANNING, UII.		
NAME	STUDENT IDENTITY	
FARA HAJAR P ARCHITECT	14512041	

DRAWING TITLE
SITUATION

DRAWING BY
FARA HAJAR P

STATUS
PRELIMINARY DESIGN

SKALA
1:400

DRAWING NO.
01

	NAME	SIGN	DATE
DRAWN BY	FARA HAJAR P		
CHECKED BY			
APPROVED BY			

	PAGE	1
	TOTAL PAGE	29

N



02
-

SITEPLAN
1:250

NOTES
THESE DRAWINGS ARE AN INSTRUMENT OF SERVICE AND ARE THE PROPERTY OF THE CREATOR. ANY USE OF THE DRAWINGS WITHOUT THE PRIOR EXPRESS WRITTEN PERMISSION OF THE CREATOR IS A VIOLATION OF COPYRIGHT AND WILL BE LIABLE TO PROSECUTION. DO NOT SCALE FROM DRAWINGS. USE ONLY GIVEN DIMENSIONS. ALL DIMENSIONS ARE IN MILLIMETERS UNLESS OTHERWISE NOTED.

△			
△			
△			
△			

REV	DATE	REVISION STATUS	STATUS

PROJECT		<i>Sadawati</i>
HOTEL BACKPACKER DI PASAR LEMPUNGAN YOGYAKARTA		
INSTITUTION		DEPARTMENT OF ARCHITECTURE
DEPARTMENT OF ARCHITECTURE FACULTY OF CIVIL AND ENGINEERING PLANNING, UII.		SURDISPO
NAME		STUDENT IDENTITY
FARA HAJAR P ARCHITECT		14512041

DRAWING TITLE	SITEPLAN
---------------	----------

DRAWING BY	FARA HAJAR P
------------	--------------


STATUS	PRELIMINARY DESIGN
--------	--------------------

SKALA	1:250
-------	-------

DRAWING NO.	02
-------------	----

	NAME	SIGN	DATE
DRAWN BY	FARA HAJAR P		
CHECKED BY			
APPROVED BY			

PAGE	2
	TOTAL PAGE

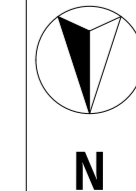



03
-

GF PLAN
1:150

NOTES
THESE DRAWINGS ARE AN INSTRUMENT OF SERVICE AND ARE THE PROPERTY OF THE CREATOR. ANY USE OF THE DRAWINGS WITHOUT THE PRIOR EXPRESS WRITTEN PERMISSION OF THE CREATOR IS A VIOLATION OF COPYRIGHT AND WILL BE LIABLE TO PROSECUTION. DO NOT SCALE FROM DRAWINGS. USE ONLY GIVEN DIMENSIONS. ALL DIMENSIONS ARE IN MILLIMETERS UNLESS OTHERWISE NOTED.

△		
△		
△		
△		

REV	DATE	REVISION STATUS	STATUS

PROJECT		
HOTEL BACKPACKER DI PASAR LEMPUYANGAN YOGYAKARTA		
INSTITUTION		
DEPARTMENT OF ARCHITECTURE FACULTY OF CIVIL AND ENGINEERING PLANNING, UII.		
NAME	STUDENT IDENTITY	
FARA HAJAR P ARCHITECT	14512041	

DRAWING TITLE
GROUND FLOOR PLAN

DRAWING BY
FARA HAJAR P

STATUS
PRELIMINARY DESIGN

SKALA
1:150

DRAWING NO.
03

	NAME	SIGN	DATE
DRAWN BY	FARA HAJAR P		
CHECKED BY			
APPROVED BY			



03
-

1ST FLOOR PLAN
1:150

NOTES
THESE DRAWINGS ARE AN INSTRUMENT OF SERVICE AND ARE THE PROPERTY OF THE CREATOR. ANY USE OF THE DRAWINGS WITHOUT THE PRIOR EXPRESS WRITTEN PERMISSION OF THE CREATOR IS A VIOLATION OF COPYRIGHT AND WILL BE LIABLE TO PROSECUTION. DO NOT SCALE FROM DRAWINGS. USE ONLY GIVEN DIMENSIONS. ALL DIMENSIONS ARE IN MILLIMETERS UNLESS OTHERWISE NOTED.

△		
△		
△		
△		

REV	DATE	REVISION STATUS	STATUS

PROJECT		<i>Sadkovic</i>
HOTEL BACKPACKER DI PASAR LEMPUYANGAN YOGYAKARTA		
INSTITUTION		DEPARTMENT OF ARCHITECTURE FACULTY OF CIVIL AND ENGINEERING PLANNING, UII.
HOTEL BACKPACKER DI PASAR LEMPUYANGAN YOGYAKARTA		
NAME		STUDENT IDENTITY
FARA HAJAR P ARCHITECT		14512041

DRAWING TITLE
FIRST FLOOR PLAN


DRAWING BY
FARA HAJAR P

STATUS
PRELIMINARY DESIGN

SKALA
1:150

DRAWING NO.
03

	NAME	SIGN	DATE
DRAWN BY	FARA HAJAR P		
CHECKED BY			
APPROVED BY			

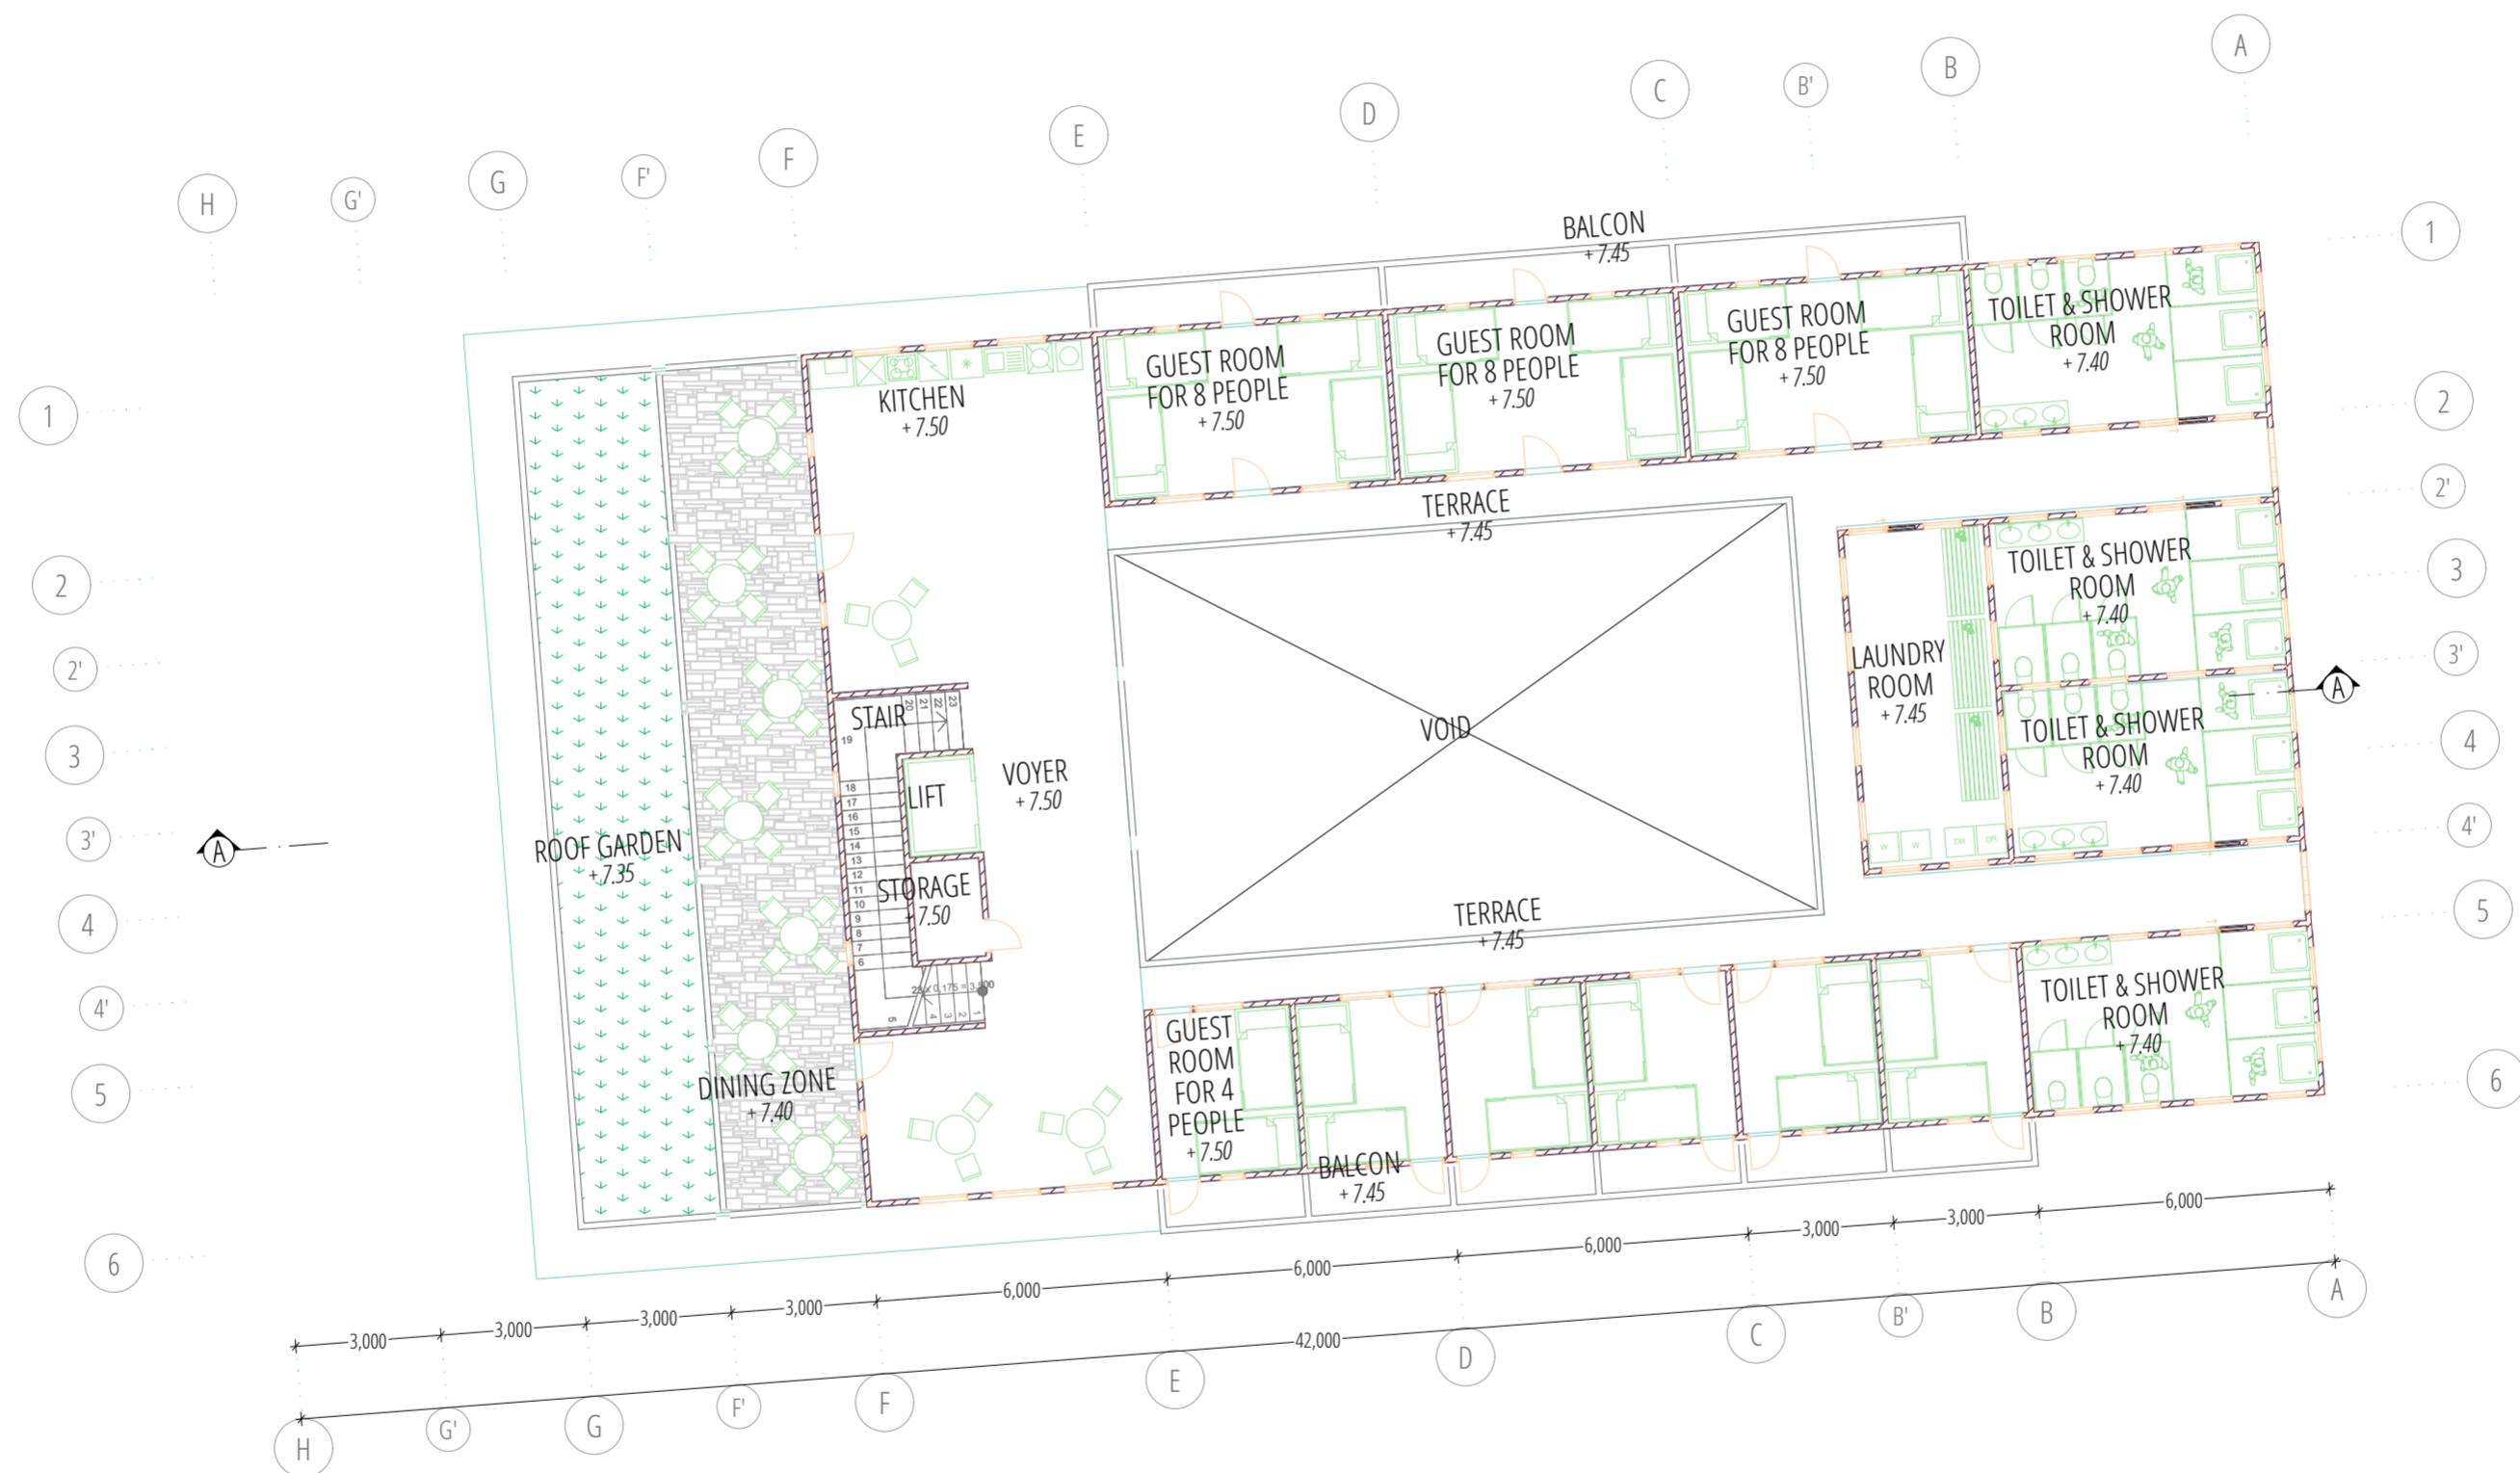



03
-

2ND FLOOR PLAN
1:150

NOTES
THESE DRAWINGS ARE AN INSTRUMENT OF SERVICE AND ARE THE PROPERTY OF THE CREATOR. ANY USE OF THE DRAWINGS WITHOUT THE PRIOR EXPRESS WRITTEN PERMISSION OF THE CREATOR IS A VIOLATION OF COPYRIGHT AND WILL BE LIABLE TO PROSECUTION. DO NOT SCALE FROM DRAWINGS. USE ONLY GIVEN DIMENSIONS. ALL DIMENSIONS ARE IN MILLIMETERS UNLESS OTHERWISE NOTED.

△		
△		
△		
△		

REV	DATE	REVISION STATUS	STATUS

PROJECT		
HOTEL BACKPACKER DI PASAR LEMPUYANGAN YOGYAKARTA		
INSTITUTION		
DEPARTMENT OF ARCHITECTURE FACULTY OF CIVIL AND ENGINEERING PLANNING, UII.		
NAME	STUDENT IDENTITY	
FARA HAJAR P ARCHITECT	14512041	

DRAWING TITLE
SECOND FLOOR PLAN

DRAWING BY
FARA HAJAR P


STATUS
PRELIMINARY DESIGN


SKALA
1:150

DRAWING NO.
03

	NAME	SIGN	DATE
DRAWN BY	FARA HAJAR P		
CHECKED BY			
APPROVED BY			

PAGE
5
TOTAL PAGE
29

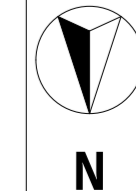

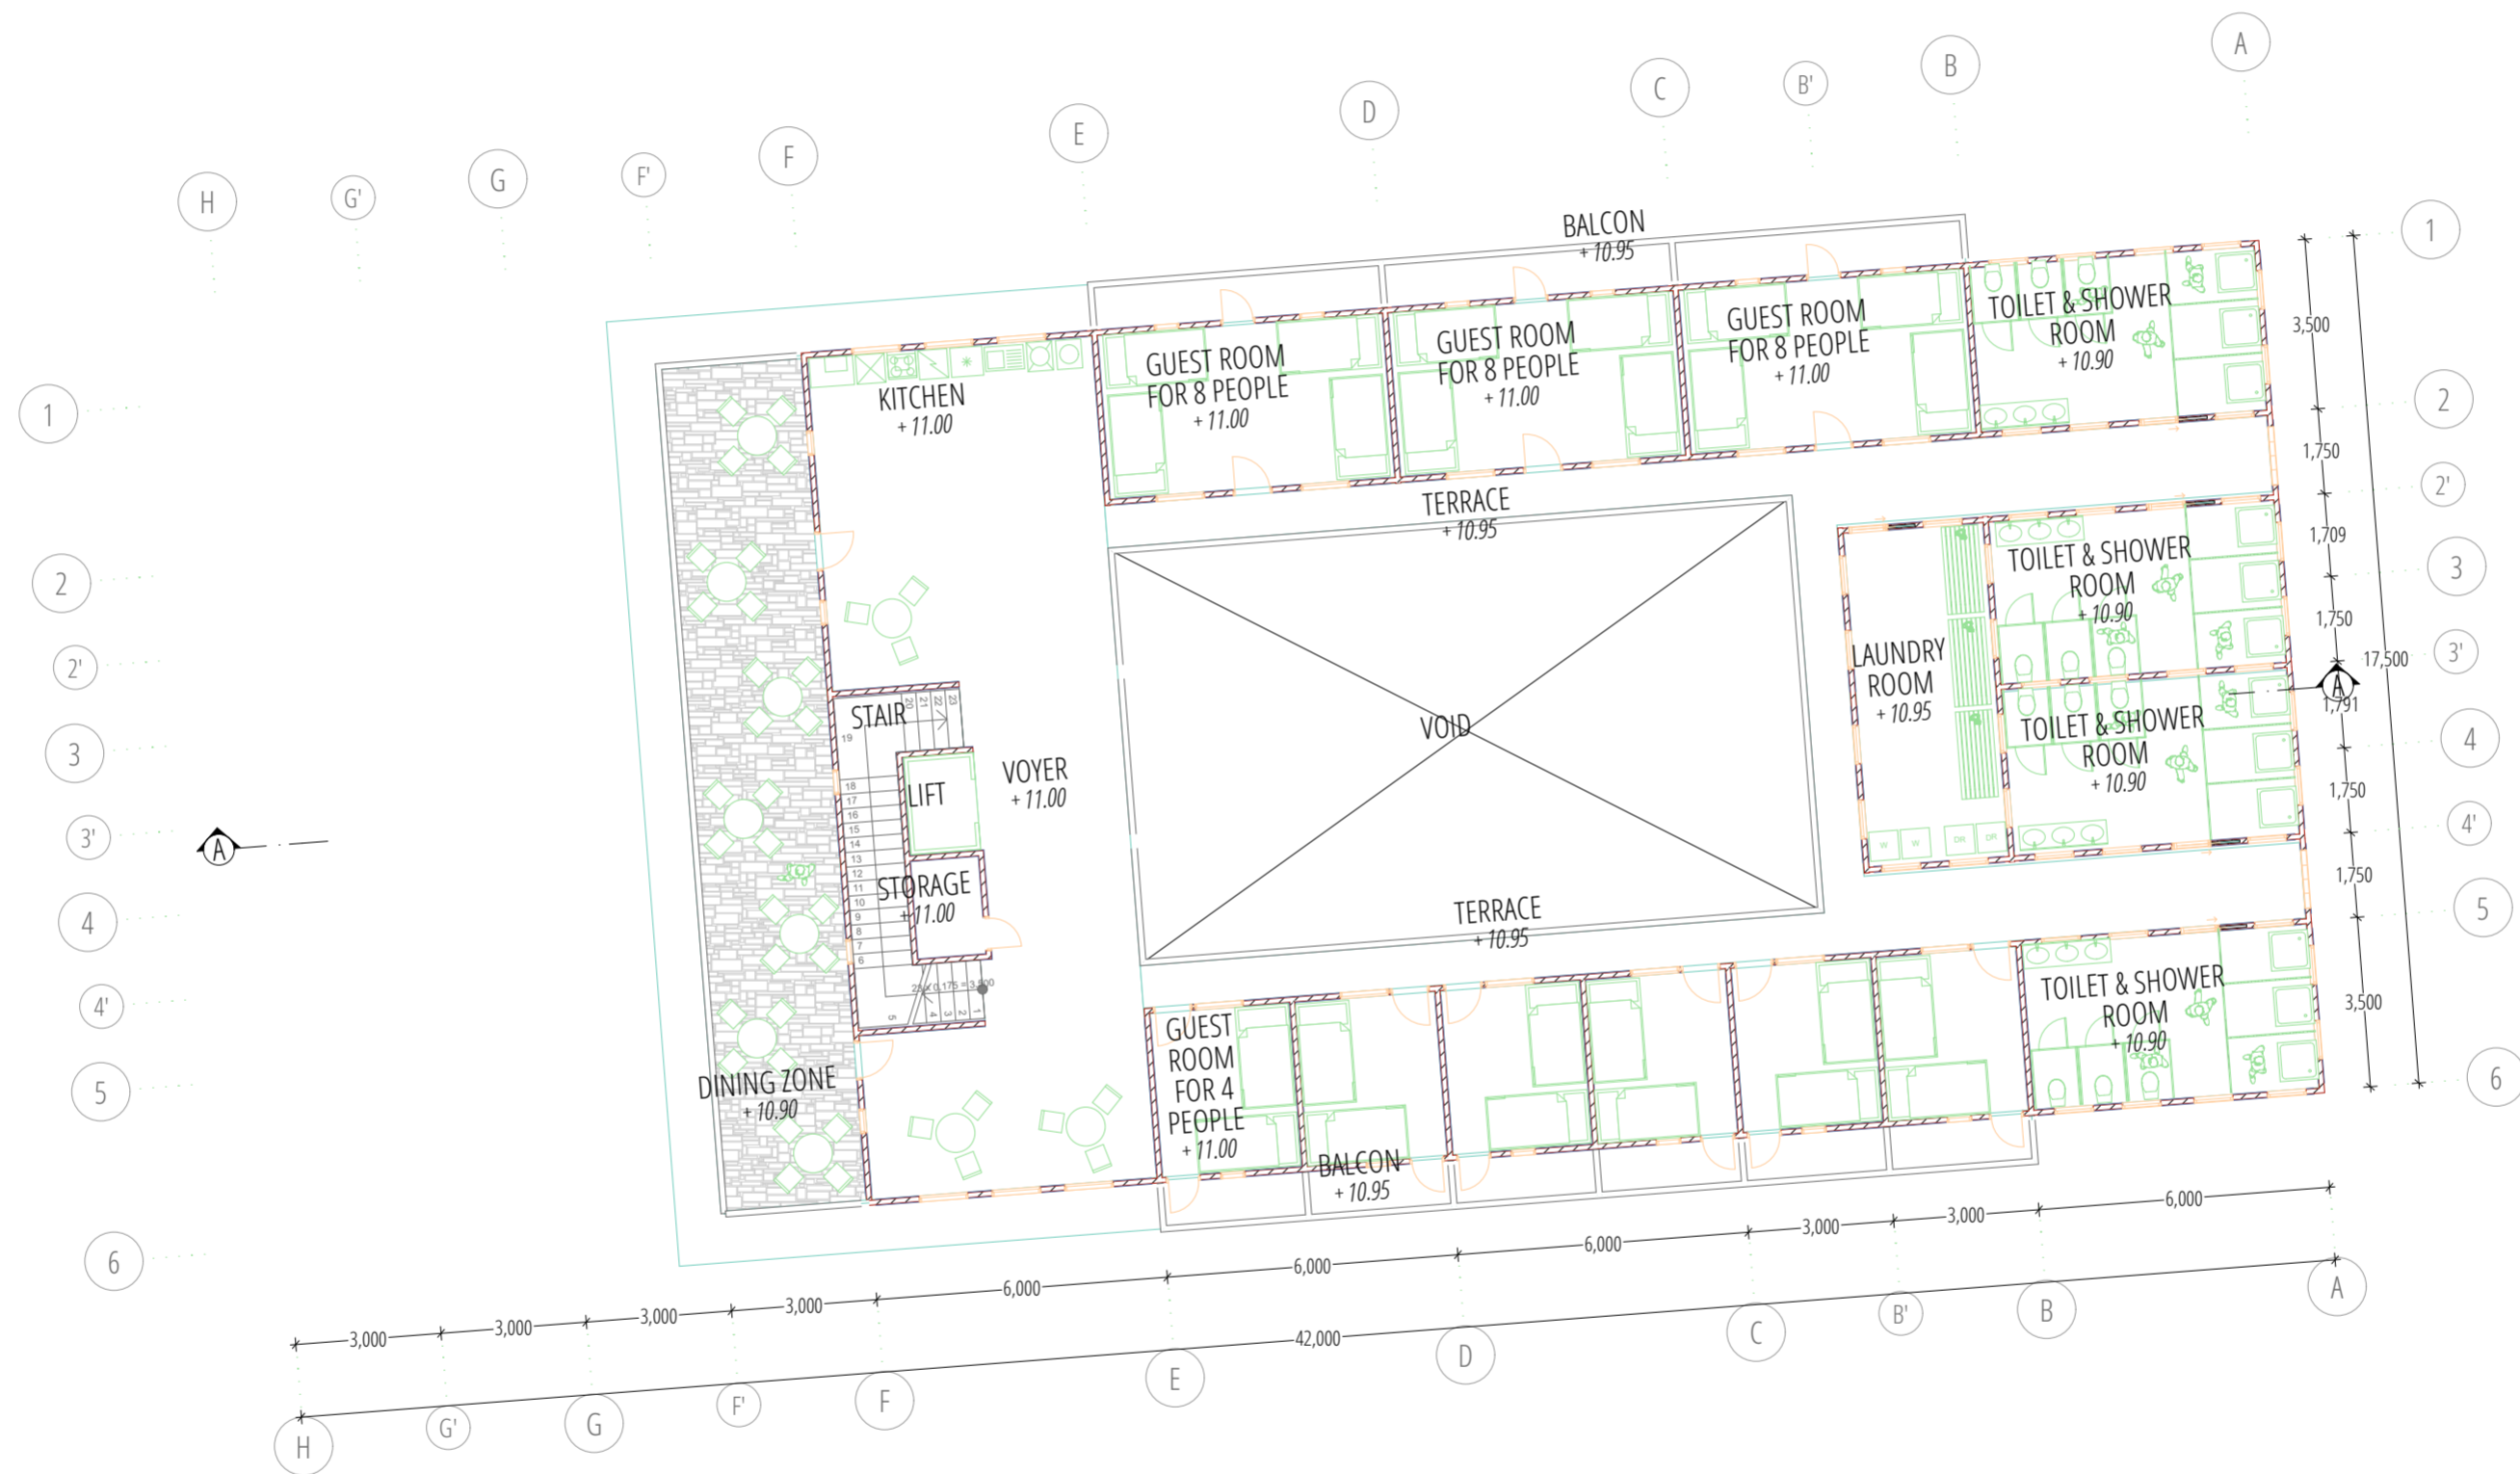

03
-

3RD FLOOR PLAN
1:150

NOTES
THESE DRAWINGS ARE AN INSTRUMENT OF SERVICE AND ARE THE PROPERTY OF THE CREATOR. ANY USE OF THE DRAWINGS WITHOUT THE PRIOR EXPRESS WRITTEN PERMISSION OF THE CREATOR IS A VIOLATION OF COPYRIGHT AND WILL BE LIABLE TO PROSECUTION. DO NOT SCALE FROM DRAWINGS. USE ONLY GIVEN DIMENSIONS. ALL DIMENSIONS ARE IN MILLIMETERS UNLESS OTHERWISE NOTED.

△		
△		
△		
△		

REV	DATE	REVISION STATUS	STATUS

PROJECT		
HOTEL BACKPACKER DI PASAR LEMPUYANGAN YOGYAKARTA		
INSTITUTION		
DEPARTMENT OF ARCHITECTURE FACULTY OF CIVIL AND ENGINEERING PLANNING, UII.		
NAME	STUDENT IDENTITY	
FARA HAJAR P ARCHITECT	14512041	

DRAWING TITLE
THIRD FLOOR PLAN

DRAWING BY
FARA HAJAR P


STATUS
PRELIMINARY DESIGN

SKALA
1:150


DRAWING NO.
03

	NAME	SIGN	DATE
DRAWN BY	FARA HAJAR P		
CHECKED BY			
APPROVED BY			

 PAGE
6
TOTAL PAGE
29



N

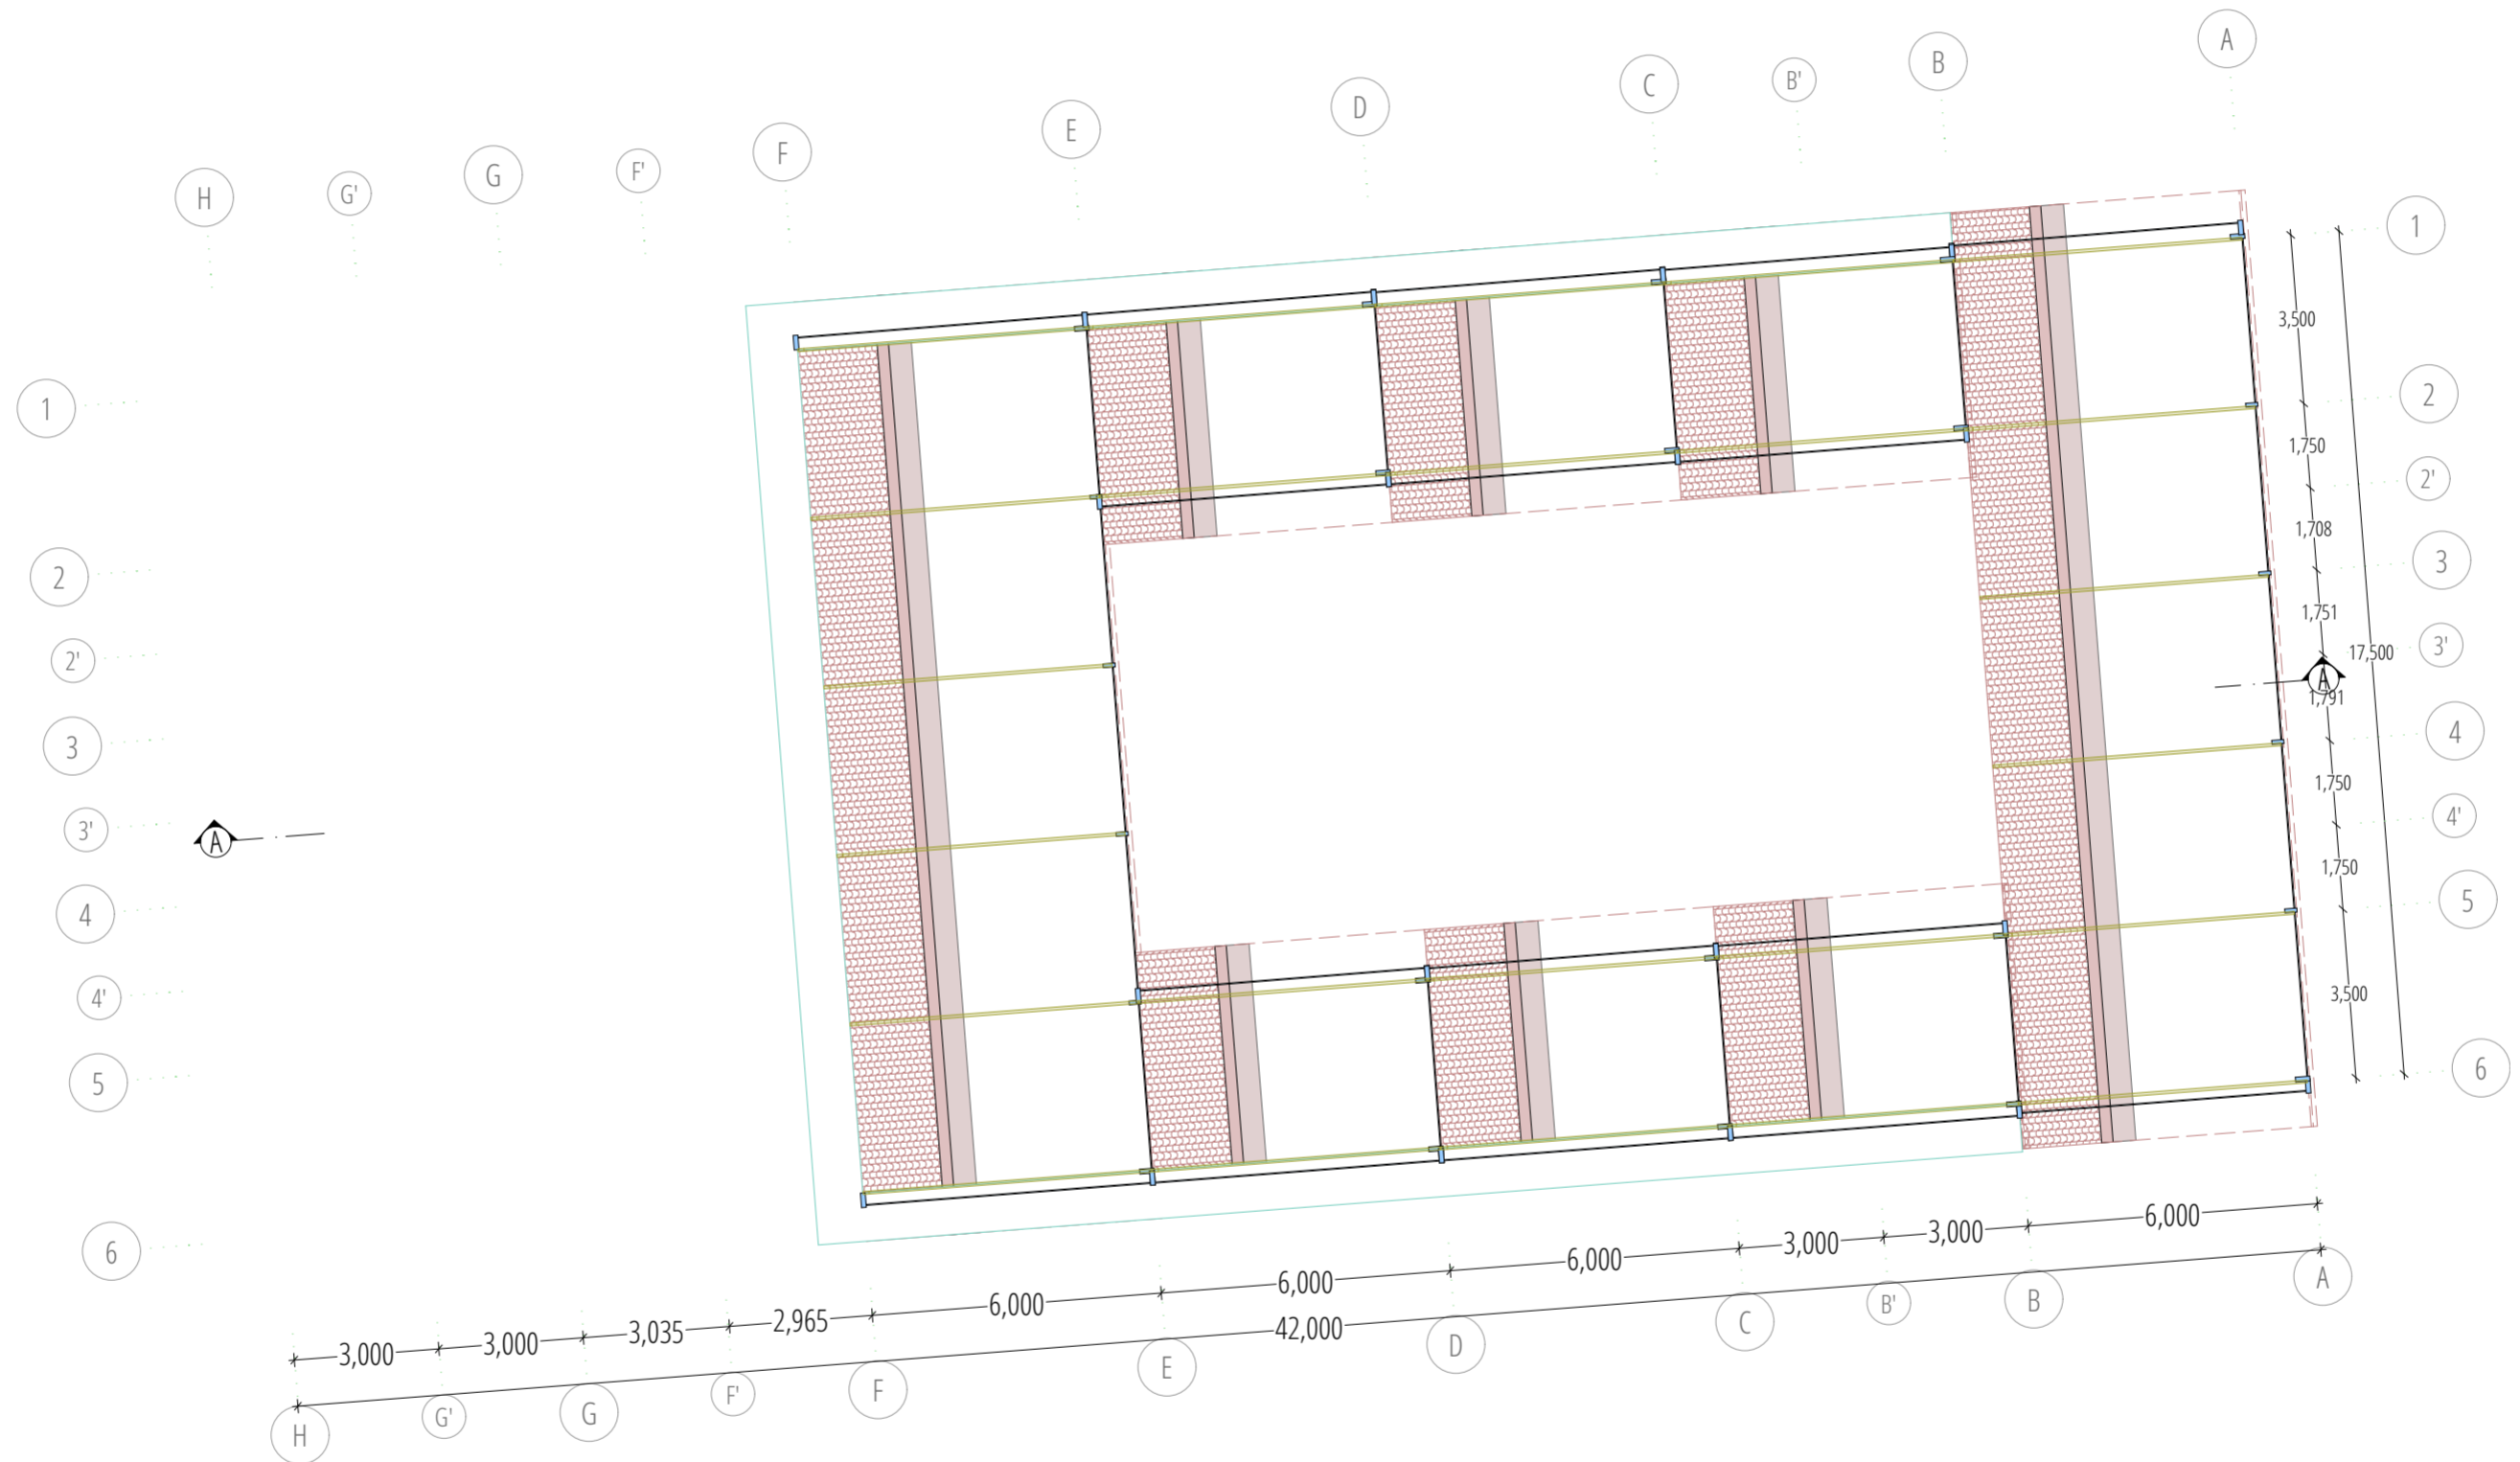

04
-

ROOF TOP PLAN
1:150

NOTES
THESE DRAWINGS ARE AN INSTRUMENT OF SERVICE AND ARE THE PROPERTY OF THE CREATOR. ANY USE OF THE DRAWINGS WITHOUT THE PRIOR EXPRESS WRITTEN PERMISSION OF THE CREATOR IS A VIOLATION OF COPYRIGHT AND WILL BE LIABLE TO PROSECUTION. DO NOT SCALE FROM DRAWINGS. USE ONLY GIVEN DIMENSIONS. ALL DIMENSIONS ARE IN MILLIMETERS UNLESS OTHERWISE NOTED.

△		
△		
△		
△		

REV	DATE	REVISION STATUS	STATUS

PROJECT		<i>Backovic</i>
HOTEL BACKPACKER DI PASAR LEMPUNYANGAN YOGYAKARTA		
INSTITUTION		DEPARTMENT OF ARCHITECTURE
DEPARTMENT OF ARCHITECTURE FACULTY OF CIVIL AND ENGINEERING PLANNING, UII.		
NAME	STUDENT IDENTITY	
FARA HAJAR P ARCHITECT	14512041	

DRAWING TITLE
ROOF TOP PLAN

DRAWING BY
FARA HAJAR P

STATUS
PRELIMINARY DESIGN

SKALA
1:150


DRAWING NO.
04

	NAME	SIGN	DATE
DRAWN BY	FARA HAJAR P		
CHECKED BY			
APPROVED BY			



04
-

SOUTH ELEVATION
1:150

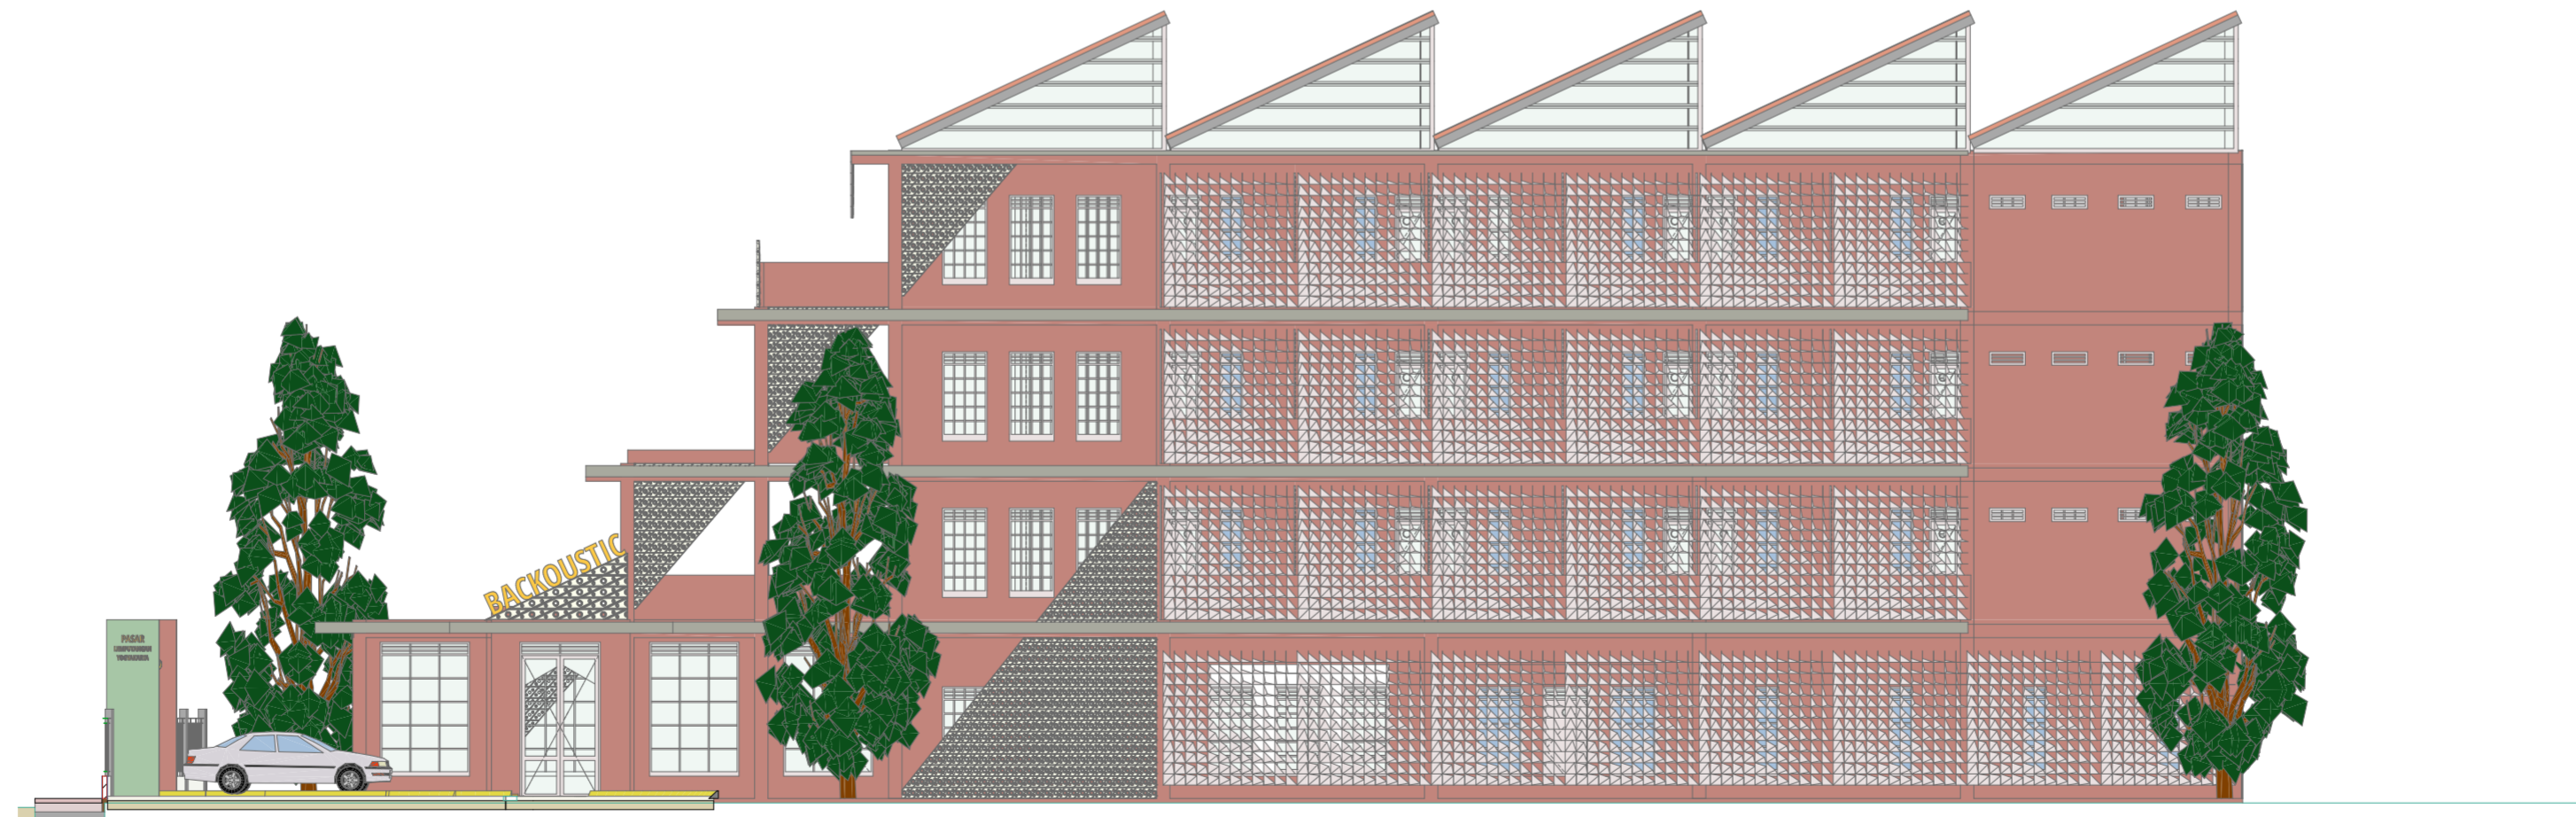

04
-

NORTH ELEVATION
1:150

NOTES
THESE DRAWINGS ARE AN INSTRUMENT OF SERVICE AND ARE THE PROPERTY OF THE CREATOR. ANY USE OF THE DRAWINGS WITHOUT THE PRIOR EXPRESS WRITTEN PERMISSION OF THE CREATOR IS A VIOLATION OF COPYRIGHT AND WILL BE LIABLE TO PROSECUTION. DO NOT SCALE FROM DRAWINGS. USE ONLY GIVEN DIMENSIONS. ALL DIMENSIONS ARE IN MILLIMETERS UNLESS OTHERWISE NOTED.

△		
△		
△		
△		

REV	DATE	REVISION STATUS	STATUS
-----	------	-----------------	--------

PROJECT		
HOTEL BACKPACKER DI PASAR LEMPUNYANGAN YOGYAKARTA		
INSTITUTION		
DEPARTMENT OF ARCHITECTURE FACULTY OF CIVIL AND ENGINEERING PLANNING, UII.		
NAME		STUDENT IDENTITY
FARA HAJAR P ARCHITECT		14512041

DRAWING TITLE
SOUTH & NORTH ELEVATION

DRAWING BY
FARA HAJAR P


STATUS
PRELIMINARY DESIGN

SKALA
1:150

DRAWING NO.
04

	NAME	SIGN	DATE
DRAWN BY	FARA HAJAR P		
CHECKED BY			
APPROVED BY			

 PAGE
8
TOTAL PAGE
29





04
-

WEST ELEVATION
1:150



04
-

EAST ELEVATION
1:150

NOTES
THESE DRAWINGS ARE AN INSTRUMENT OF SERVICE AND ARE THE PROPERTY OF THE CREATOR. ANY USE OF THE DRAWINGS WITHOUT THE PRIOR EXPRESS WRITTEN PERMISSION OF THE CREATOR IS A VIOLATION OF COPYRIGHT AND WILL BE LIABLE TO PROSECUTION. DO NOT SCALE FROM DRAWINGS. USE ONLY GIVEN DIMENSIONS. ALL DIMENSIONS ARE IN MILLIMETERS UNLESS OTHERWISE NOTED.

△		
△		
△		
△		

REV	DATE	REVISION STATUS	STATUS
-----	------	-----------------	--------

PROJECT		<i>Sakowic</i>
HOTEL BACKPACKER DI PASAR LEMPİYANGAN YOGYAKARTA		
INSTITUTION		DEPARTMENT OF ARCHITECTURE
DEPARTMENT OF ARCHITECTURE FACULTY OF CIVIL AND ENGINEERING PLANNING, UII.		
NAME	STUDENT IDENTITY	
FARA HAJAR P ARCHITECT	14512041	

DRAWING TITLE
EAST & WEST ELEVATION

DRAWING BY
FARA HAJAR P


STATUS
PRELIMINARY DESIGN

SKALA
1:150

DRAWING NO.
04

	NAME	SIGN	DATE
DRAWN BY	FARA HAJAR P		
CHECKED BY			
APPROVED BY			

	PAGE	9
	TOTAL PAGE	29

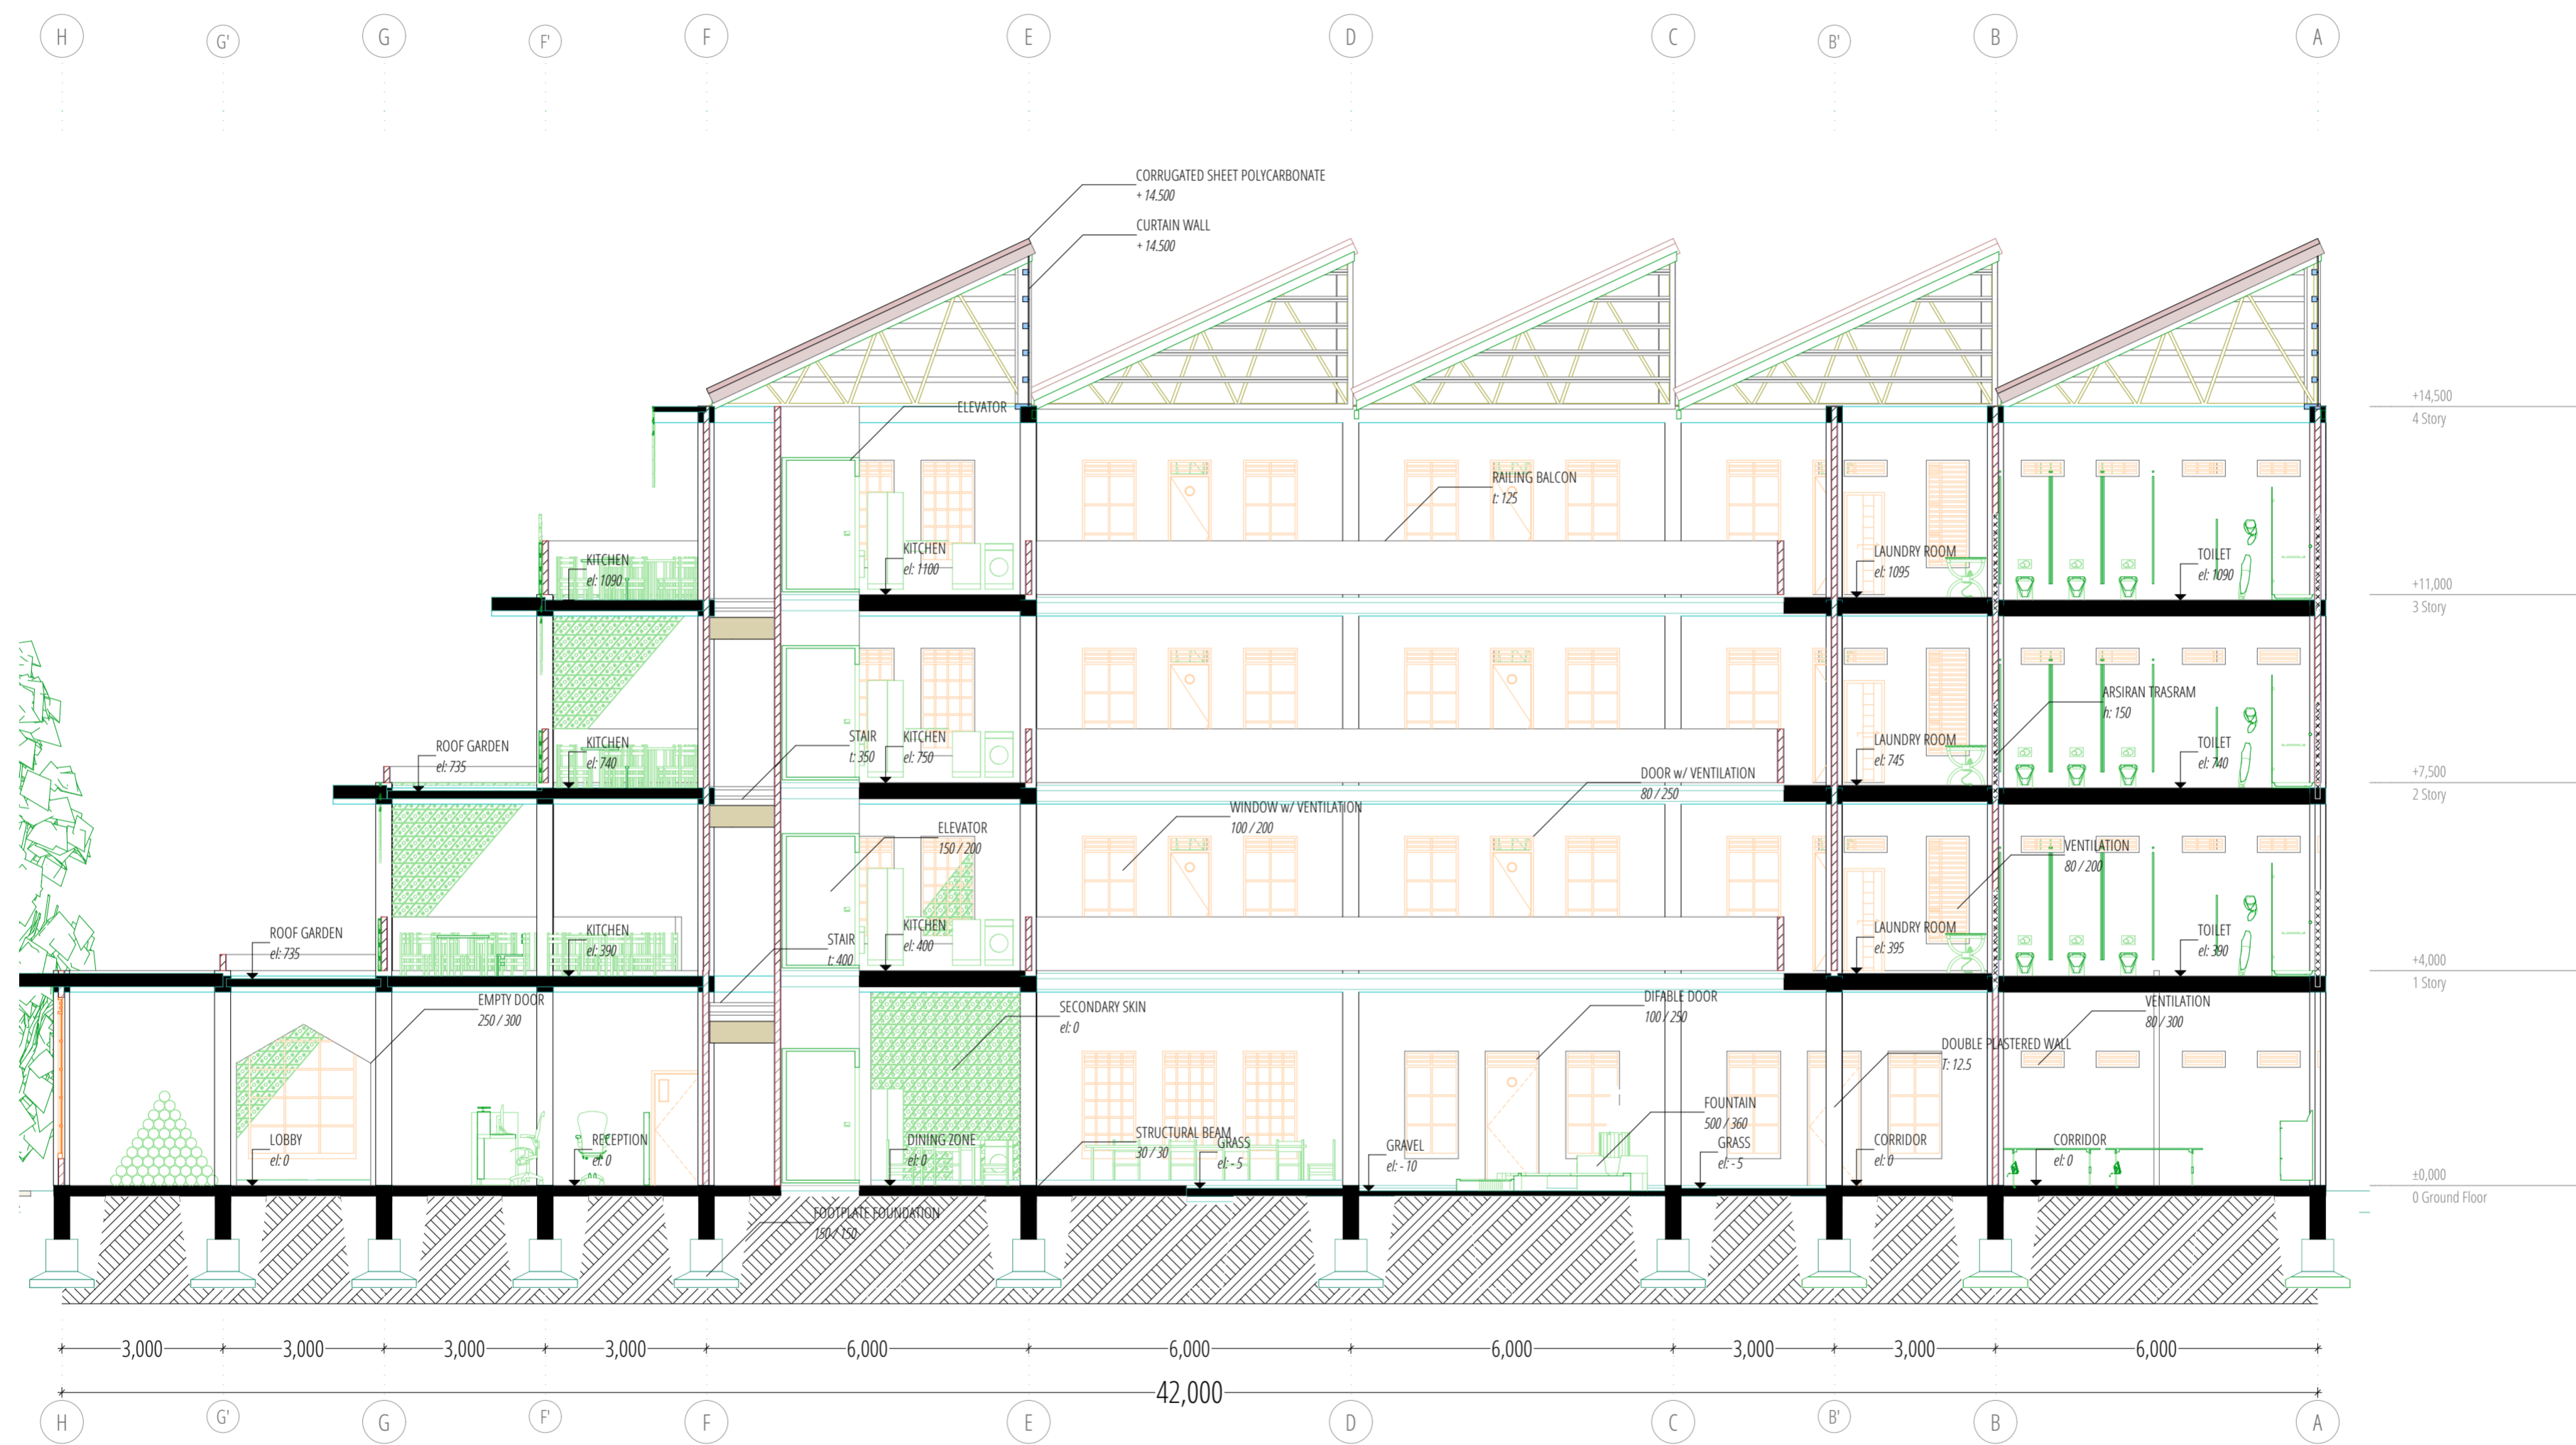

NOTES
 THESE DRAWINGS ARE AN INSTRUMENT OF SERVICE AND ARE THE PROPERTY OF THE CREATOR. ANY USE OF THE DRAWINGS WITHOUT THE PRIOR EXPRESS WRITTEN PERMISSION OF THE CREATOR IS A VIOLATION OF COPYRIGHT AND WILL BE LIABLE TO PROSECUTION. DO NOT SCALE FROM DRAWINGS. USE ONLY GIVEN DIMENSIONS. ALL DIMENSIONS ARE IN MILLIMETERS UNLESS OTHERWISE NOTED.

REV	DATE	REVISION STATUS	STATUS

PROJECT		
HOTEL BACKPACKER DI PASAR LEMPUYANGAN YOGYAKARTA		
INSTITUTION		
DEPARTMENT OF ARCHITECTURE FACULTY OF CIVIL AND ENGINEERING PLANNING, UII.		
NAME	STUDENT IDENTITY	
FARA HAJAR P ARCHITECT	14512041	

DRAWING TITLE
A-A' BUILDING SECTION

DRAWING BY
 FARA HAJAR P

STATUS
 PRELIMINARY DESIGN


SKALA
 1:100

DRAWING NO.
 05

DRAWN BY	NAME	SIGN	DATE
CHECKED BY			
APPROVED BY			

05

BUILDING SECTION
 1:100

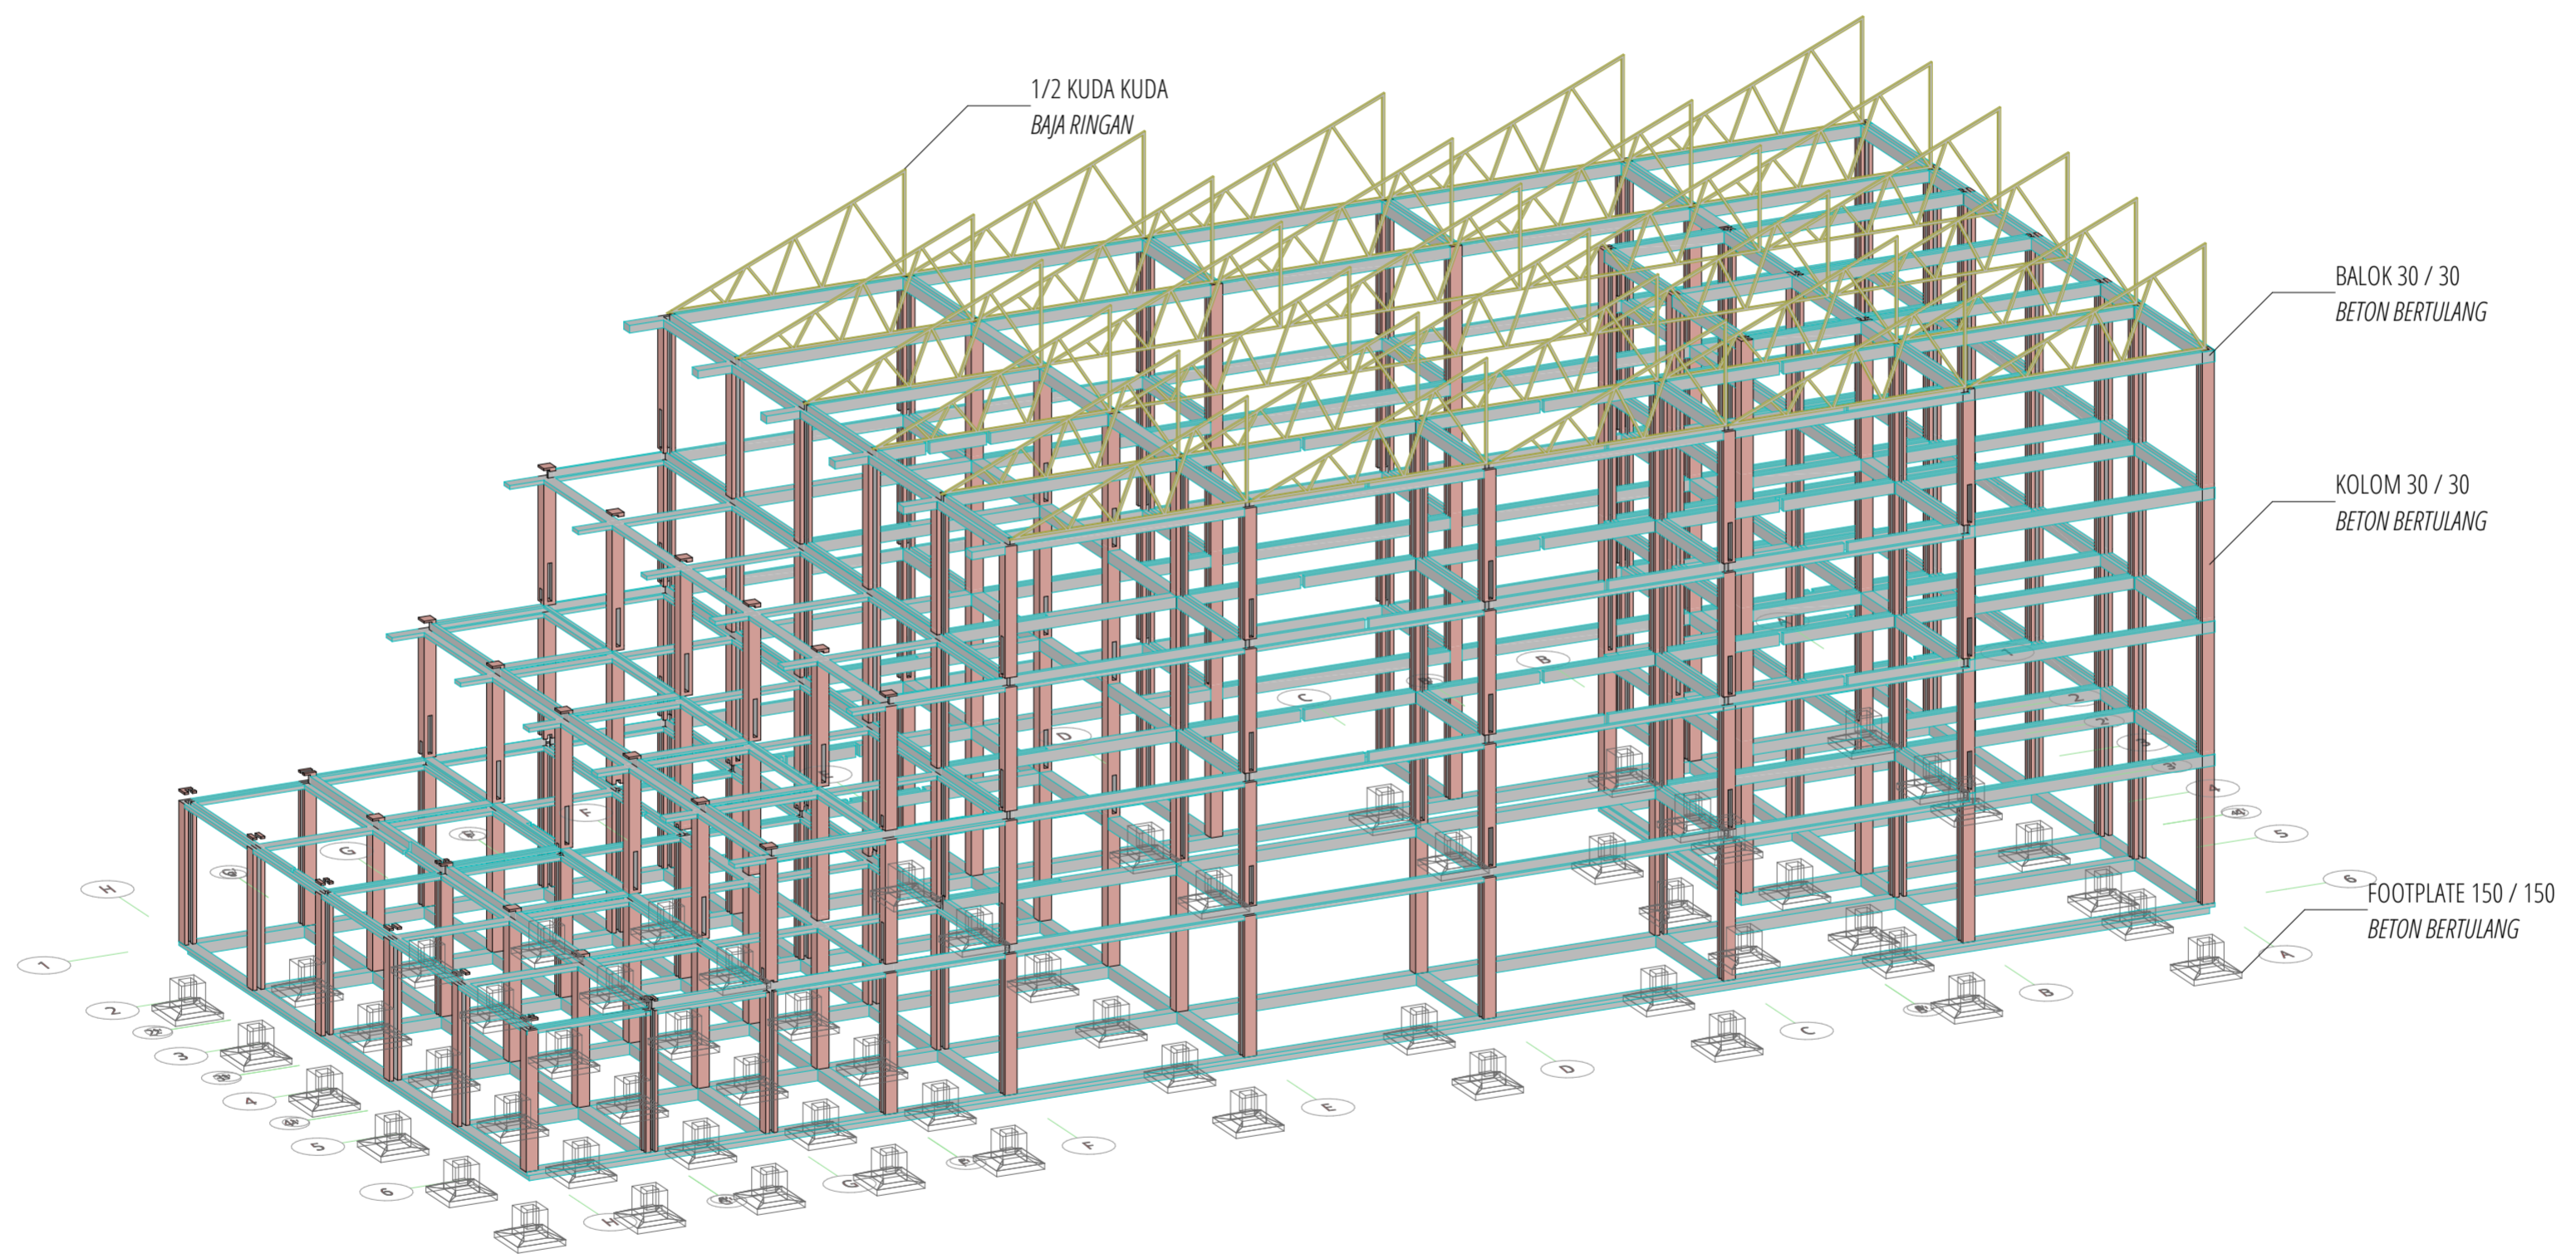

06
-

STRUCTURE SCHEME
1:150

NOTES
THESE DRAWINGS ARE AN INSTRUMENT OF SERVICE AND ARE THE PROPERTY OF THE CREATOR. ANY USE OF THE DRAWINGS WITHOUT THE PRIOR EXPRESS WRITTEN PERMISSION OF THE CREATOR IS A VIOLATION OF COPYRIGHT AND WILL BE LIABLE TO PROSECUTION. DO NOT SCALE FROM DRAWINGS. USE ONLY GIVEN DIMENSIONS. ALL DIMENSIONS ARE IN MILLIMETERS UNLESS OTHERWISE NOTED.

△			
△			
△			
△			

REV	DATE	REVISION STATUS	STATUS

PROJECT		<i>Sakowic</i>
HOTEL BACKPACKER DI PASAR LEMPUYANGAN YOGYAKARTA		
INSTITUTION		DEPARTMENT OF ARCHITECTURE
DEPARTMENT OF ARCHITECTURE FACULTY OF CIVIL AND ENGINEERING PLANNING, UII.		
NAME		STUDENT IDENTITY
FARA HAJAR P ARCHITECT		14512041

DRAWING TITLE
STRUCTURE SCHEME

DRAWING BY
FARA HAJAR P

STATUS
PRELIMINARY DESIGN

SKALA
1:150


DRAWING NO.
06

	NAME	SIGN	DATE
DRAWN BY	FARA HAJAR P		
CHECKED BY			
APPROVED BY			

PAGE
11


TOTAL PAGE
29

N

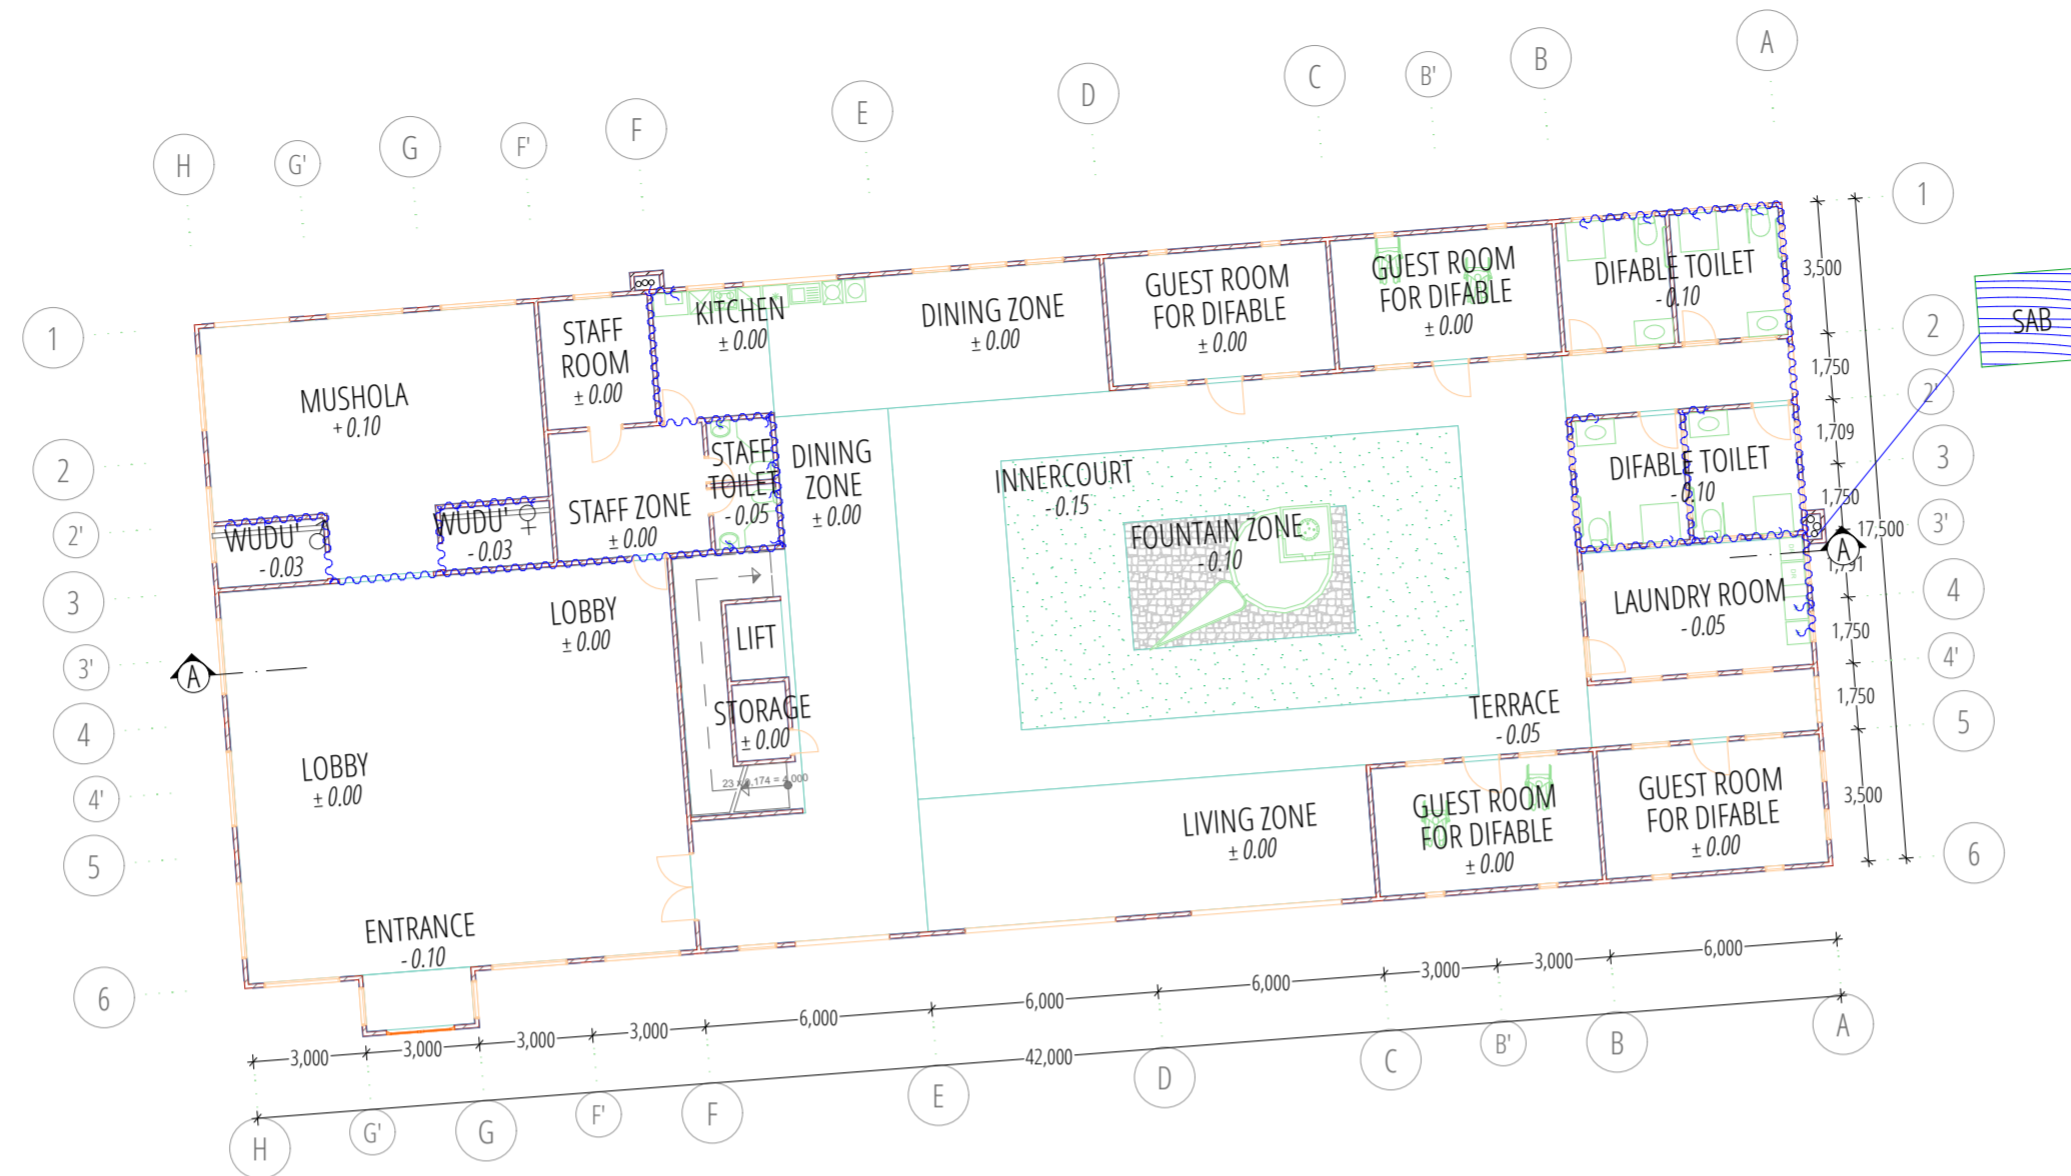

07-01
-





GF CLEAN WATER PLAN
1:200

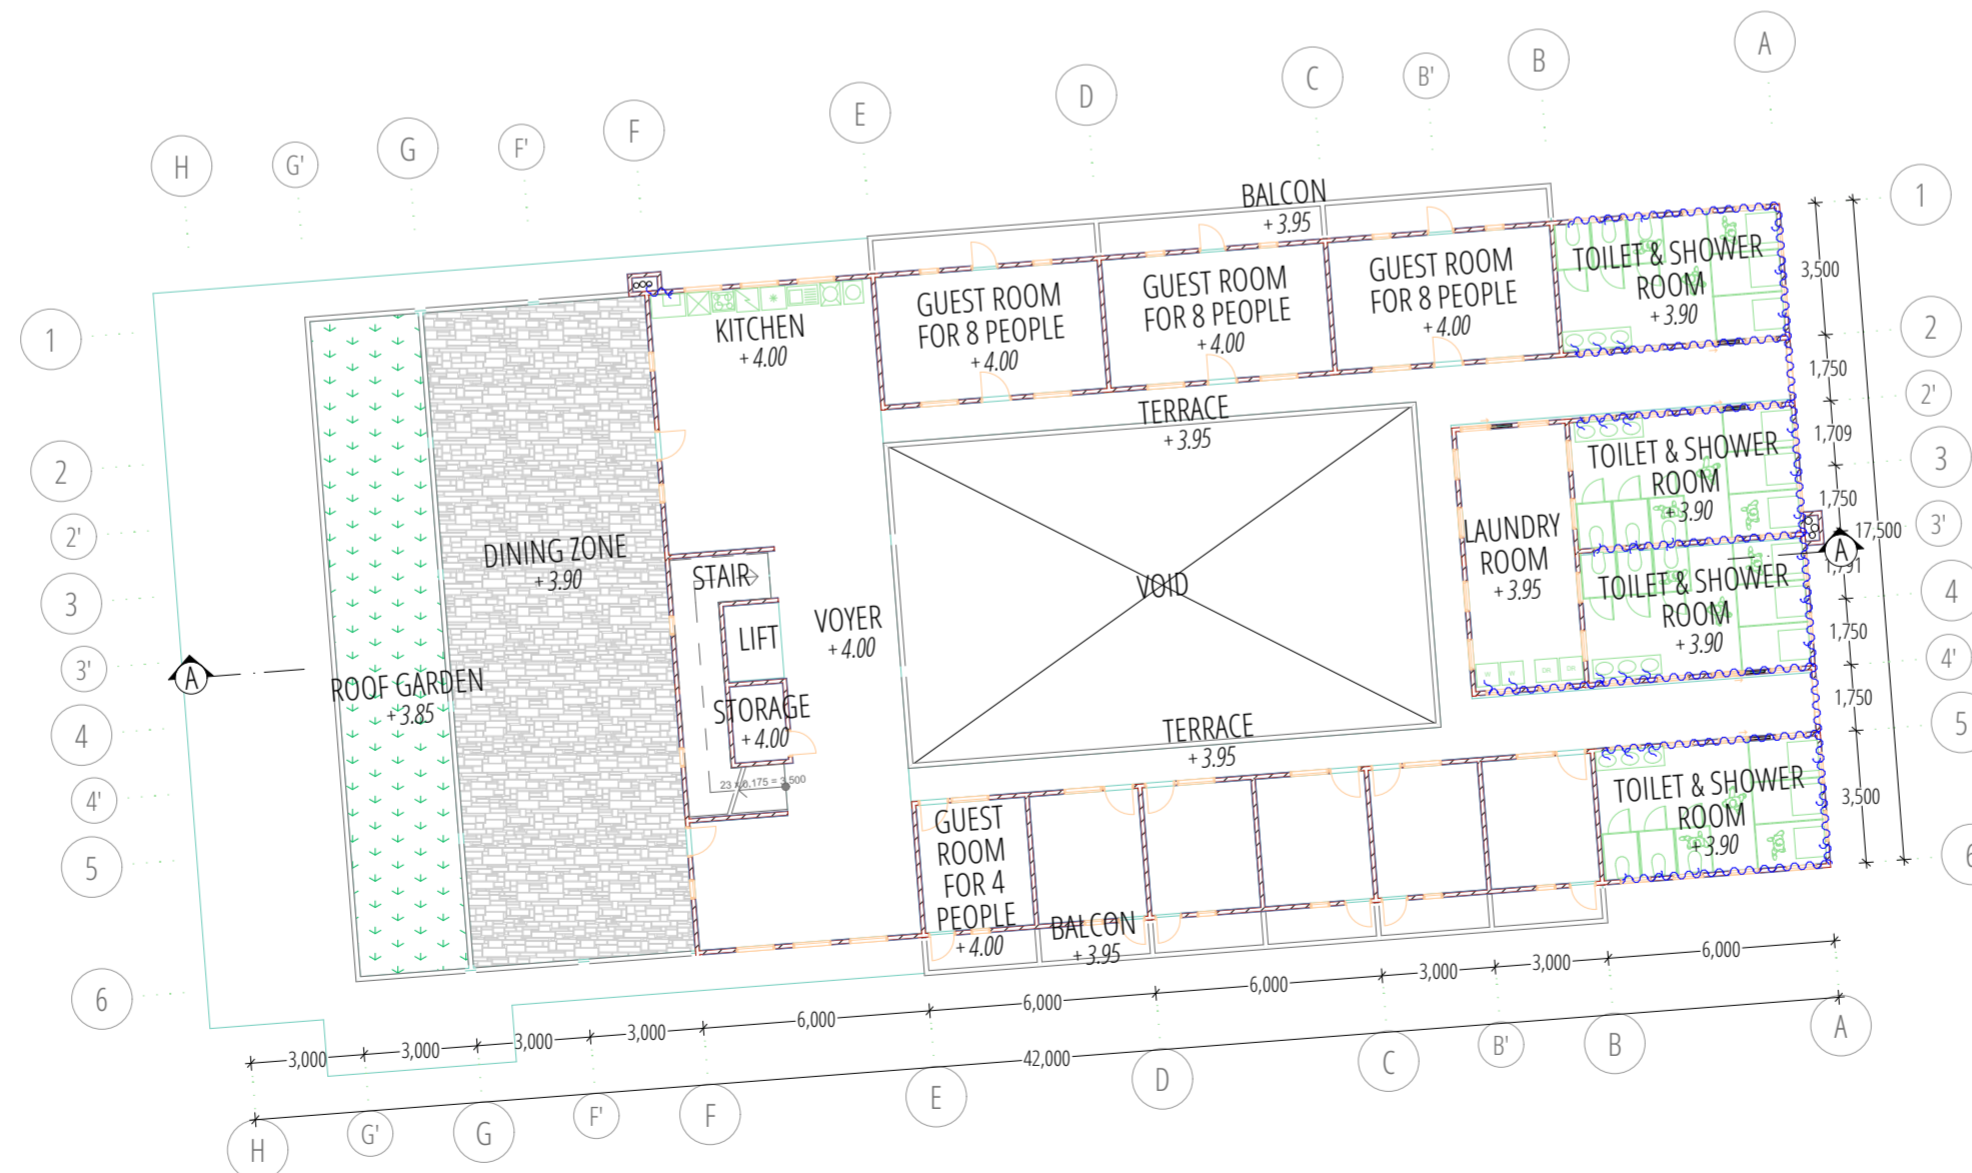

07-01
-

1ST FLOOR CLEAN WATER PLAN
1:200

    KETERANGAN

-  SUMUR AIR BERSIH
-  SEPTIC TANK
-  SUMUR RESAPAN
-  BAK KONTROL LEMAK

NOTES
THESE DRAWINGS ARE AN INSTRUMENT OF SERVICE AND ARE THE PROPERTY OF THE CREATOR. ANY USE OF THE DRAWINGS WITHOUT THE PRIOR EXPRESS WRITTEN PERMISSION OF THE CREATOR IS A VIOLATION OF COPYRIGHT AND WILL BE LIABLE TO PROSECUTION. DO NOT SCALE FROM DRAWINGS. USE ONLY GIVEN DIMENSIONS. ALL DIMENSIONS ARE IN MILLIMETERS UNLESS OTHERWISE NOTED.

△		
△		
△		
△		

REV	DATE	REVISION STATUS	STATUS

PROJECT		
HOTEL BACKPACKER DI PASAR LEMPUYANGAN YOGYAKARTA		
INSTITUTION		
DEPARTMENT OF ARCHITECTURE FACULTY OF CIVIL AND ENGINEERING PLANNING, UII.		
NAME		STUDENT IDENTITY
FARA HAJAR P ARCHITECT		14512041

DRAWING TITLE	CLEAN WATER PLAN
---------------	------------------


DRAWING BY	FARA HAJAR P
------------	--------------


STATUS	PRELIMINARY DESIGN
--------	--------------------

SKALA	1:200
-------	-------

DRAWING NO.	07-01
-------------	-------


	NAME	SIGN	DATE
DRAWN BY	FARA HAJAR P		
CHECKED BY			
APPROVED BY			

	PAGE	12
	TOTAL PAGE	29

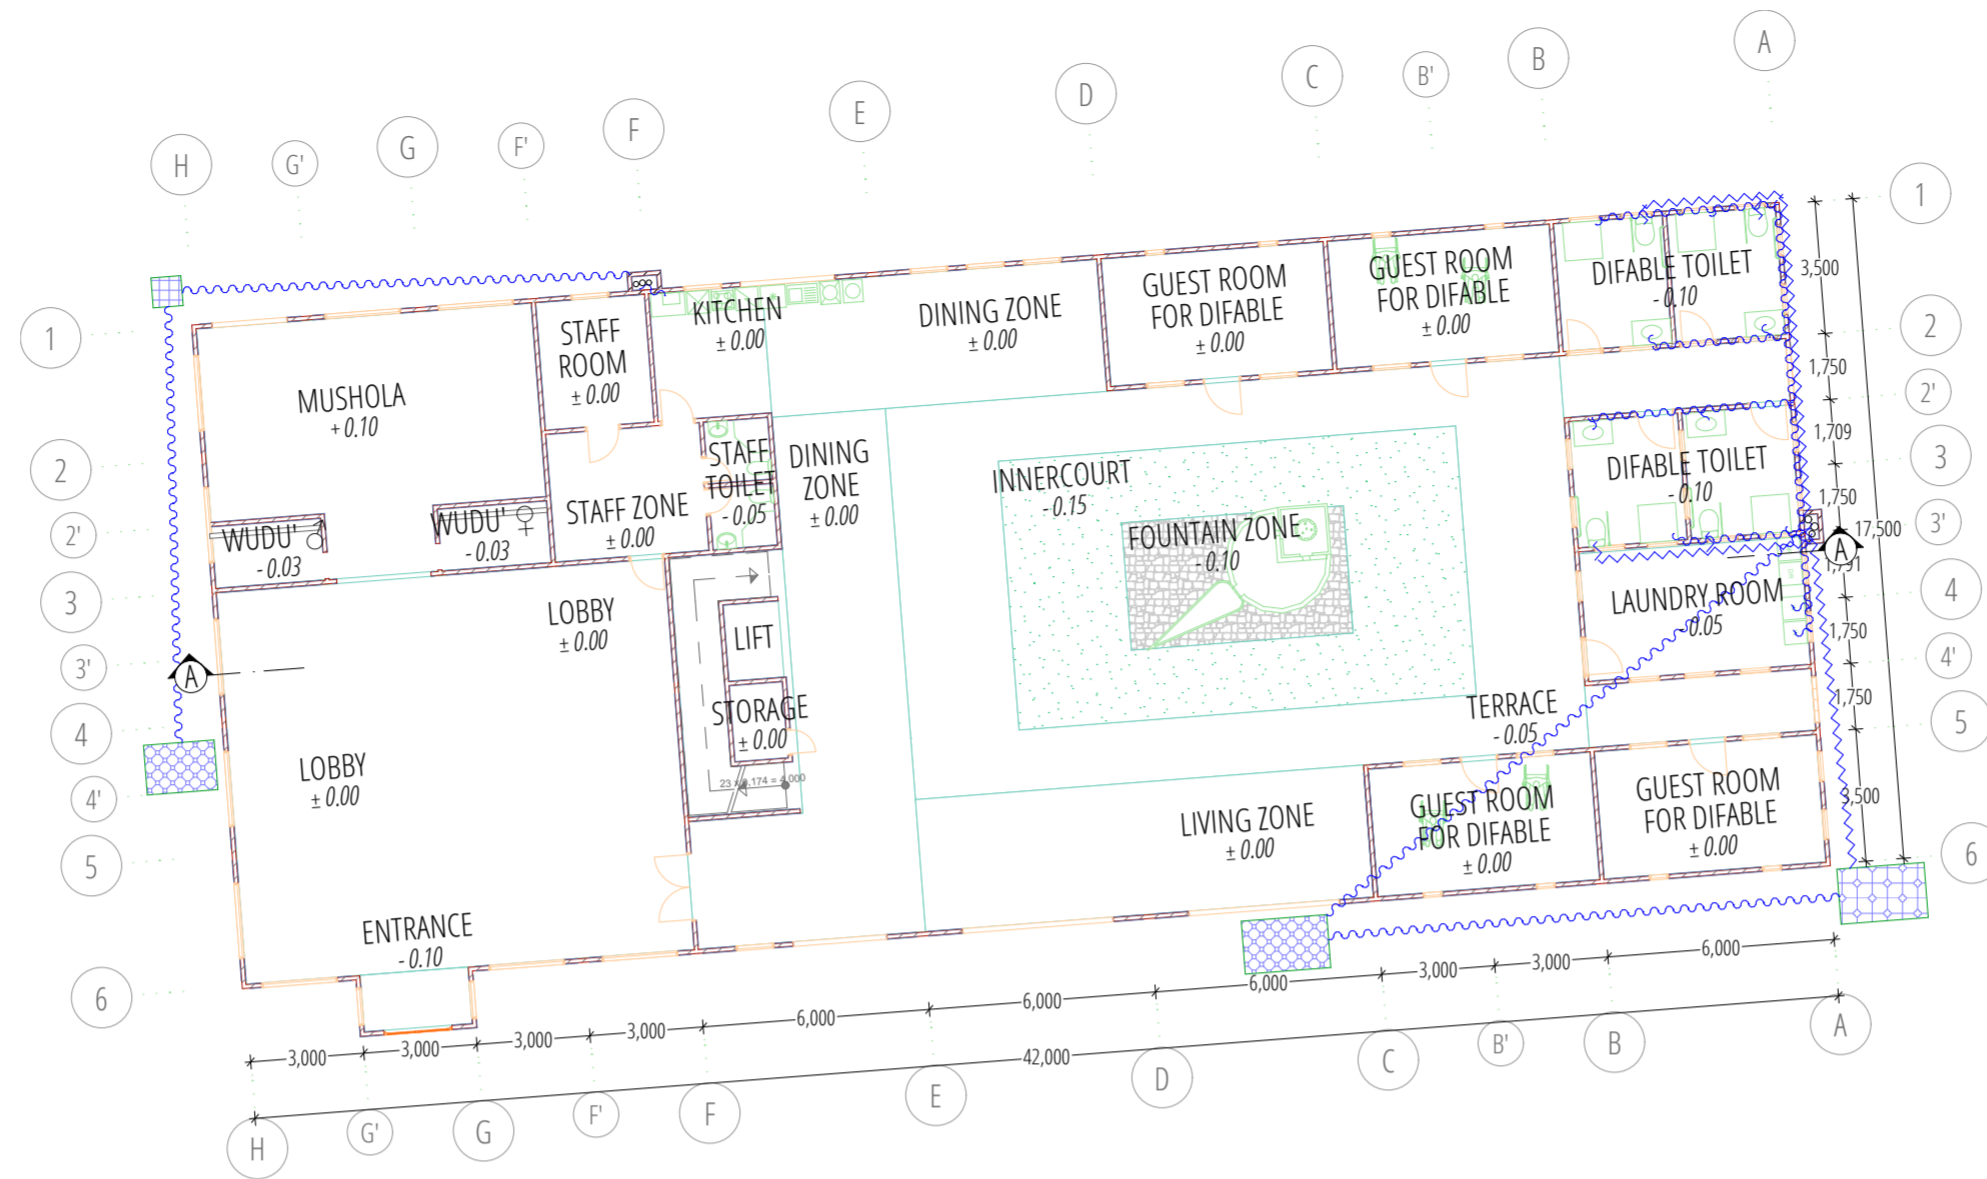

07-02
-





GF GREY WATER PLAN
1:200

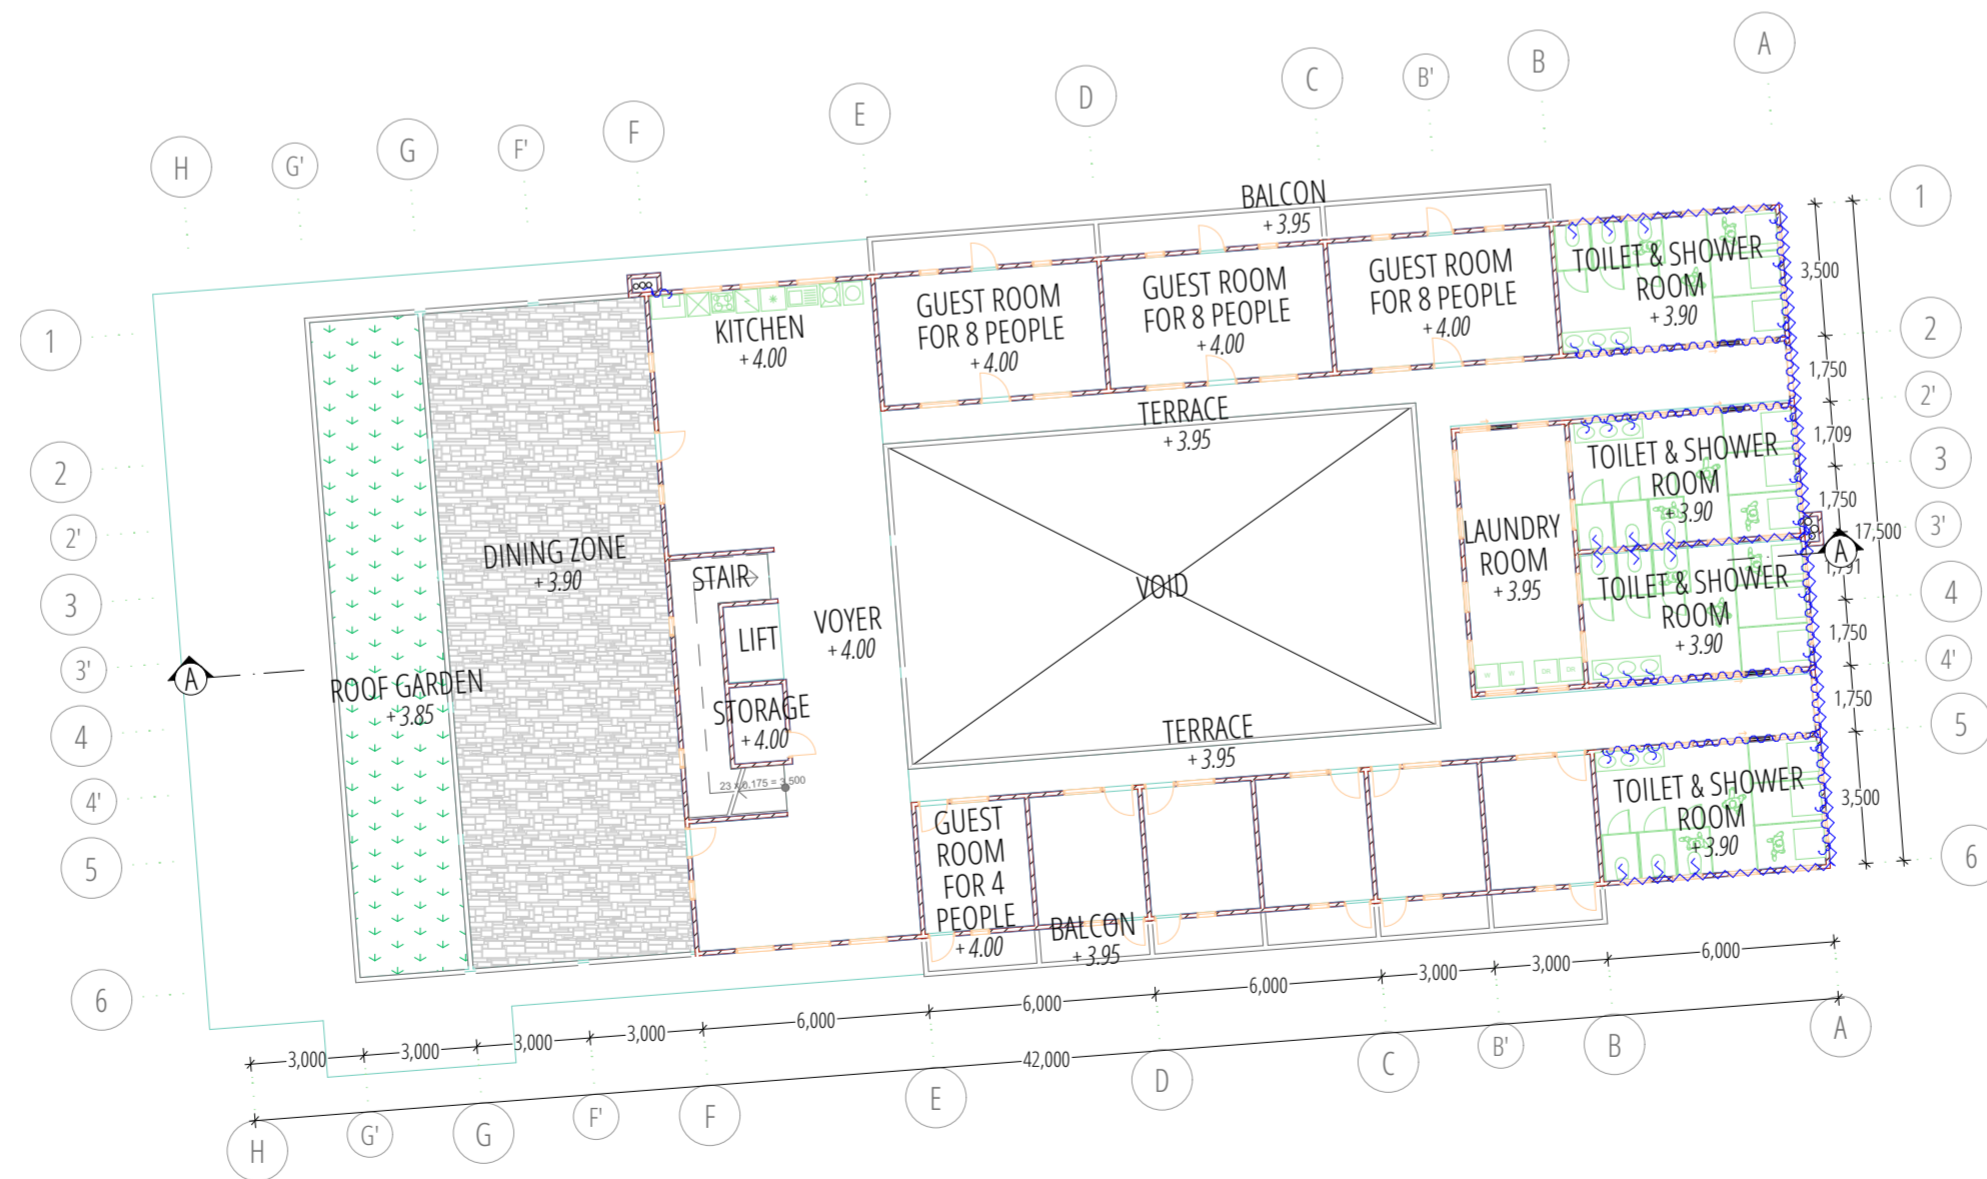

07-02
-

1ST FLOOR GREY WATER PLAN
1:200

    KETERANGAN

-  SUMUR AIR BERSIH
-  SEPTIC TANK
-  SUMUR RESAPAN
-  BAK KONTROL LEMAK

NOTES
THESE DRAWINGS ARE AN INSTRUMENT OF SERVICE AND ARE THE PROPERTY OF THE CREATOR. ANY USE OF THE DRAWINGS WITHOUT THE PRIOR EXPRESS WRITTEN PERMISSION OF THE CREATOR IS A VIOLATION OF COPYRIGHT AND WILL BE LIABLE TO PROSECUTION. DO NOT SCALE FROM DRAWINGS. USE ONLY GIVEN DIMENSIONS. ALL DIMENSIONS ARE IN MILLIMETERS UNLESS OTHERWISE NOTED.

△		
△		
△		
△		

REV	DATE	REVISION STATUS	STATUS

PROJECT		
HOTEL BACKPACKER DI PASAR LEMPUNGAN YOGYAKARTA		
INSTITUTION		
DEPARTMENT OF ARCHITECTURE FACULTY OF CIVIL AND ENGINEERING PLANNING, UII.		
NAME		STUDENT IDENTITY
FARA HAJAR P ARCHITECT		14512041

DRAWING TITLE	GREY WATER PLAN
---------------	-----------------


DRAWING BY	FARA HAJAR P
------------	--------------

STATUS	PRELIMINARY DESIGN
--------	--------------------

SKALA	1:200
-------	-------

DRAWING NO.	07-02
-------------	-------


DRAWN BY	NAME	SIGN	DATE
CHECKED BY			
APPROVED BY			

	PAGE	13
	TOTAL PAGE	29




07-03
-


VERTICAL TRANSPORTATION PLAN
1:200

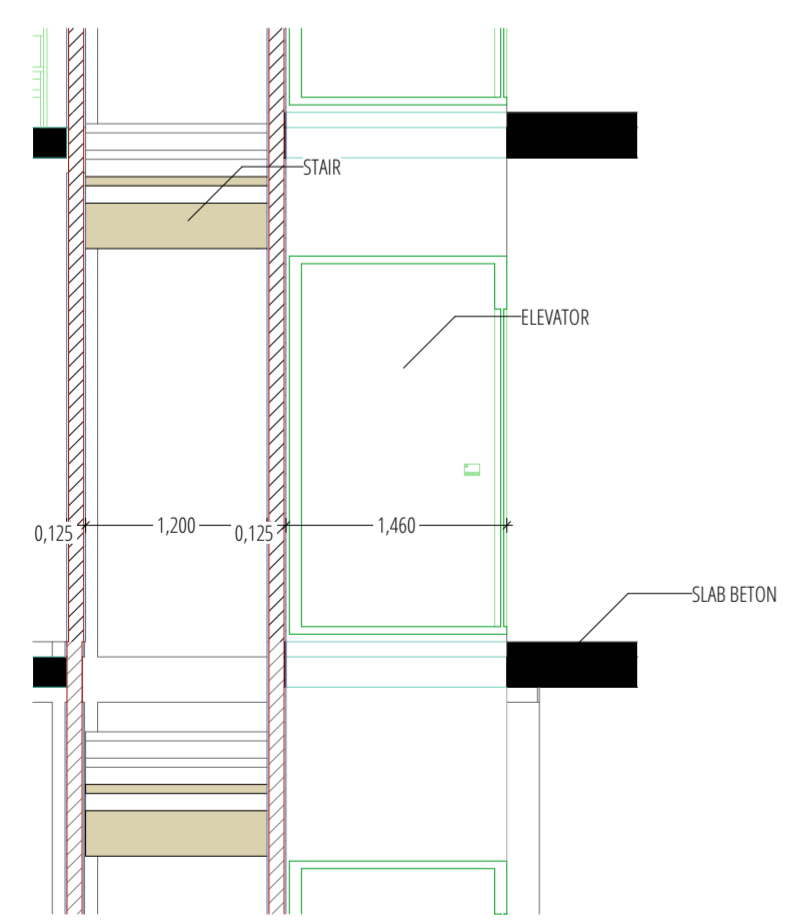

07 03
- T1 VERTICAL TRANSPORTAION SECTION
1:50

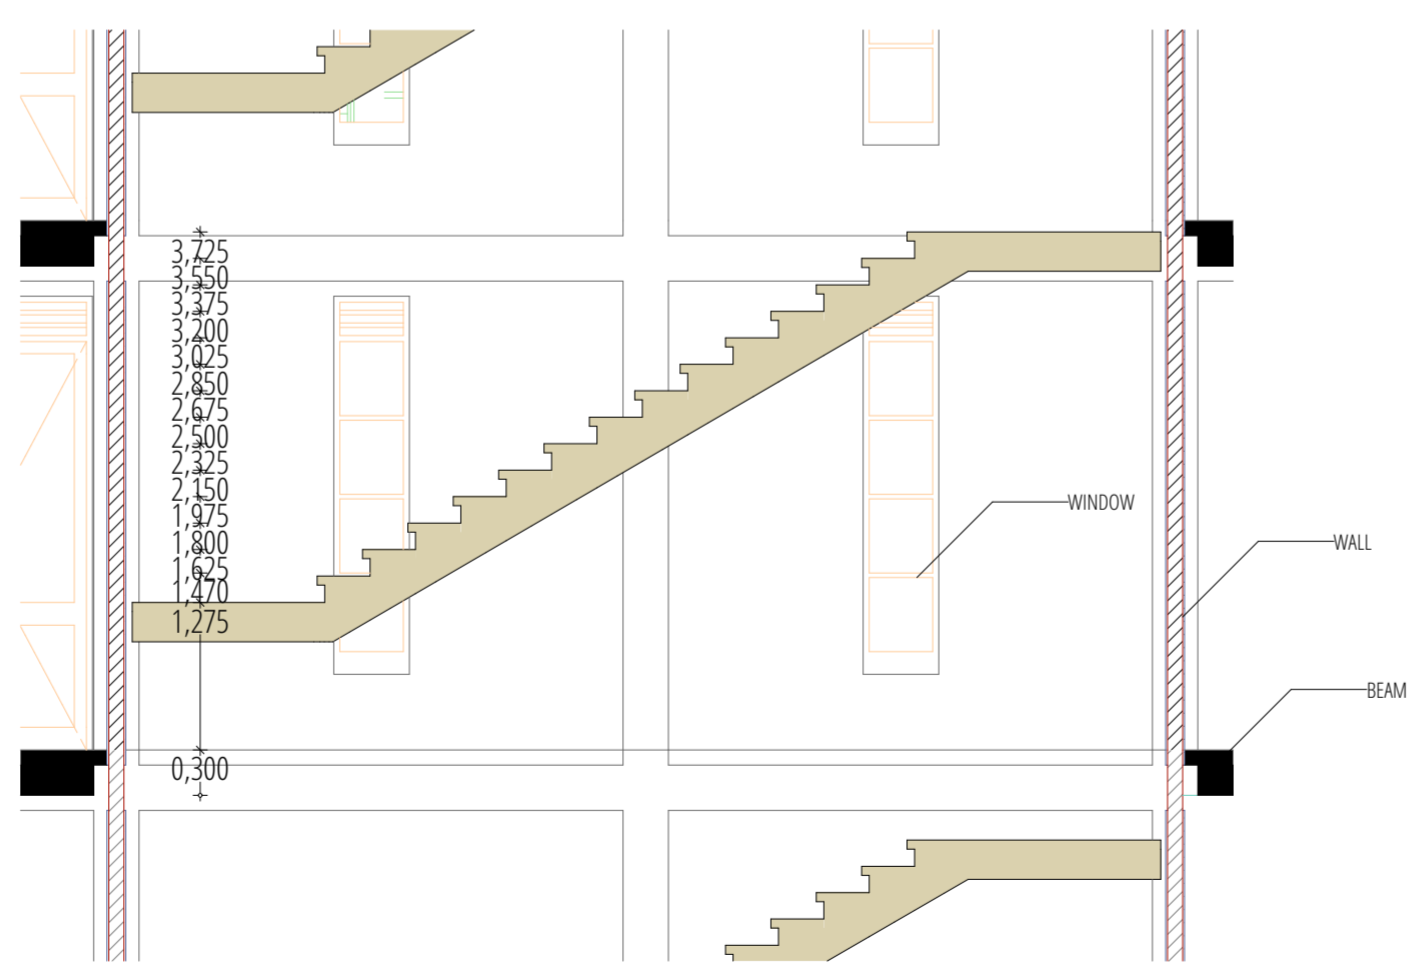

07 03
- T2 VERTICAL TRANSPORTAION SECTION
1:50

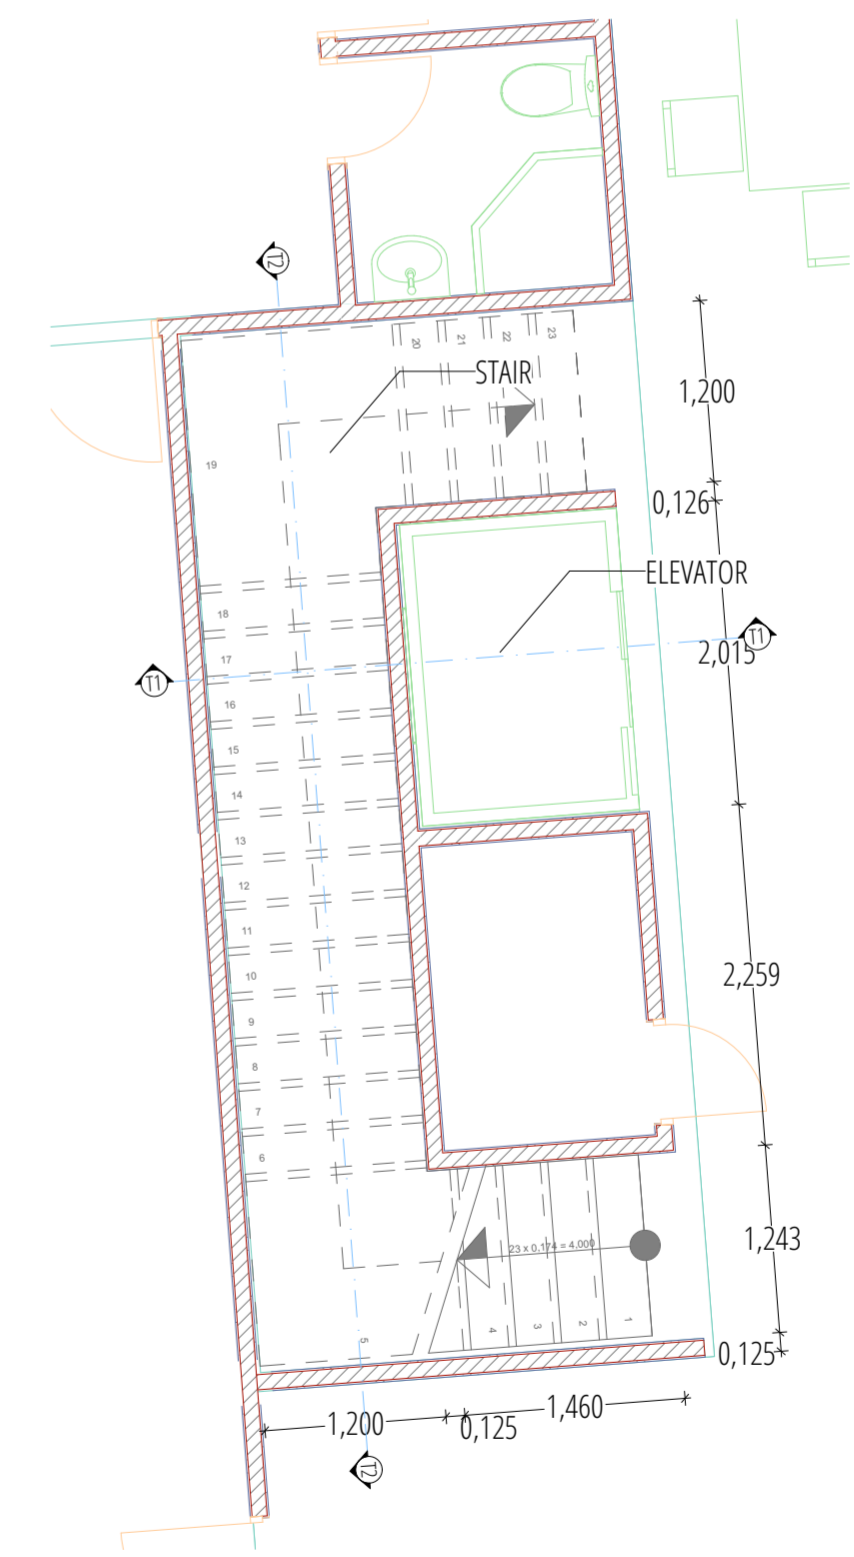

07-03
- STAIR & ELEVATOR DETAIL
1:50

NOTES
THESE DRAWINGS ARE AN INSTRUMENT OF SERVICE AND ARE THE PROPERTY OF THE CREATOR. ANY USE OF THE DRAWINGS WITHOUT THE PRIOR EXPRESS WRITTEN PERMISSION OF THE CREATOR IS A VIOLATION OF COPYRIGHT AND WILL BE LIABLE TO PROSECUTION. DO NOT SCALE FROM DRAWINGS. USE ONLY GIVEN DIMENSIONS. ALL DIMENSIONS ARE IN MILLIMETERS UNLESS OTHERWISE NOTED.

△			
△			
△			
△			

REV	DATE	REVISION STATUS	STATUS

PROJECT		<i>Sakomir</i>
HOTEL BACKPACKER DI PASAR LEMPUYANGAN YOGYAKARTA		
INSTITUTION		DEPARTMENT OF ARCHITECTURE
DEPARTMENT OF ARCHITECTURE FACULTY OF CIVIL AND ENGINEERING PLANNING, UII.		
NAME	STUDENT IDENTITY	
FARA HAJAR P ARCHITECT	14512041	

DRAWING TITLE
VERTICAL TRANSPORTATION


DRAWING BY
FARA HAJAR P


STATUS
PRELIMINARY DESIGN

SKALA
1:200,
1:50

DRAWING NO.
07-03, 07


03	NAME	SIGN	DATE
DRAWN BY	FARA HAJAR P		
CHECKED BY			
APPROVED BY			

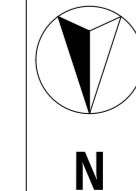

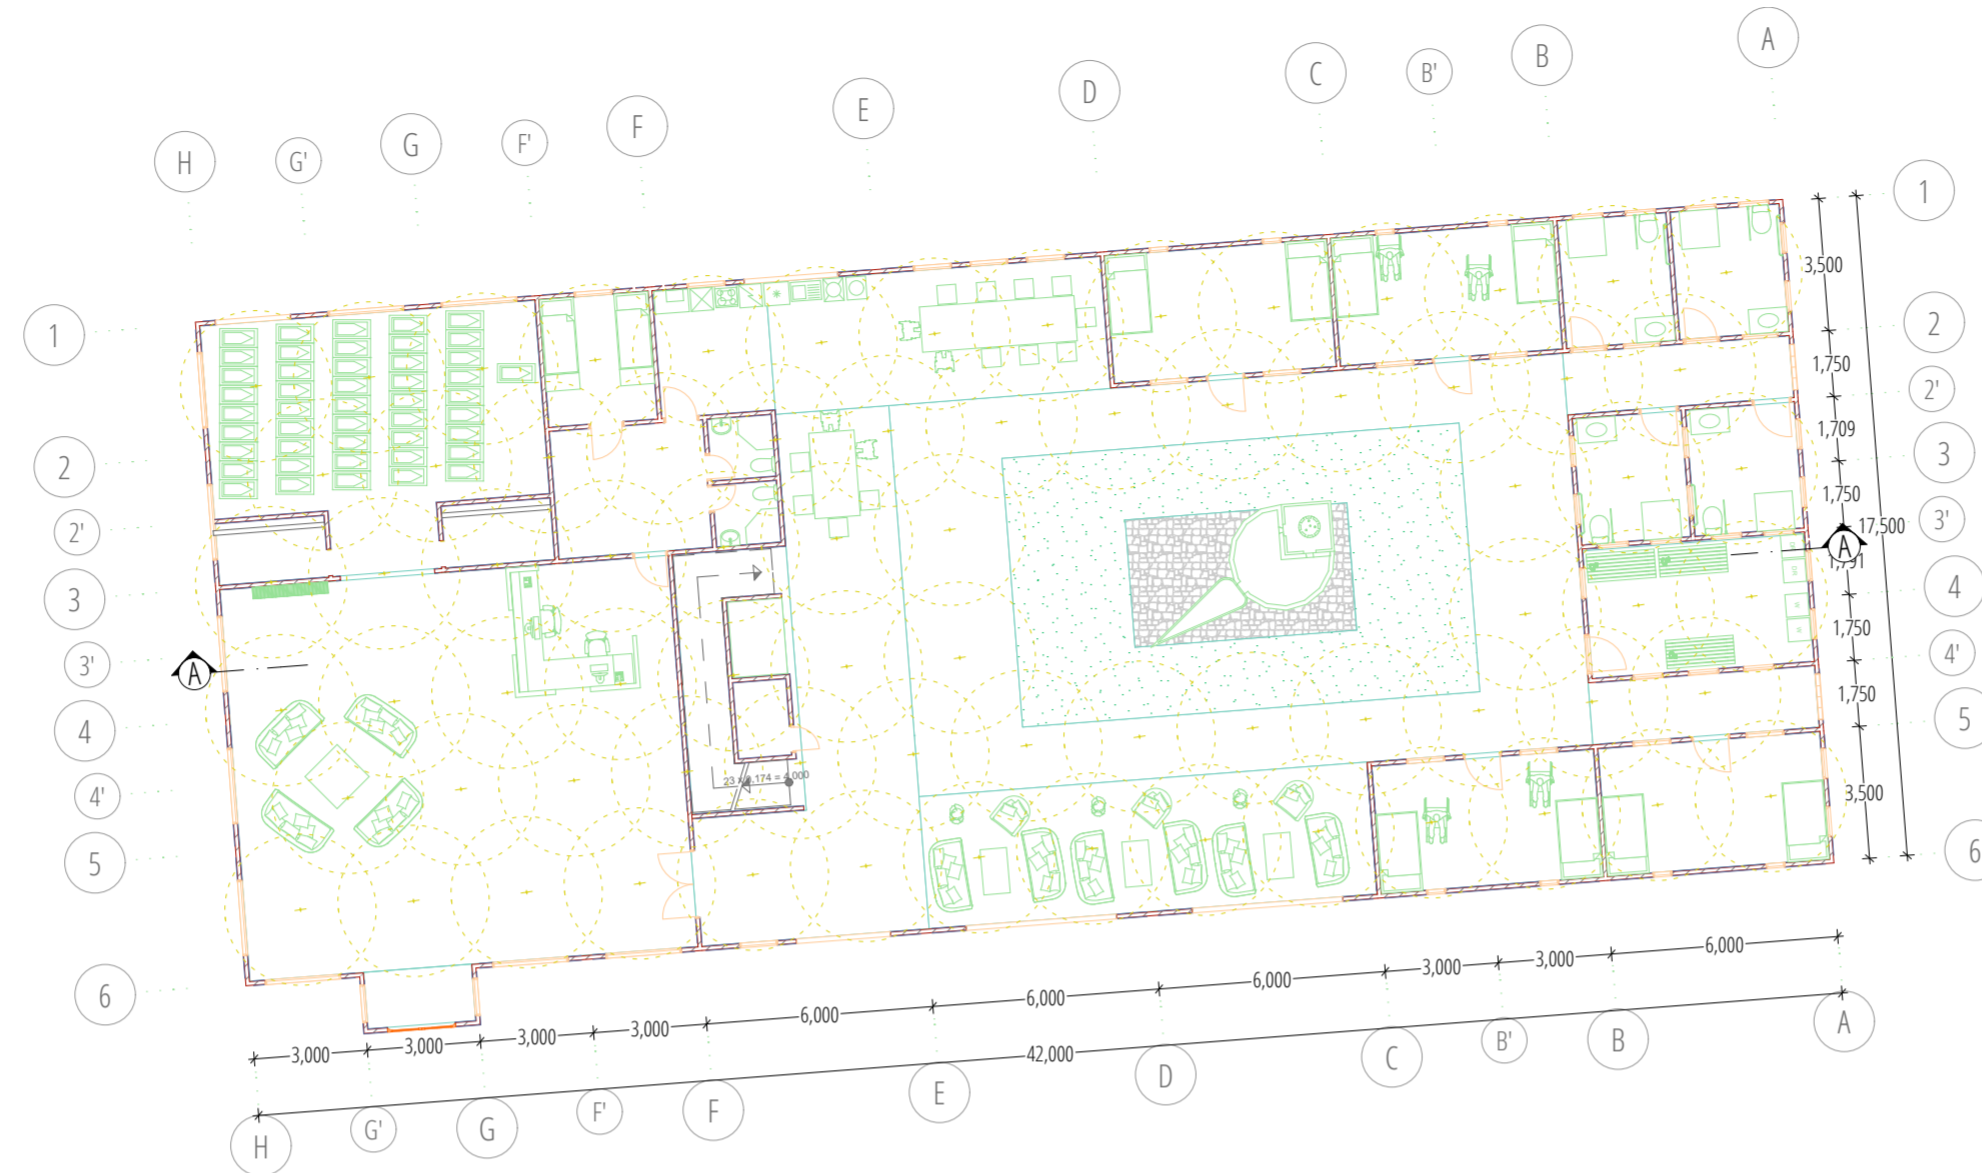

07-04
-

GF LIGHTING PLAN
1:200

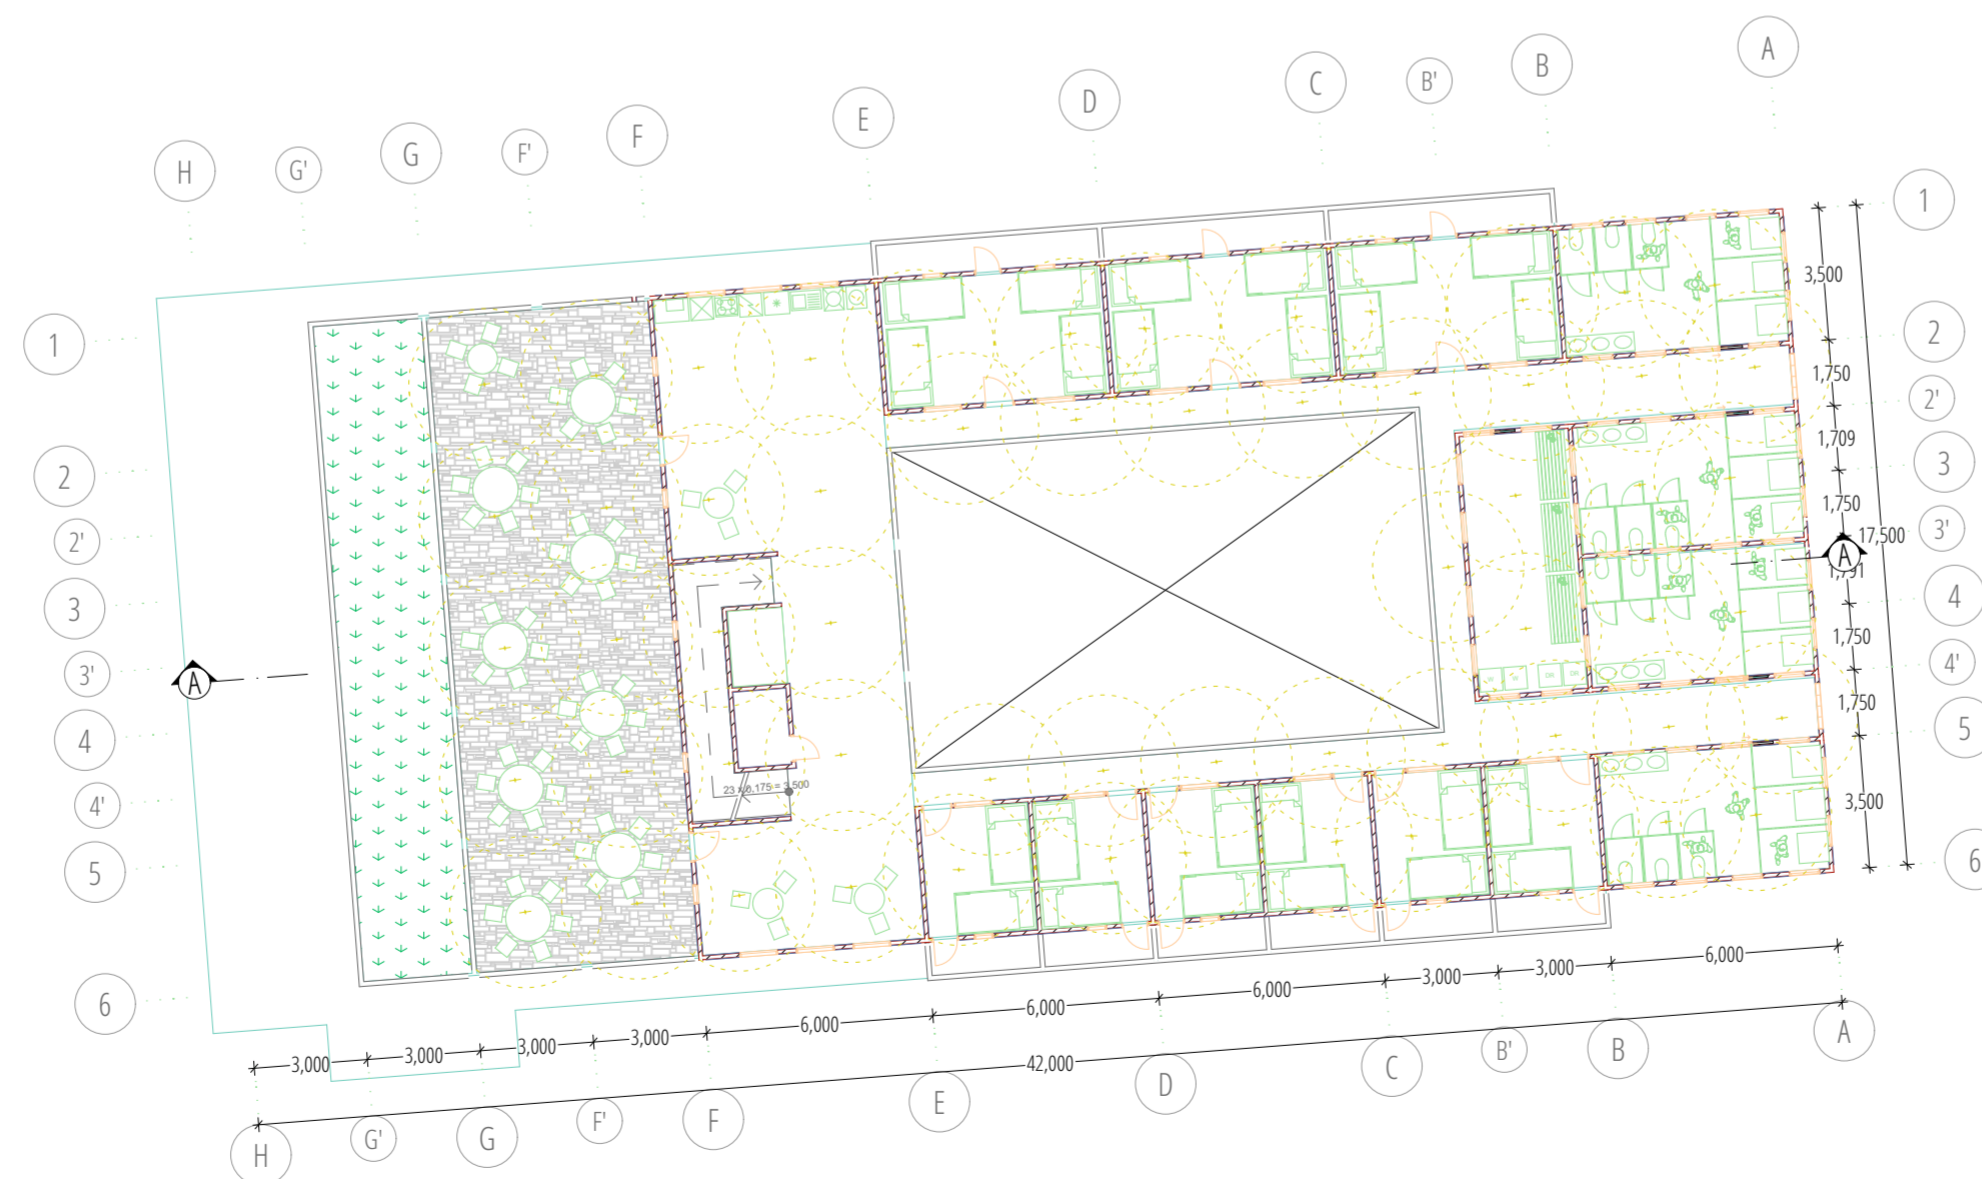

07-04
-

1ST FLOOR LIGHTING PLAN
1:200

NOTES
THESE DRAWINGS ARE AN INSTRUMENT OF SERVICE AND ARE THE PROPERTY OF THE CREATOR. ANY USE OF THE DRAWINGS WITHOUT THE PRIOR EXPRESS WRITTEN PERMISSION OF THE CREATOR IS A VIOLATION OF COPYRIGHT AND WILL BE LIABLE TO PROSECUTION. DO NOT SCALE FROM DRAWINGS. USE ONLY GIVEN DIMENSIONS. ALL DIMENSIONS ARE IN MILLIMETERS UNLESS OTHERWISE NOTED.

△		
△		
△		
△		

REV	DATE	REVISION STATUS	STATUS

PROJECT		<i>Sakomir</i>
HOTEL BACKPACKER DI PASAR LEMPUYANGAN YOGYAKARTA		
INSTITUTION		DEPARTMENT OF ARCHITECTURE
DEPARTMENT OF ARCHITECTURE FACULTY OF CIVIL AND ENGINEERING PLANNING, UII.		
NAME		STUDENT IDENTITY
FARA HAJAR P ARCHITECT		14512041

DRAWING TITLE	ARTIFICIAL LIGHTING PLAN
---------------	--------------------------

DRAWING BY	FARA HAJAR P
------------	--------------

STATUS	PRELIMINARY DESIGN
--------	--------------------

SKALA	1:200
-------	-------

DRAWING NO.	07-04
-------------	-------


DRAWN BY	FARA HAJAR P	SIGN	DATE
CHECKED BY			
APPROVED BY			

	PAGE	15
	TOTAL PAGE	29



07-05
-


GF FIRE PROTECT PLAN
1:200

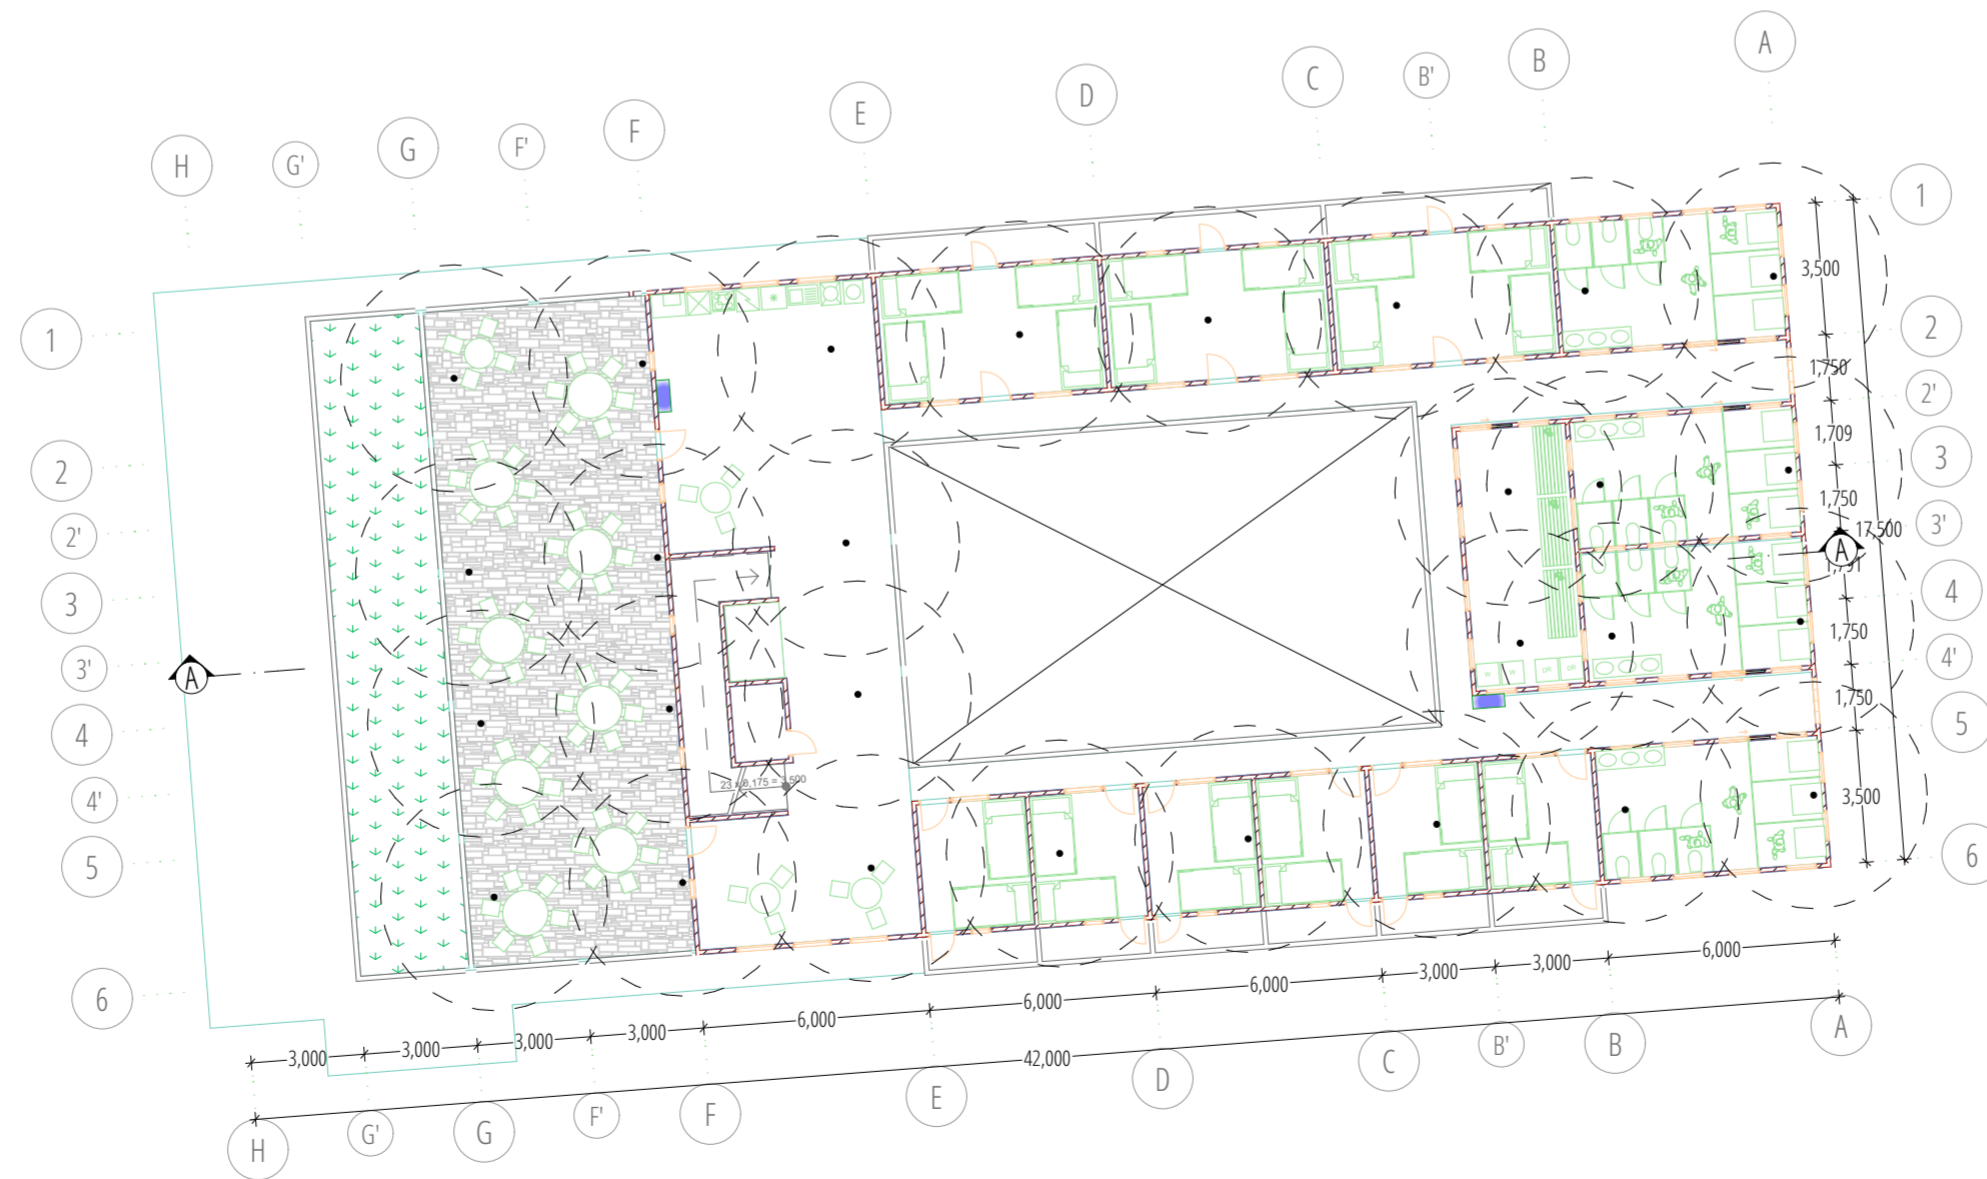


07-05
-

1ST FLOOR FIRE PROTECT PLAN
1:200

KETERANGAN

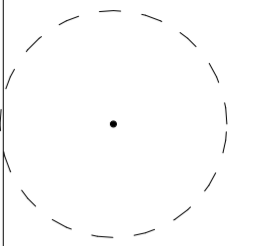

SPRINKLER

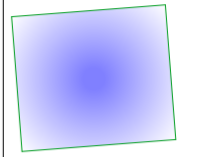

NOTES

THESE DRAWINGS ARE AN INSTRUMENT OF SERVICE AND ARE THE PROPERTY OF THE CREATOR. ANY USE OF THE DRAWINGS WITHOUT THE PRIOR EXPRESS WRITTEN PERMISSION OF THE CREATOR IS A VIOLATION OF COPYRIGHT AND WILL BE LIABLE TO PROSECUTION. DO NOT SCALE FROM DRAWINGS. USE ONLY GIVEN DIMENSIONS. ALL DIMENSIONS ARE IN MILLIMETERS UNLESS OTHERWISE NOTED.

△		
△		
△		
△		

REV	DATE	REVISION STATUS	STATUS

PROJECT		<i>Sadawati</i>
HOTEL BACKPACKER DI PASAR LEMPUYANGAN YOGYAKARTA		
INSTITUTION		DEPARTMENT OF ARCHITECTURE
DEPARTMENT OF ARCHITECTURE FACULTY OF CIVIL AND ENGINEERING PLANNING, UII.		
NAME		STUDENT IDENTITY
FARA HAJAR P ARCHITECT		14512041

DRAWING TITLE	FIRE PROTECT PLAN
---------------	-------------------

DRAWING BY	FARA HAJAR P
------------	--------------

STATUS	PRELIMINARY DESIGN
--------	--------------------


SKALA	1:200
-------	-------

DRAWING NO.	07-05
-------------	-------

	NAME	SIGN	DATE
DRAWN BY	FARA HAJAR P		
CHECKED BY			
APPROVED BY			


	PAGE	16
	TOTAL PAGE	29

N

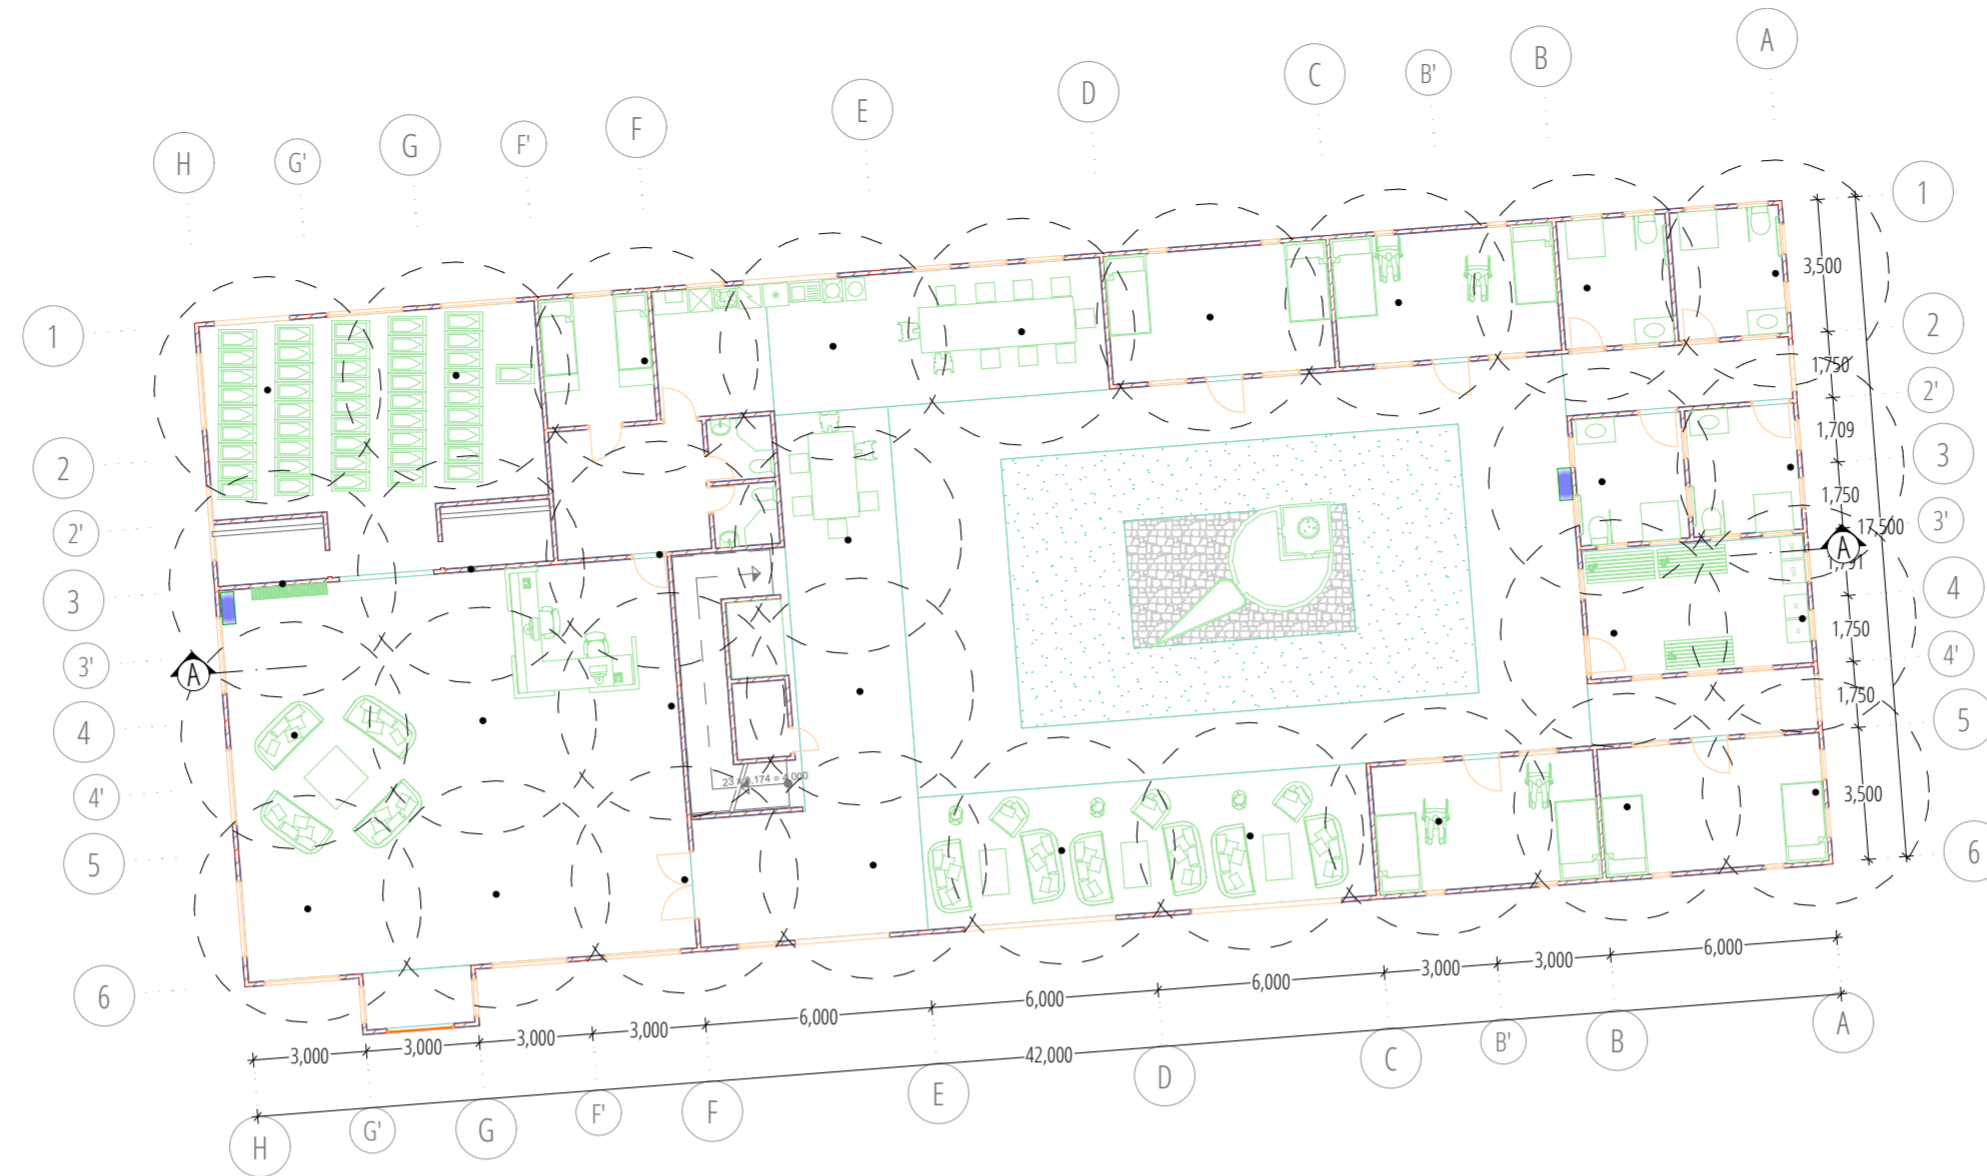

07-06
-

GF NATURAL VENTILATION PLAN
1:200

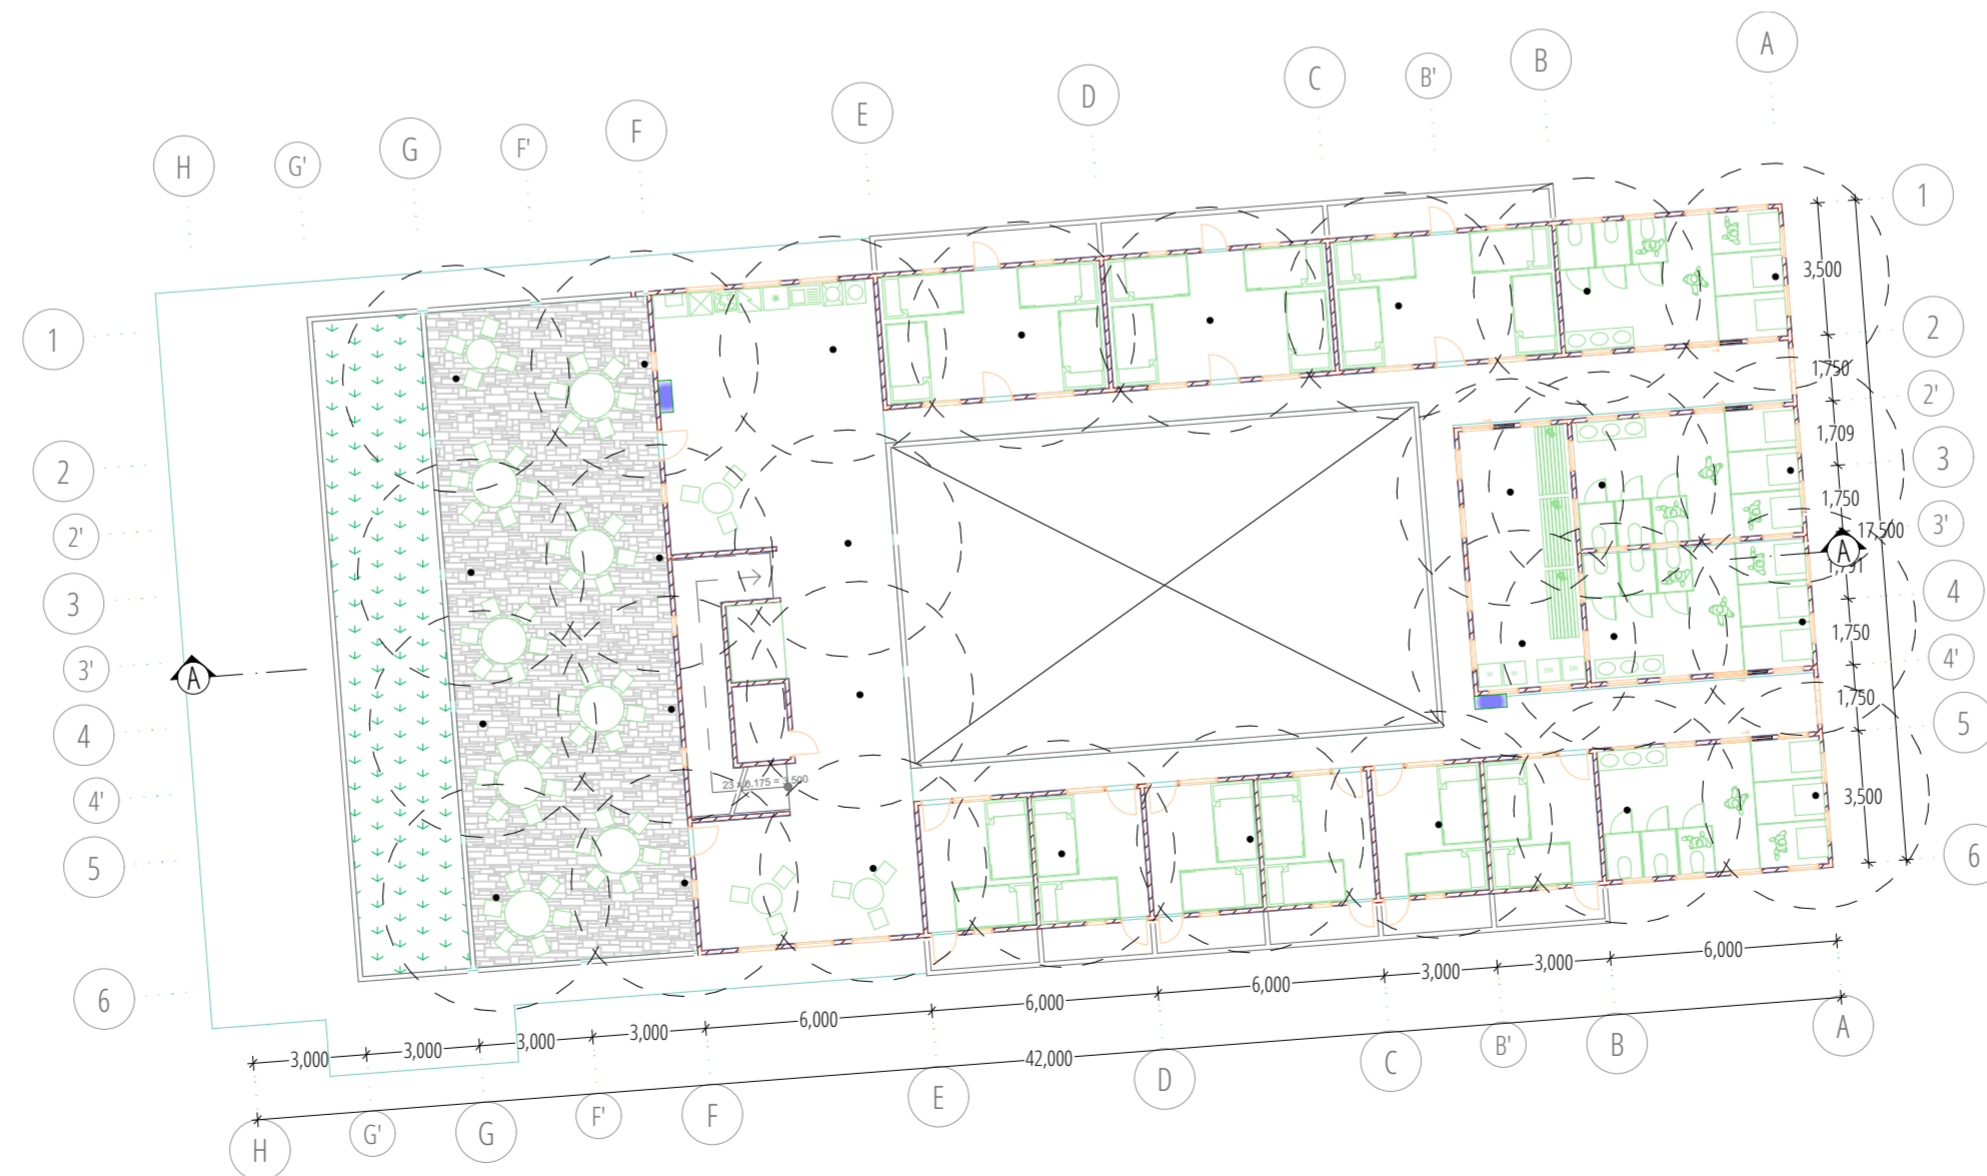

07-06
-

1ST FLOOR NATURAL VENTILATION PLAN
1:200

NOTES
THESE DRAWINGS ARE AN INSTRUMENT OF SERVICE AND ARE THE PROPERTY OF THE CREATOR. ANY USE OF THE DRAWINGS WITHOUT THE PRIOR EXPRESS WRITTEN PERMISSION OF THE CREATOR IS A VIOLATION OF COPYRIGHT AND WILL BE LIABLE TO PROSECUTION. DO NOT SCALE FROM DRAWINGS. USE ONLY GIVEN DIMENSIONS. ALL DIMENSIONS ARE IN MILLIMETERS UNLESS OTHERWISE NOTED.

△		
△		
△		
△		

REV	DATE	REVISION STATUS	STATUS
-----	------	-----------------	--------

PROJECT		<i>Sadawati</i>
HOTEL BACKPACKER DI PASAR LEMPUNGAN YOGYAKARTA		
INSTITUTION		DEPARTMENT OF ARCHITECTURE
DEPARTMENT OF ARCHITECTURE FACULTY OF CIVIL AND ENGINEERING PLANNING, UII.		
NAME		STUDENT IDENTITY
FARA HAJAR P ARCHITECT		14512041

DRAWING TITLE	NATURAL VENTILATION PLAN
---------------	--------------------------

DRAWING BY	FARA HAJAR P
------------	--------------


STATUS	PRELIMINARY DESIGN
--------	--------------------

SKALA	1:200
-------	-------

DRAWING NO.	07-06
-------------	-------


	NAME	SIGN	DATE
DRAWN BY	FARA HAJAR P		
CHECKED BY			
APPROVED BY			

	PAGE	17
	TOTAL PAGE	29

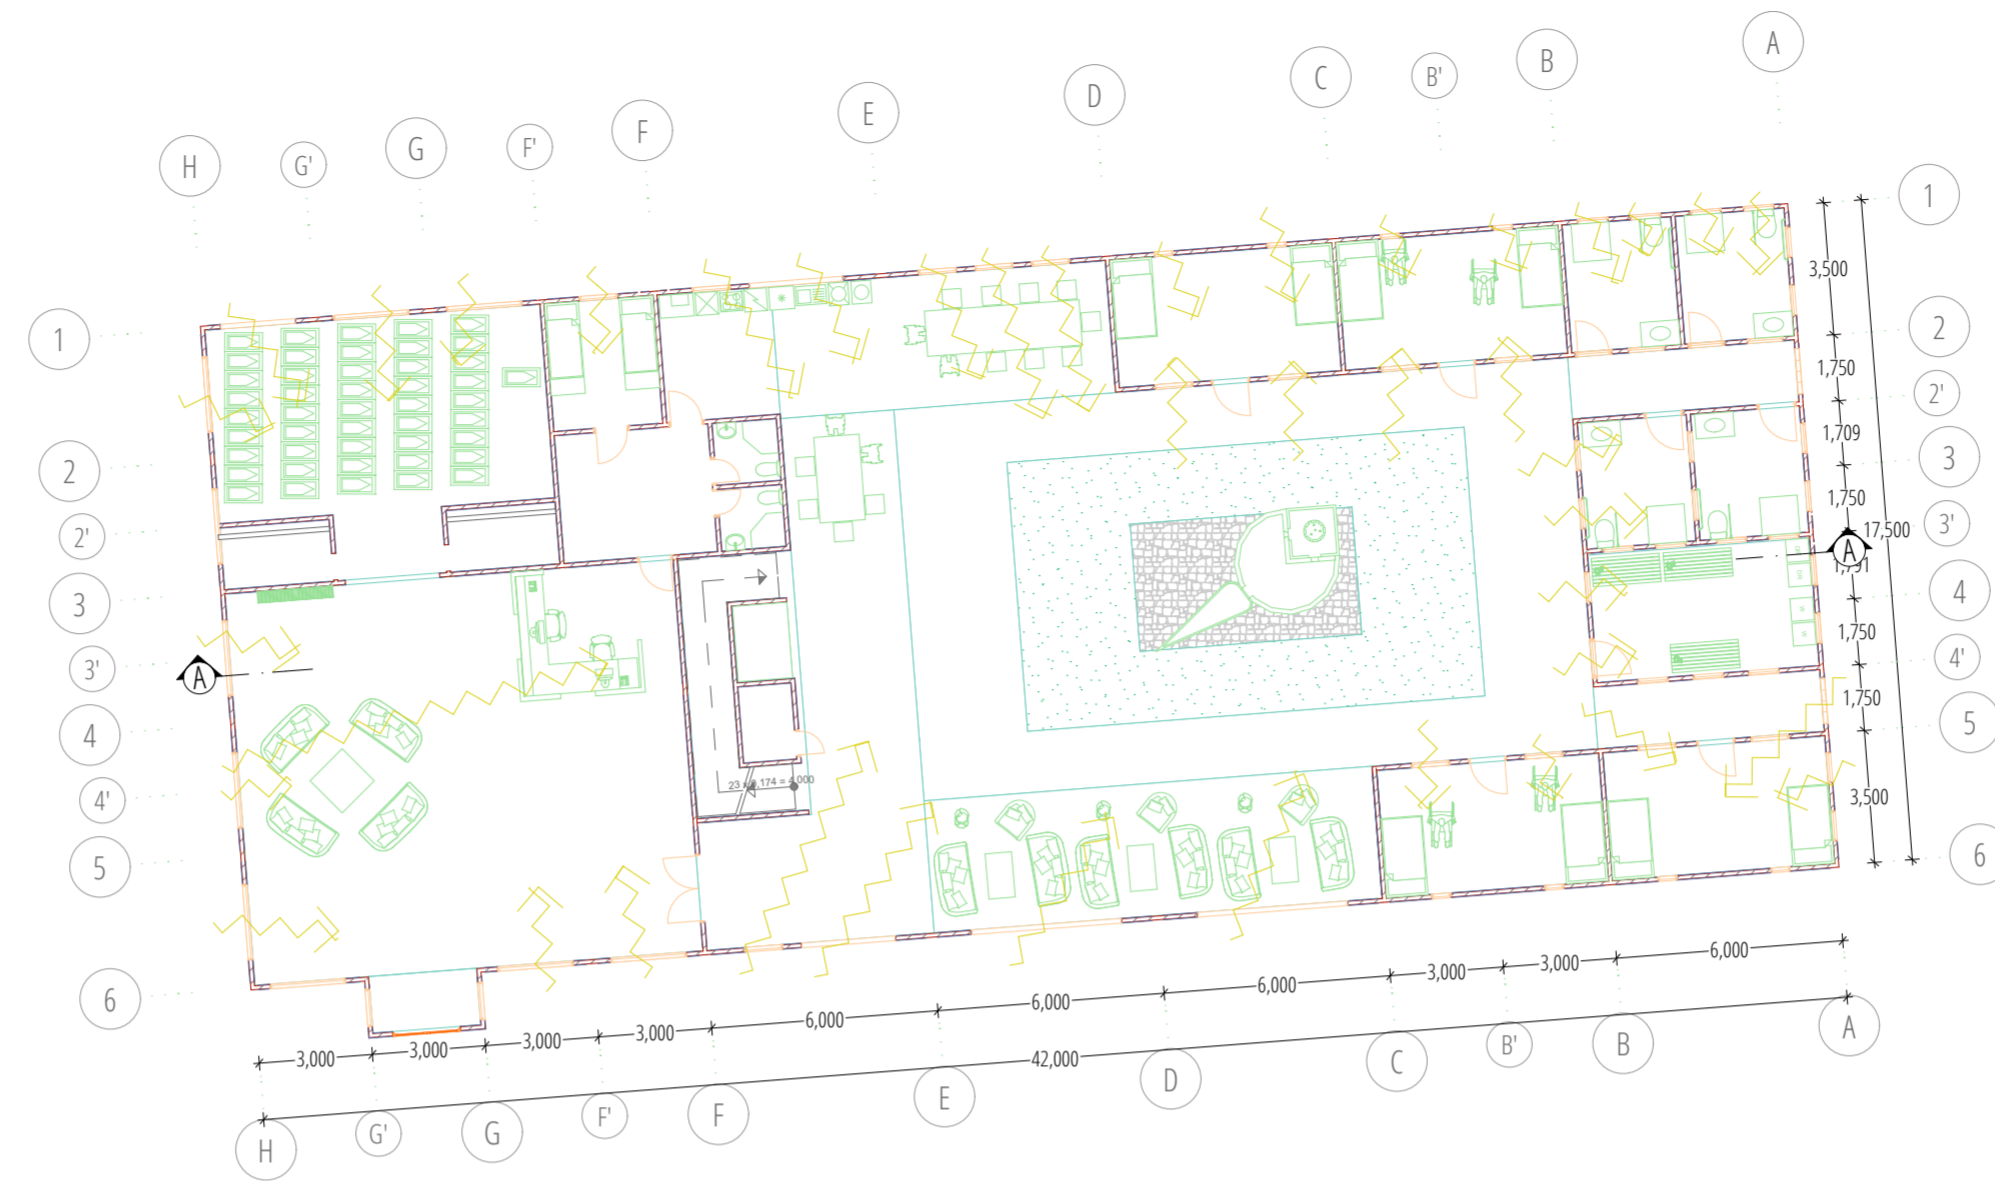

07-07
-

GF NATURAL LIGHTING PLAN
1:200

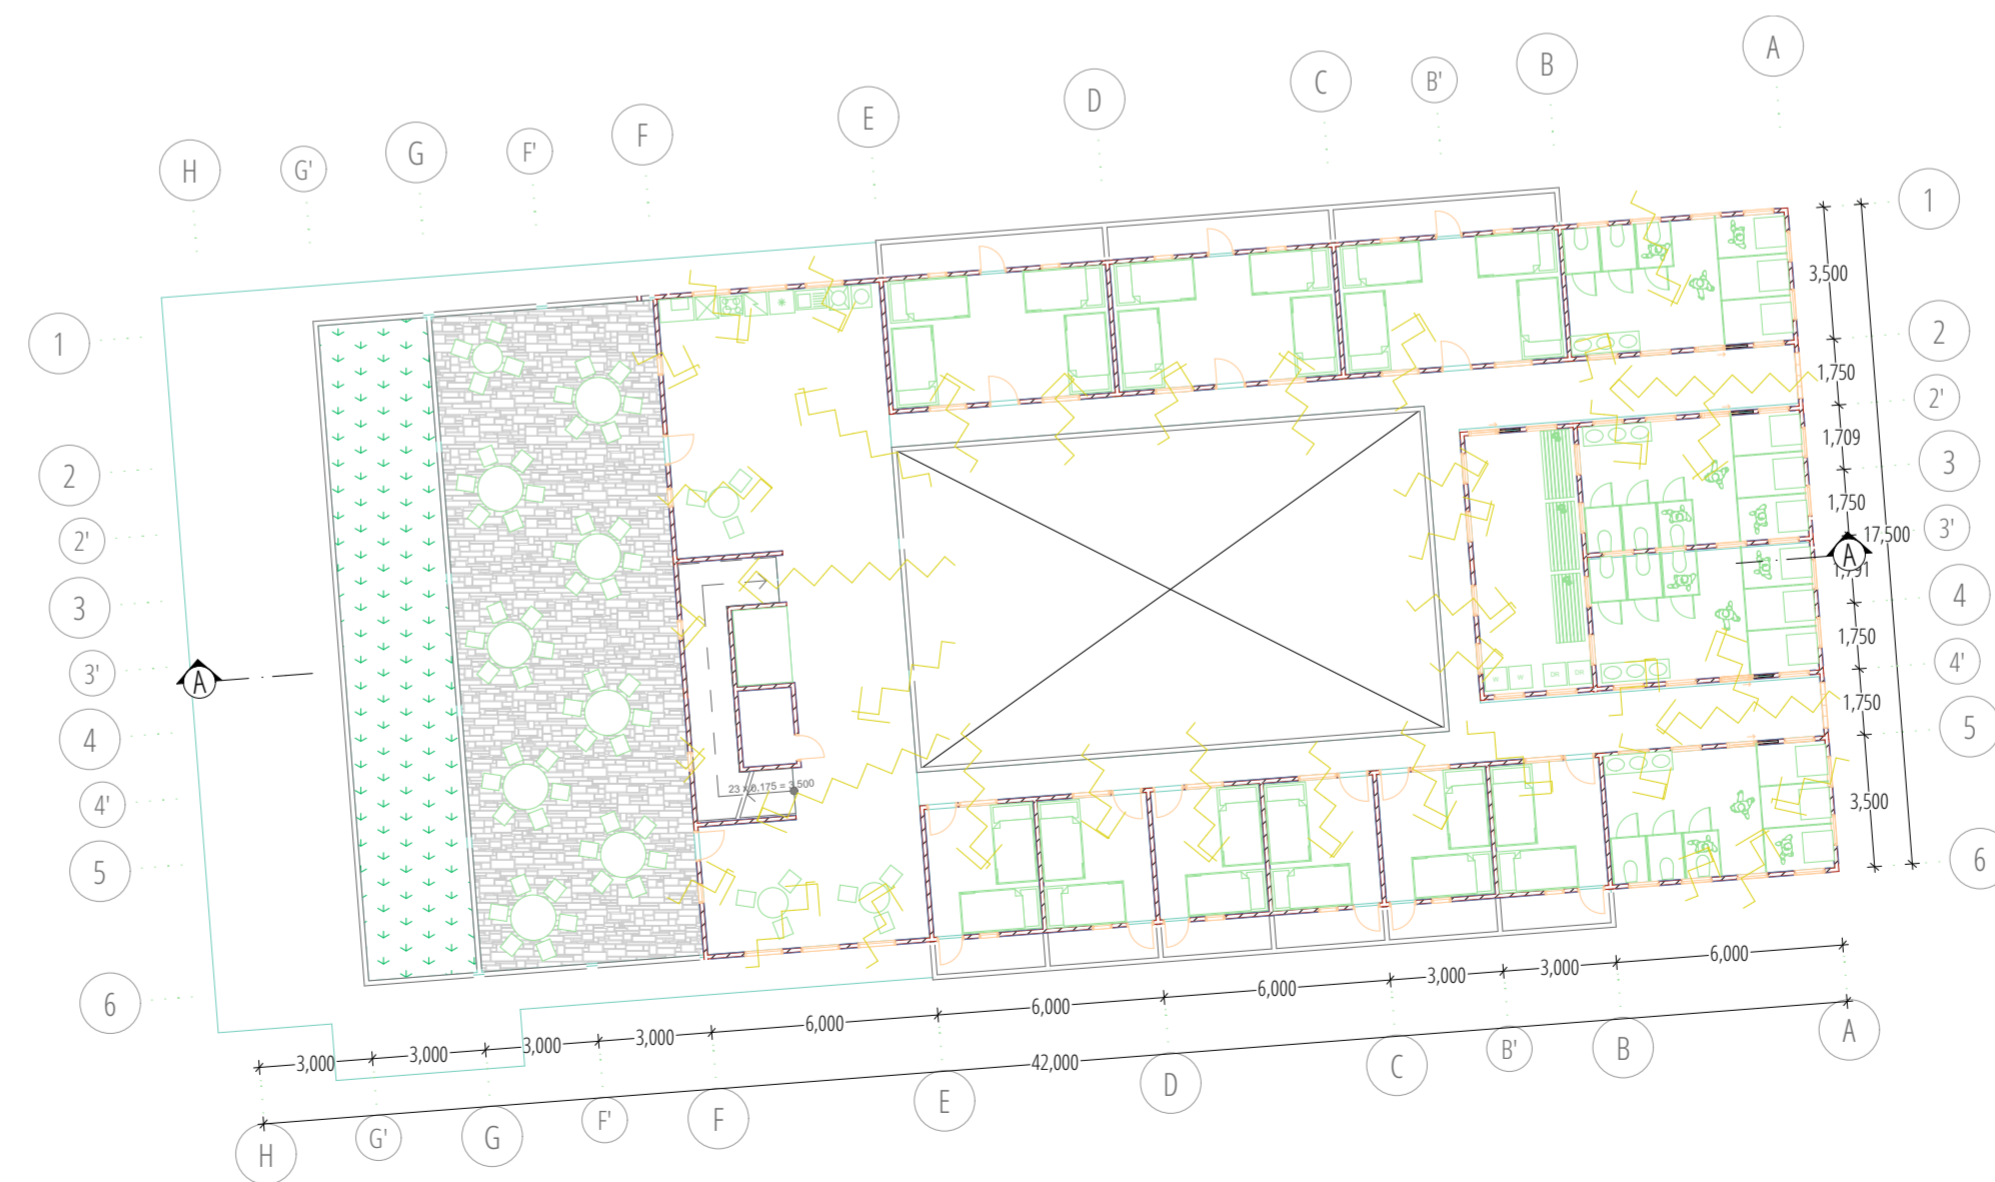

07-07
-

1ST FLOOR NATURAL LIGHTING PLAN
1:200

NOTES
THESE DRAWINGS ARE AN INSTRUMENT OF SERVICE AND ARE THE PROPERTY OF THE CREATOR. ANY USE OF THE DRAWINGS WITHOUT THE PRIOR EXPRESS WRITTEN PERMISSION OF THE CREATOR IS A VIOLATION OF COPYRIGHT AND WILL BE LIABLE TO PROSECUTION. DO NOT SCALE FROM DRAWINGS. USE ONLY GIVEN DIMENSIONS. ALL DIMENSIONS ARE IN MILLIMETERS UNLESS OTHERWISE NOTED.

△		
△		
△		

REV	DATE	REVISION STATUS	STATUS

PROJECT		<i>Sakomir</i>
HOTEL BACKPACKER DI PASAR LEMPUNGAN YOGYAKARTA		
INSTITUTION		DEPARTMENT OF ARCHITECTURE
DEPARTMENT OF ARCHITECTURE FACULTY OF CIVIL AND ENGINEERING PLANNING, UII.		
NAME		STUDENT IDENTITY
FARA HAJAR P ARCHITECT		14512041

DRAWING TITLE	
NATURAL LIGHTING PLAN	


DRAWING BY	
FARA HAJAR P	

STATUS	
PRELIMINARY DESIGN	

SKALA	
1:200	

DRAWING NO.	
07-07	

DRAWN BY	NAME	SIGN	DATE
CHECKED BY	FARA HAJAR P		
APPROVED BY			

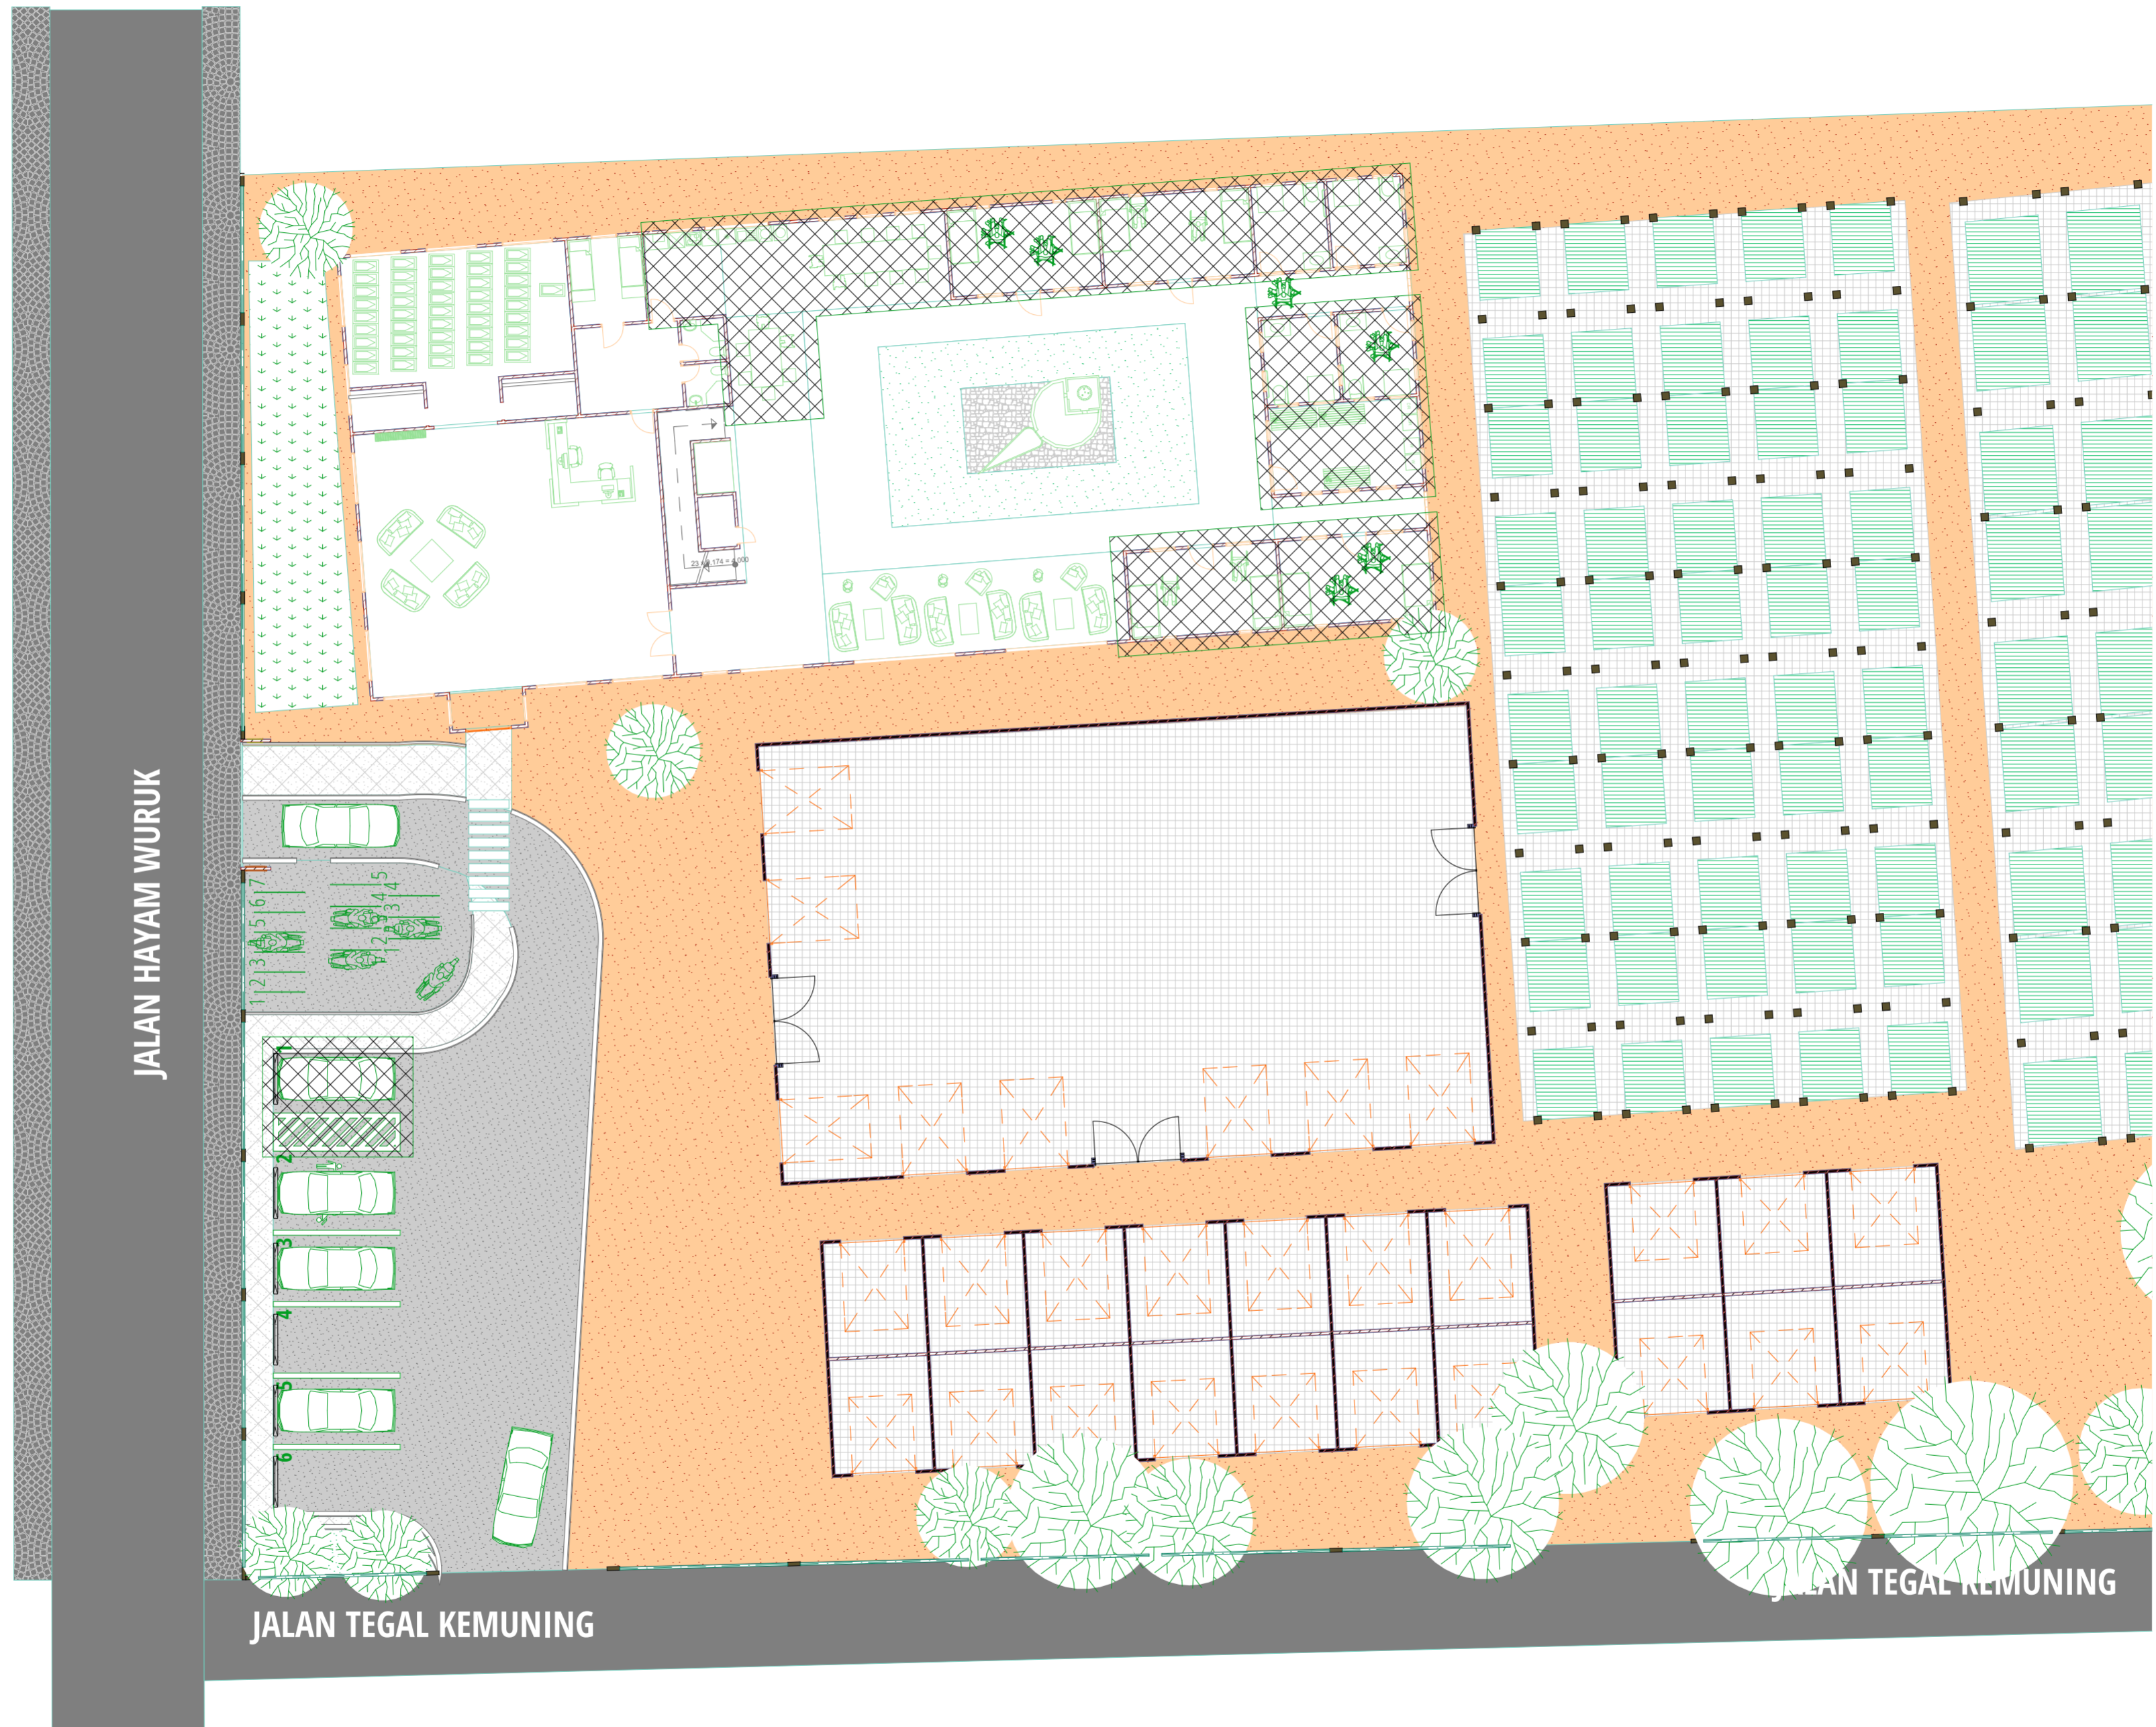

07-08
-

BARRIER FREE DESIGN PLAN
1:200

NOTES
THESE DRAWINGS ARE AN INSTRUMENT OF SERVICE AND ARE THE PROPERTY OF THE CREATOR. ANY USE OF THE DRAWINGS WITHOUT THE PRIOR EXPRESS WRITTEN PERMISSION OF THE CREATOR IS A VIOLATION OF COPYRIGHT AND WILL BE LIABLE TO PROSECUTION. DO NOT SCALE FROM DRAWINGS. USE ONLY GIVEN DIMENSIONS. ALL DIMENSIONS ARE IN MILLIMETERS UNLESS OTHERWISE NOTED.

△		
△		
△		
△		

REV	DATE	REVISION STATUS	STATUS

PROJECT		
HOTEL BACKPACKER DI PASAR LEMPUNYANGAN YOGYAKARTA		
INSTITUTION		
DEPARTMENT OF ARCHITECTURE FACULTY OF CIVIL AND ENGINEERING PLANNING, UII.		
NAME		STUDENT IDENTITY
FARA HAJAR P ARCHITECT		14512041

DRAWING TITLE
BARRIER FREE DESIGN PLAN


DRAWING BY
FARA HAJAR P

STATUS
PRELIMINARY DESIGN


SKALA
1:200

DRAWING NO.
07-08


	NAME	SIGN	DATE
DRAWN BY	FARA HAJAR P		
CHECKED BY			
APPROVED BY			

  N	PAGE	19
	TOTAL PAGE	29

08-01
- D1' SECTION DETAIL
1:50

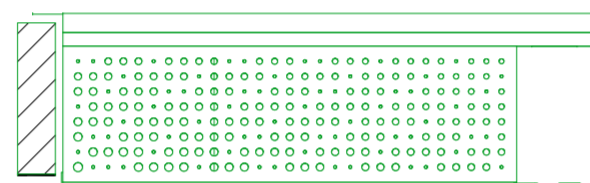


08-01
- D1' FRONT ELEVATION DETAIL
1:50

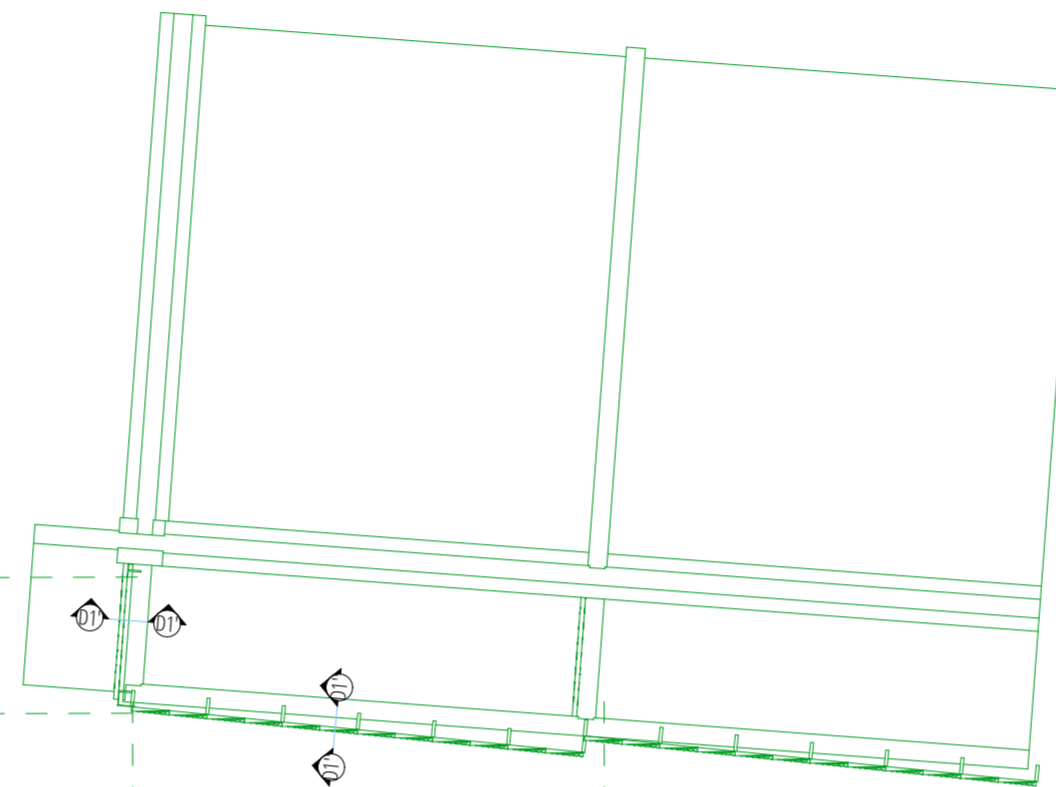


08-01
- BALCON 2NDARY SKIN PLAN DETAIL
1:50

08-01
- D1" SECTION DETAIL
1:50

08-01
-

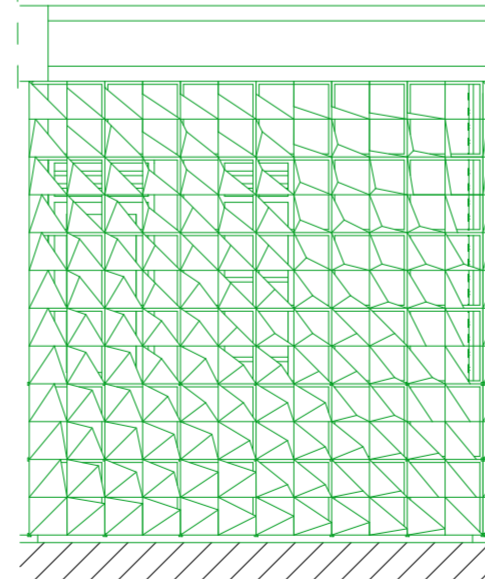

08-01
- D1" FRONT ELEVATION DETAIL
1:50

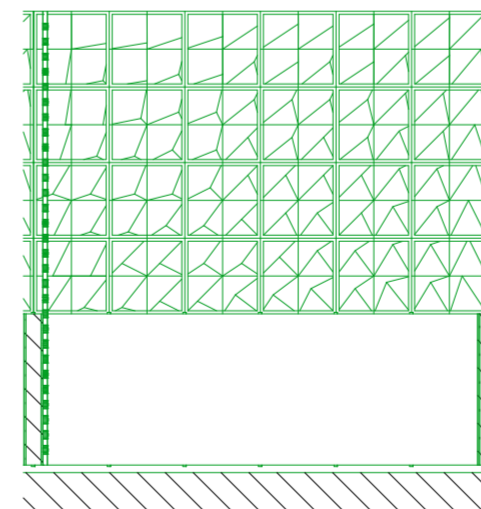

08-01
- D1" BACK ELEVATION DETAIL
1:50

NOTES
THESE DRAWINGS ARE AN INSTRUMENT OF SERVICE AND ARE THE PROPERTY OF THE CREATOR. ANY USE OF THE DRAWINGS WITHOUT THE PRIOR EXPRESS WRITTEN PERMISSION OF THE CREATOR IS A VIOLATION OF COPYRIGHT AND WILL BE LIABLE TO PROSECUTION. DO NOT SCALE FROM DRAWINGS. USE ONLY GIVEN DIMENSIONS. ALL DIMENSIONS ARE IN MILLIMETERS UNLESS OTHERWISE NOTED.

△		
△		
△		
△		

REV	DATE	REVISION STATUS	STATUS

PROJECT		<i>Sakowic</i>
HOTEL BACKPACKER DI PASAR LEMPUNYANGAN YOGYAKARTA		
INSTITUTION		DEPARTMENT OF ARCHITECTURE
DEPARTMENT OF ARCHITECTURE FACULTY OF CIVIL AND ENGINEERING PLANNING, UII.		
NAME	STUDENT IDENTITY	
FARA HAJAR P ARCHITECT	14512041	

DRAWING TITLE
BALCON SECONDARY SKIN DETAIL


DRAWING BY
FARA HAJAR P

STATUS
PRELIMINARY DESIGN

SKALA
1:50


DRAWING NO.
08-01

	NAME	SIGN	DATE
DRAWN BY	FARA HAJAR P		
CHECKED BY			
APPROVED BY			

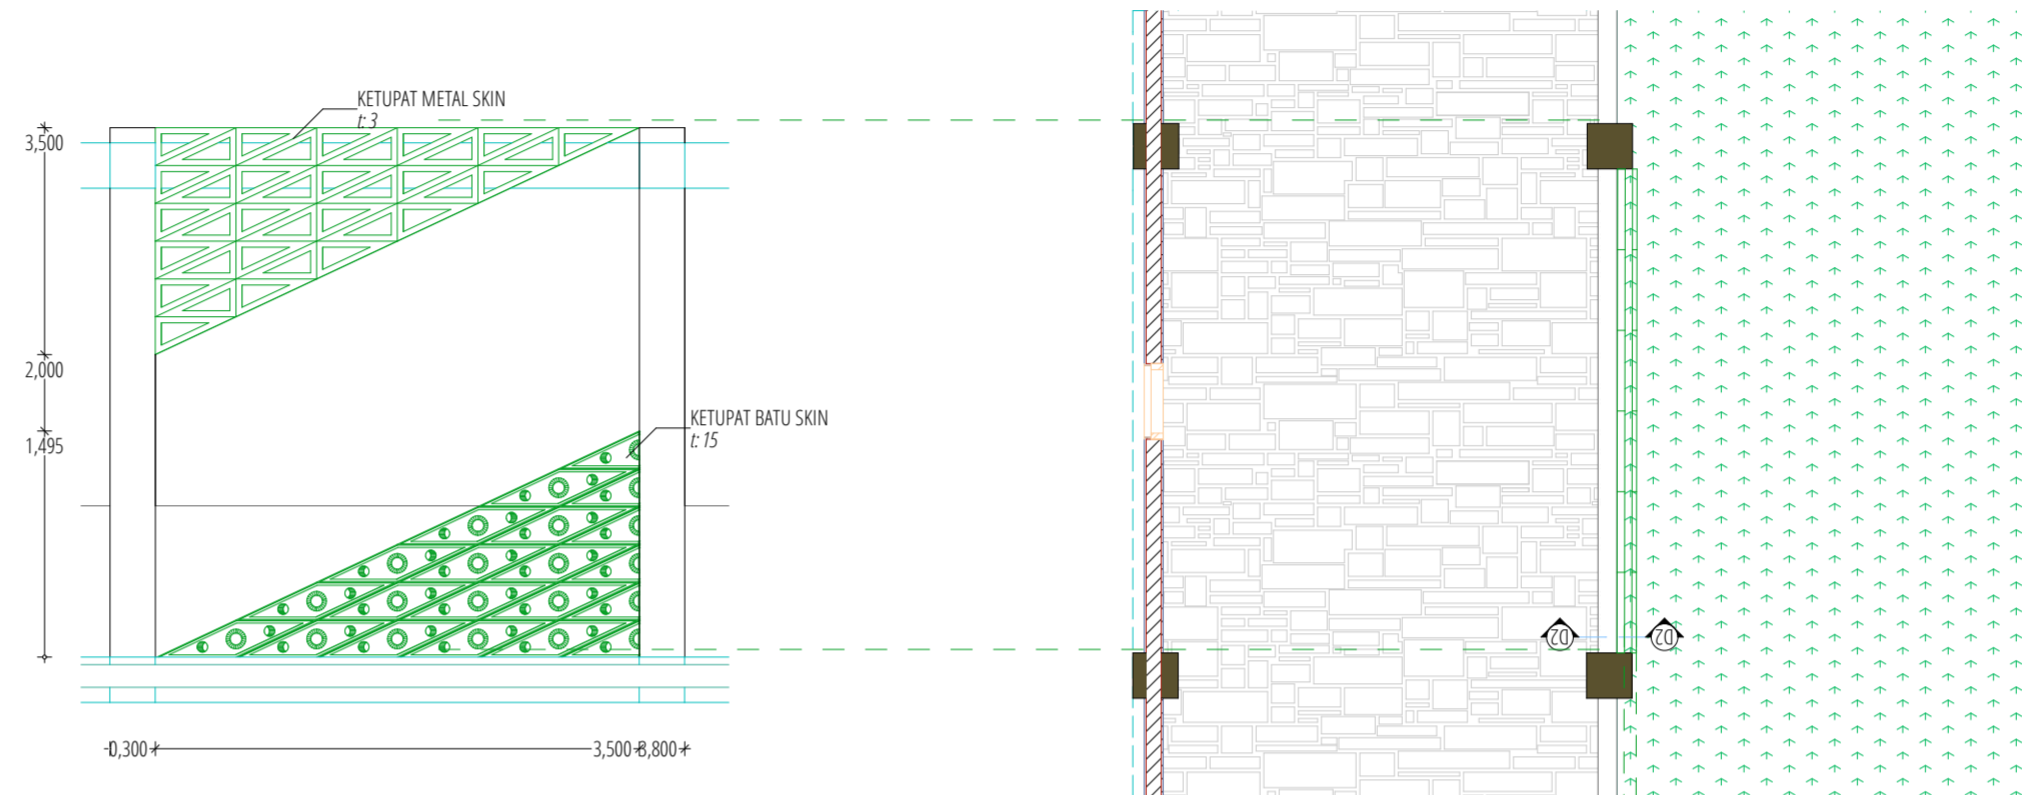


08-02 - FRONT ELEVATION DETAIL 1:50


08-02
DINDING 2NDARY SKIN PLAN DETAIL
1:50

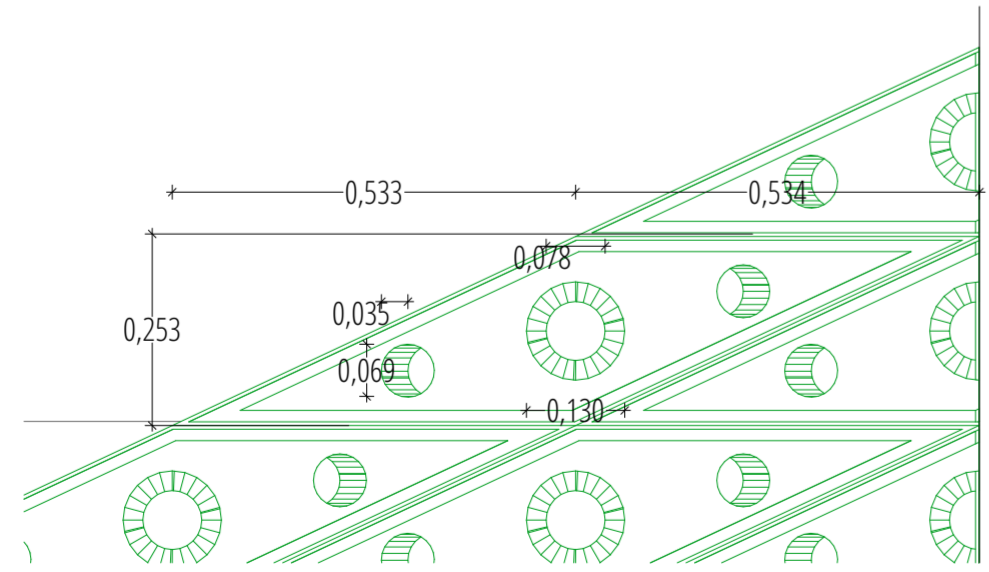

08-02 - KETUPAT DETAIL 1:10

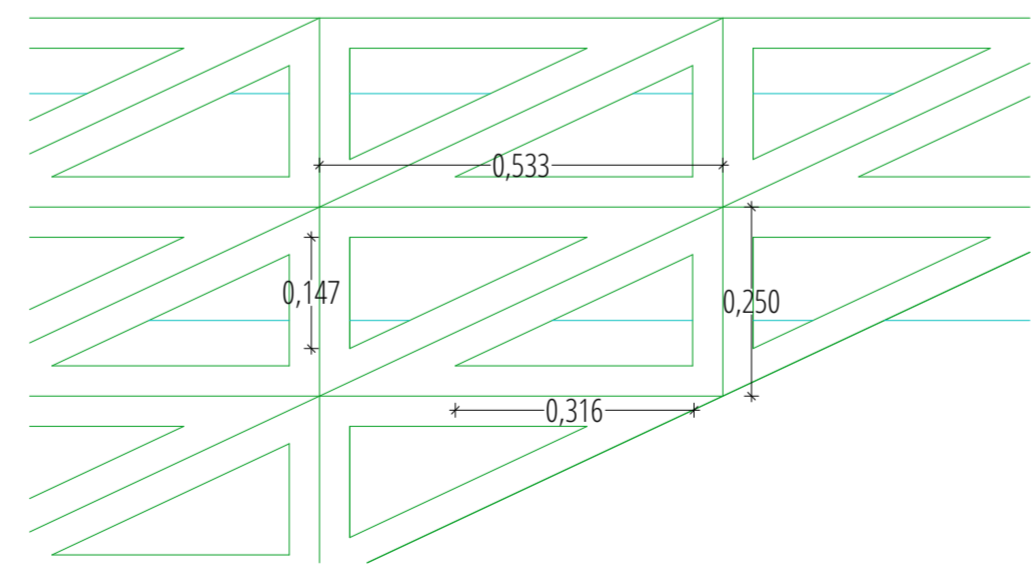

08-02 - KETUPAT DETAIL 1:10

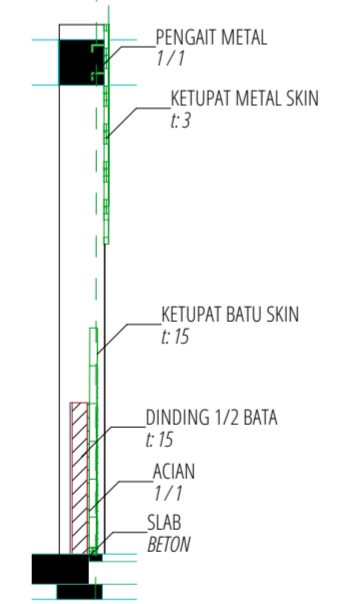



08-02 - D2 SECTION DETAIL 1:50

NOTES
THESE DRAWINGS ARE AN INSTRUMENT OF SERVICE AND ARE THE PROPERTY OF THE CREATOR. ANY USE OF THE DRAWINGS WITHOUT THE PRIOR EXPRESS WRITTEN PERMISSION OF THE CREATOR IS A VIOLATION OF COPYRIGHT AND WILL BE LIABLE TO PROSECUTION. DO NOT SCALE FROM DRAWINGS. USE ONLY GIVEN DIMENSIONS. ALL DIMENSIONS ARE IN MILLIMETERS UNLESS OTHERWISE NOTED.

△			
△			
△			
△			

REV	DATE	REVISION STATUS	STATUS

PROJECT		
HOTEL BACKPACKER DI PASAR LEMPUNYANGAN YOGYAKARTA		
INSTITUTION		
DEPARTMENT OF ARCHITECTURE FACULTY OF CIVIL AND ENGINEERING PLANNING, UII.		
NAME		STUDENT IDENTITY
FARA HAJAR P ARCHITECT		14512041

DRAWING TITLE
DINDING SECONDARY SKIN DETAIL


DRAWING BY
FARA HAJAR P

STATUS
PRELIMINARY DESIGN

SKALA
1:50,
1:10


DRAWING NO.
08-02

	NAME	SIGN	DATE
DRAWN BY	FARA HAJAR P		
CHECKED BY			
APPROVED BY			

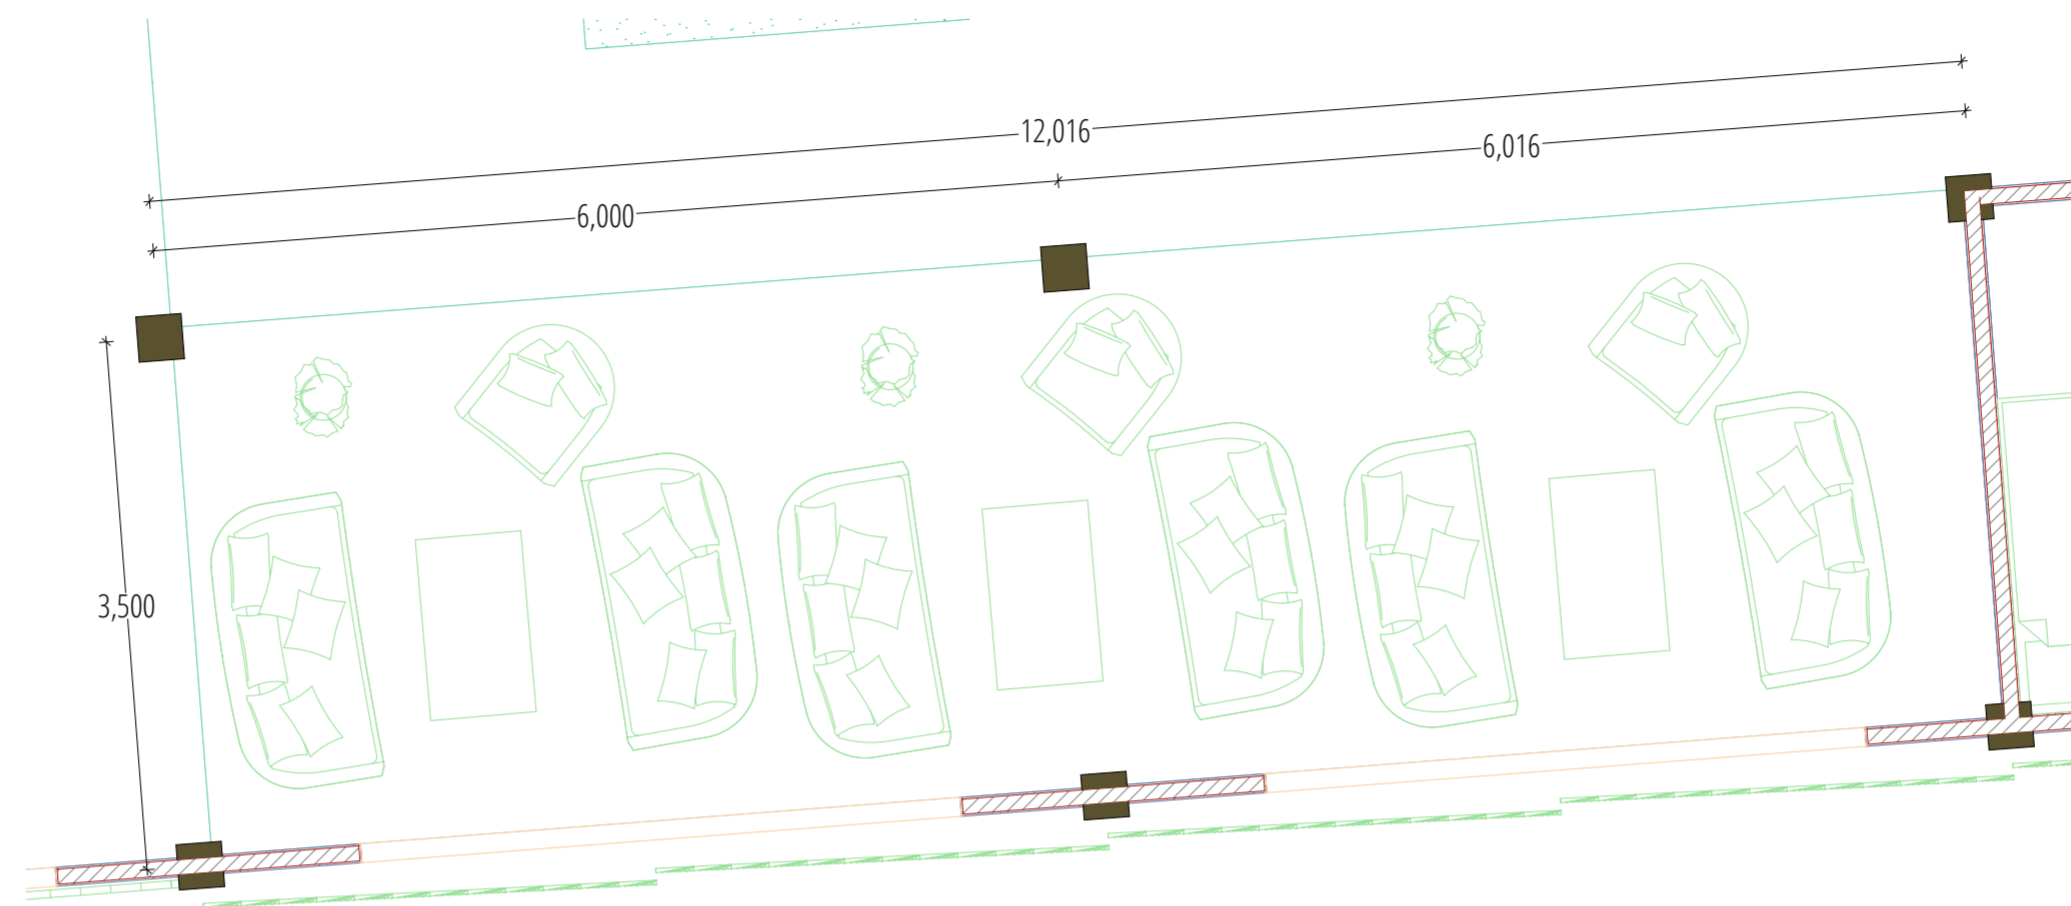

09
-

LIVING ROOM PLAN DETAIL
1:50

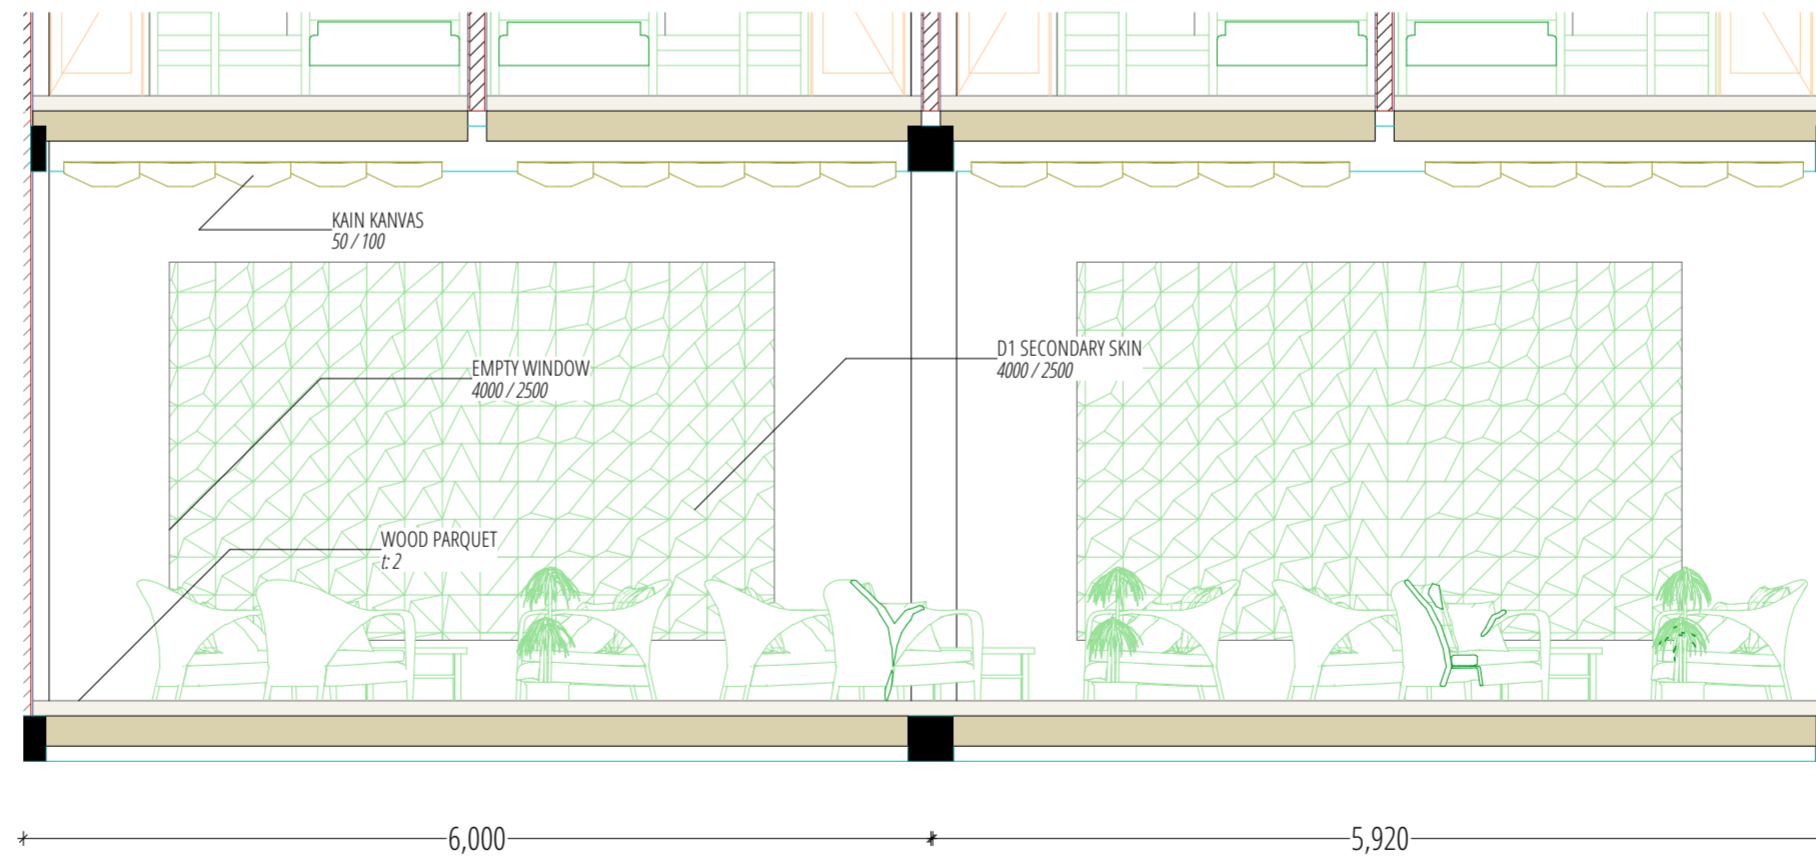

09
-

LIVING ROOM ELEVATION
1:50

NOTES

THESE DRAWINGS ARE AN INSTRUMENT OF SERVICE AND ARE THE PROPERTY OF THE CREATOR. ANY USE OF THE DRAWINGS WITHOUT THE PRIOR EXPRESS WRITTEN PERMISSION OF THE CREATOR IS A VIOLATION OF COPYRIGHT AND WILL BE LIABLE TO PROSECUTION. DO NOT SCALE FROM DRAWINGS. USE ONLY GIVEN DIMENSIONS. ALL DIMENSIONS ARE IN MILLIMETERS UNLESS OTHERWISE NOTED.

△		
△		
△		
△		

REV	DATE	REVISION STATUS	STATUS

PROJECT		<i>Sakawic</i>
HOTEL BACKPACKER DI PASAR LEMPUNYANGAN YOGYAKARTA		
INSTITUTION		DEPARTMENT OF ARCHITECTURE
DEPARTMENT OF ARCHITECTURE FACULTY OF CIVIL AND ENGINEERING PLANNING, UII.		
NAME		STUDENT IDENTITY
FARA HAJAR P ARCHITECT		14512041

DRAWING TITLE
LIVING ZONE DETAIL

DRAWING BY
FARA HAJAR P



STATUS
PRELIMINARY DESIGN

SKALA
1:50


DRAWING NO.
09

	NAME	SIGN	DATE
DRAWN BY	FARA HAJAR P		
CHECKED BY			
APPROVED BY			


10
-
ROOF BACK ELEVATION DETAIL
1:50

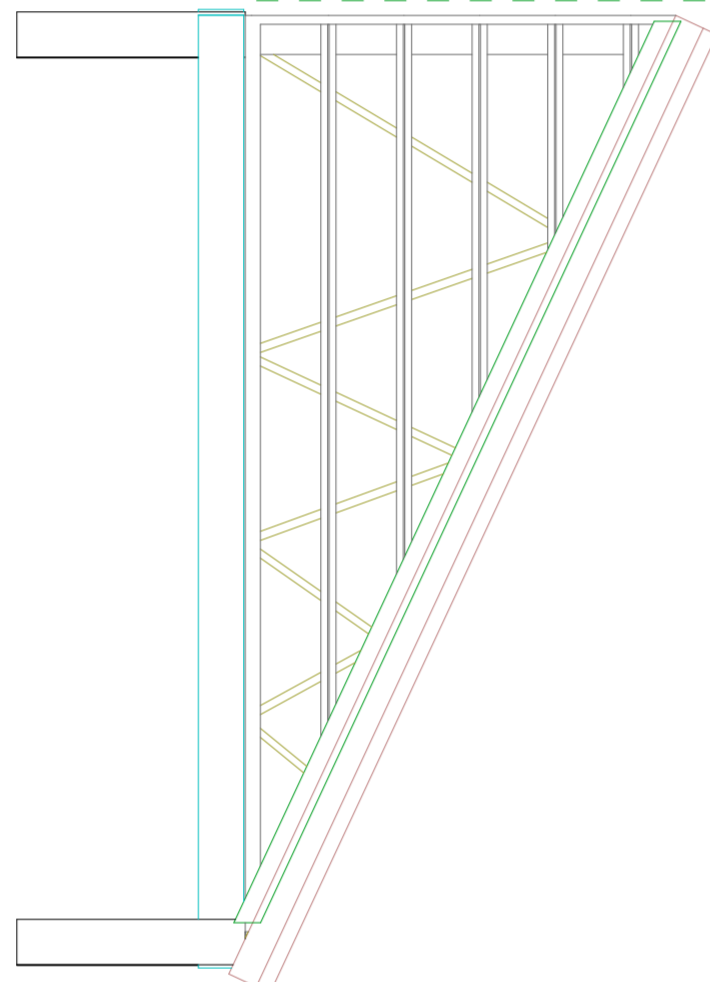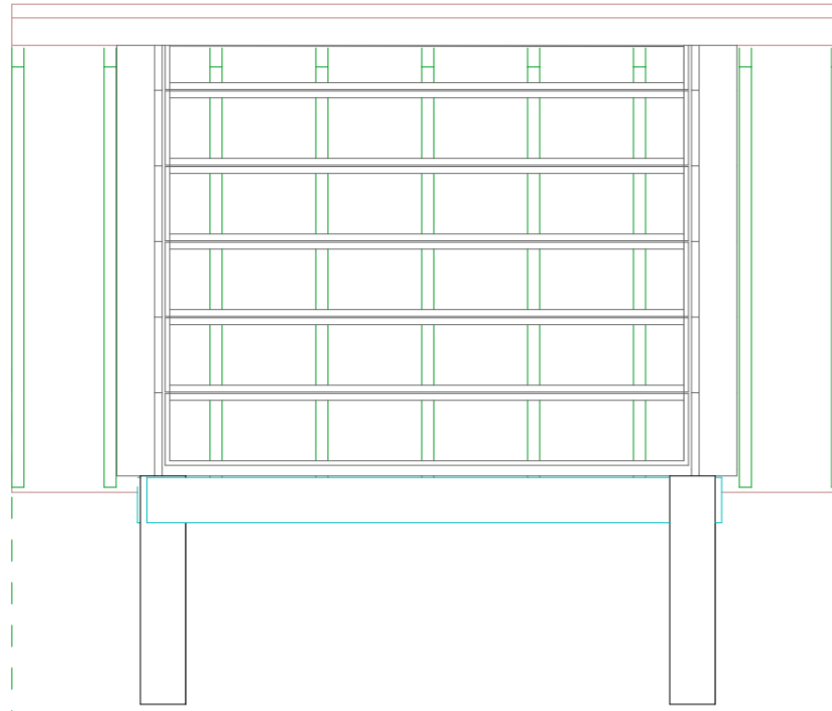


10
-
ROOF SIDE ELEVATION DETAIL
1:50

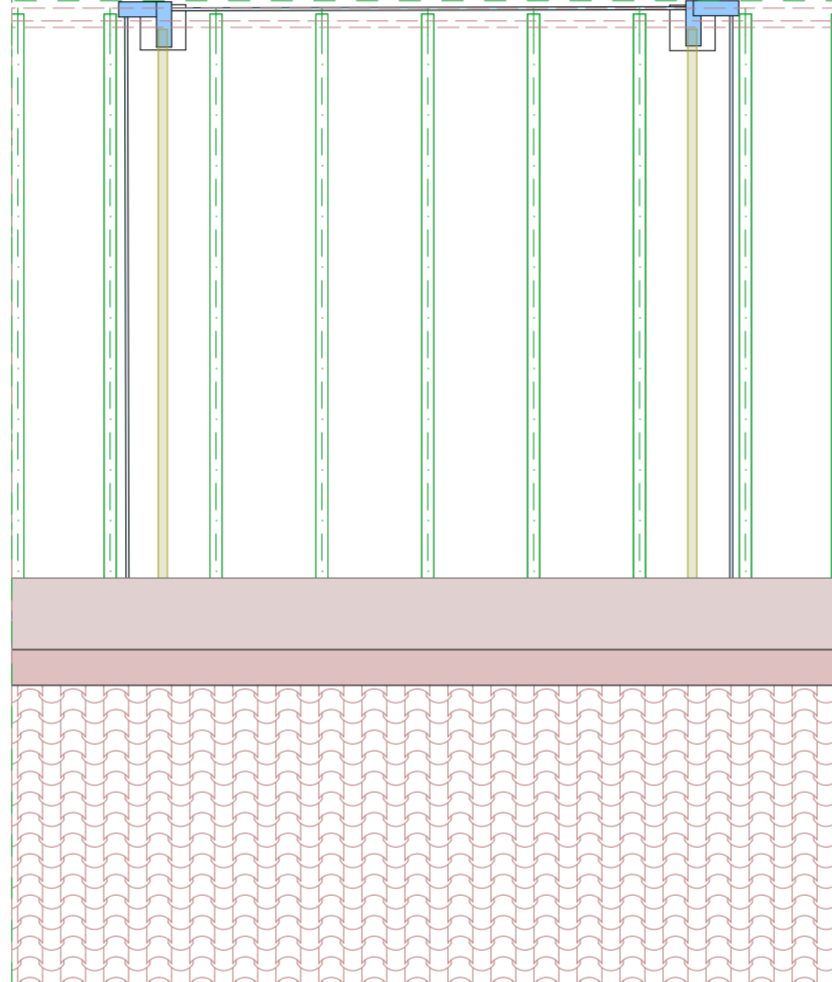

10
-
ROOF PLAN DETAIL
1:50

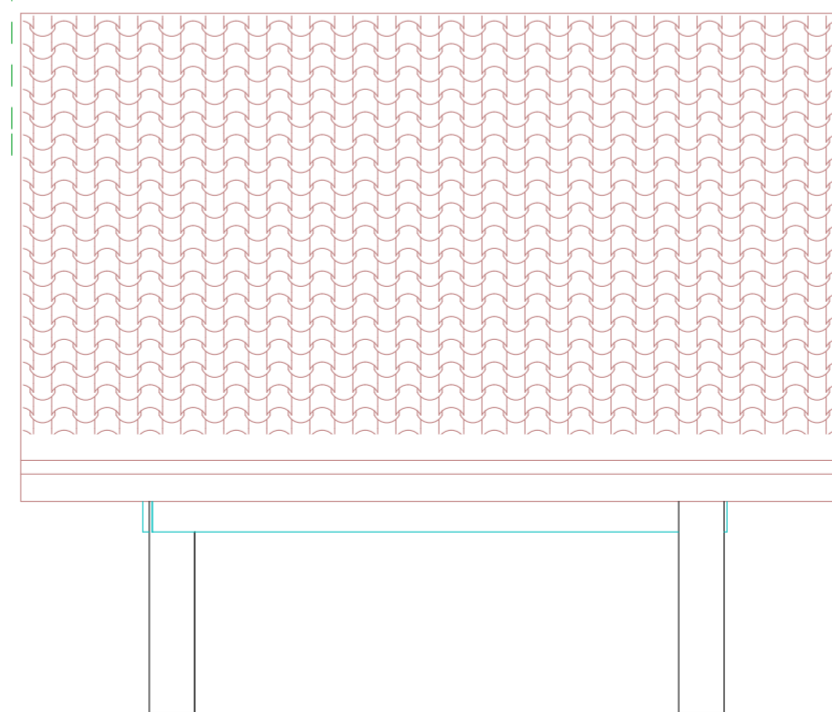

10
-
ROOF FRONT ELEVATION DETAIL
1:50

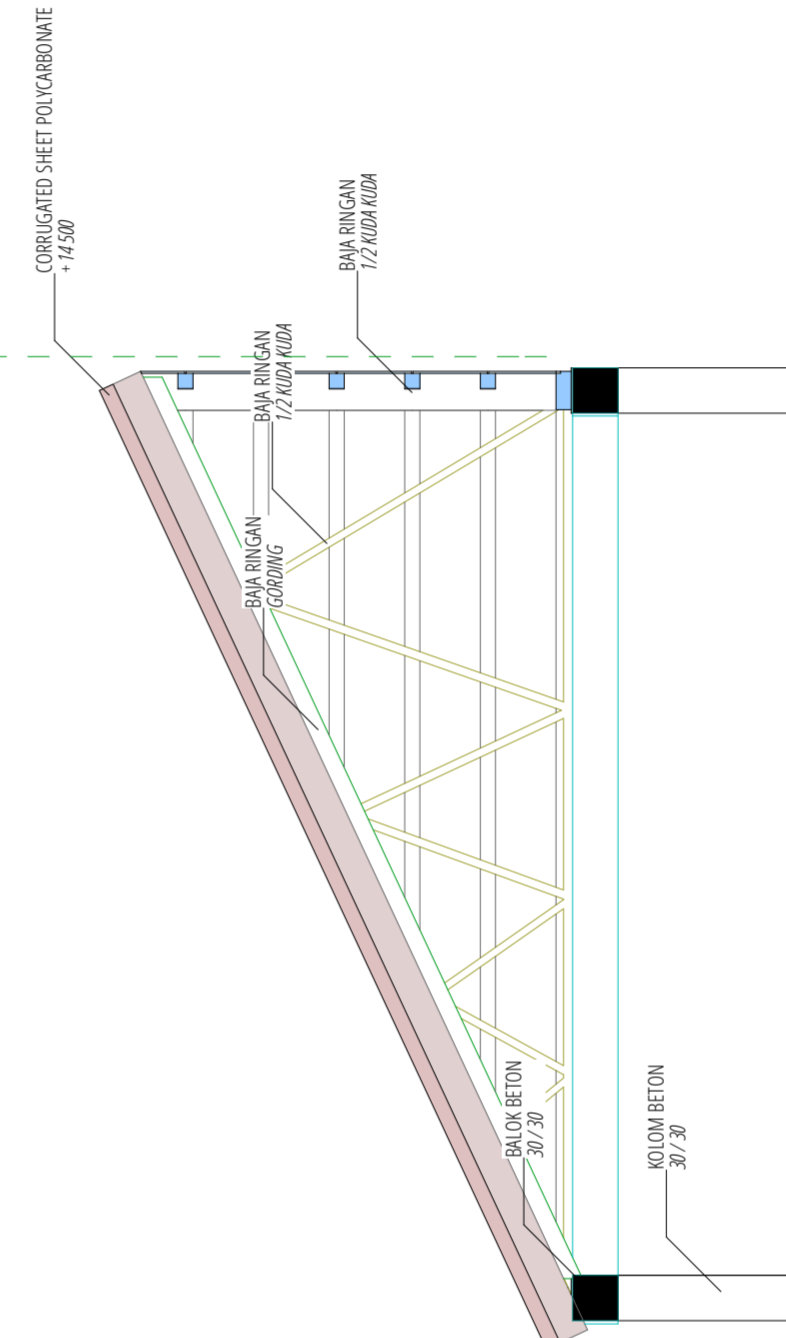

10
-
ROOF SECTION DETAIL
1:50

NOTES
THESE DRAWINGS ARE AN INSTRUMENT OF SERVICE AND ARE THE PROPERTY OF THE CREATOR. ANY USE OF THE DRAWINGS WITHOUT THE PRIOR EXPRESS WRITTEN PERMISSION OF THE CREATOR IS A VIOLATION OF COPYRIGHT AND WILL BE LIABLE TO PROSECUTION. DO NOT SCALE FROM DRAWINGS. USE ONLY GIVEN DIMENSIONS. ALL DIMENSIONS ARE IN MILLIMETERS UNLESS OTHERWISE NOTED.

△			
△			
△			
△			

REV	DATE	REVISION STATUS	STATUS

PROJECT		
HOTEL BACKPACKER DI PASAR LEMPUNYANGAN YOGYAKARTA		
INSTITUTION		
DEPARTMENT OF ARCHITECTURE FACULTY OF CIVIL AND ENGINEERING PLANNING, UII.		
NAME	STUDENT IDENTITY	
FARA HAJAR P ARCHITECT	14512041	

DRAWING TITLE

ROOF DETAIL

DRAWING BY

FARA HAJAR P

STATUS

PRELIMINARY DESIGN


SKALA


1:50

DRAWING NO.

10

	NAME	SIGN	DATE
DRAWN BY	FARA HAJAR P		
CHECKED BY			
APPROVED BY			

 	PAGE	23
	TOTAL PAGE	29

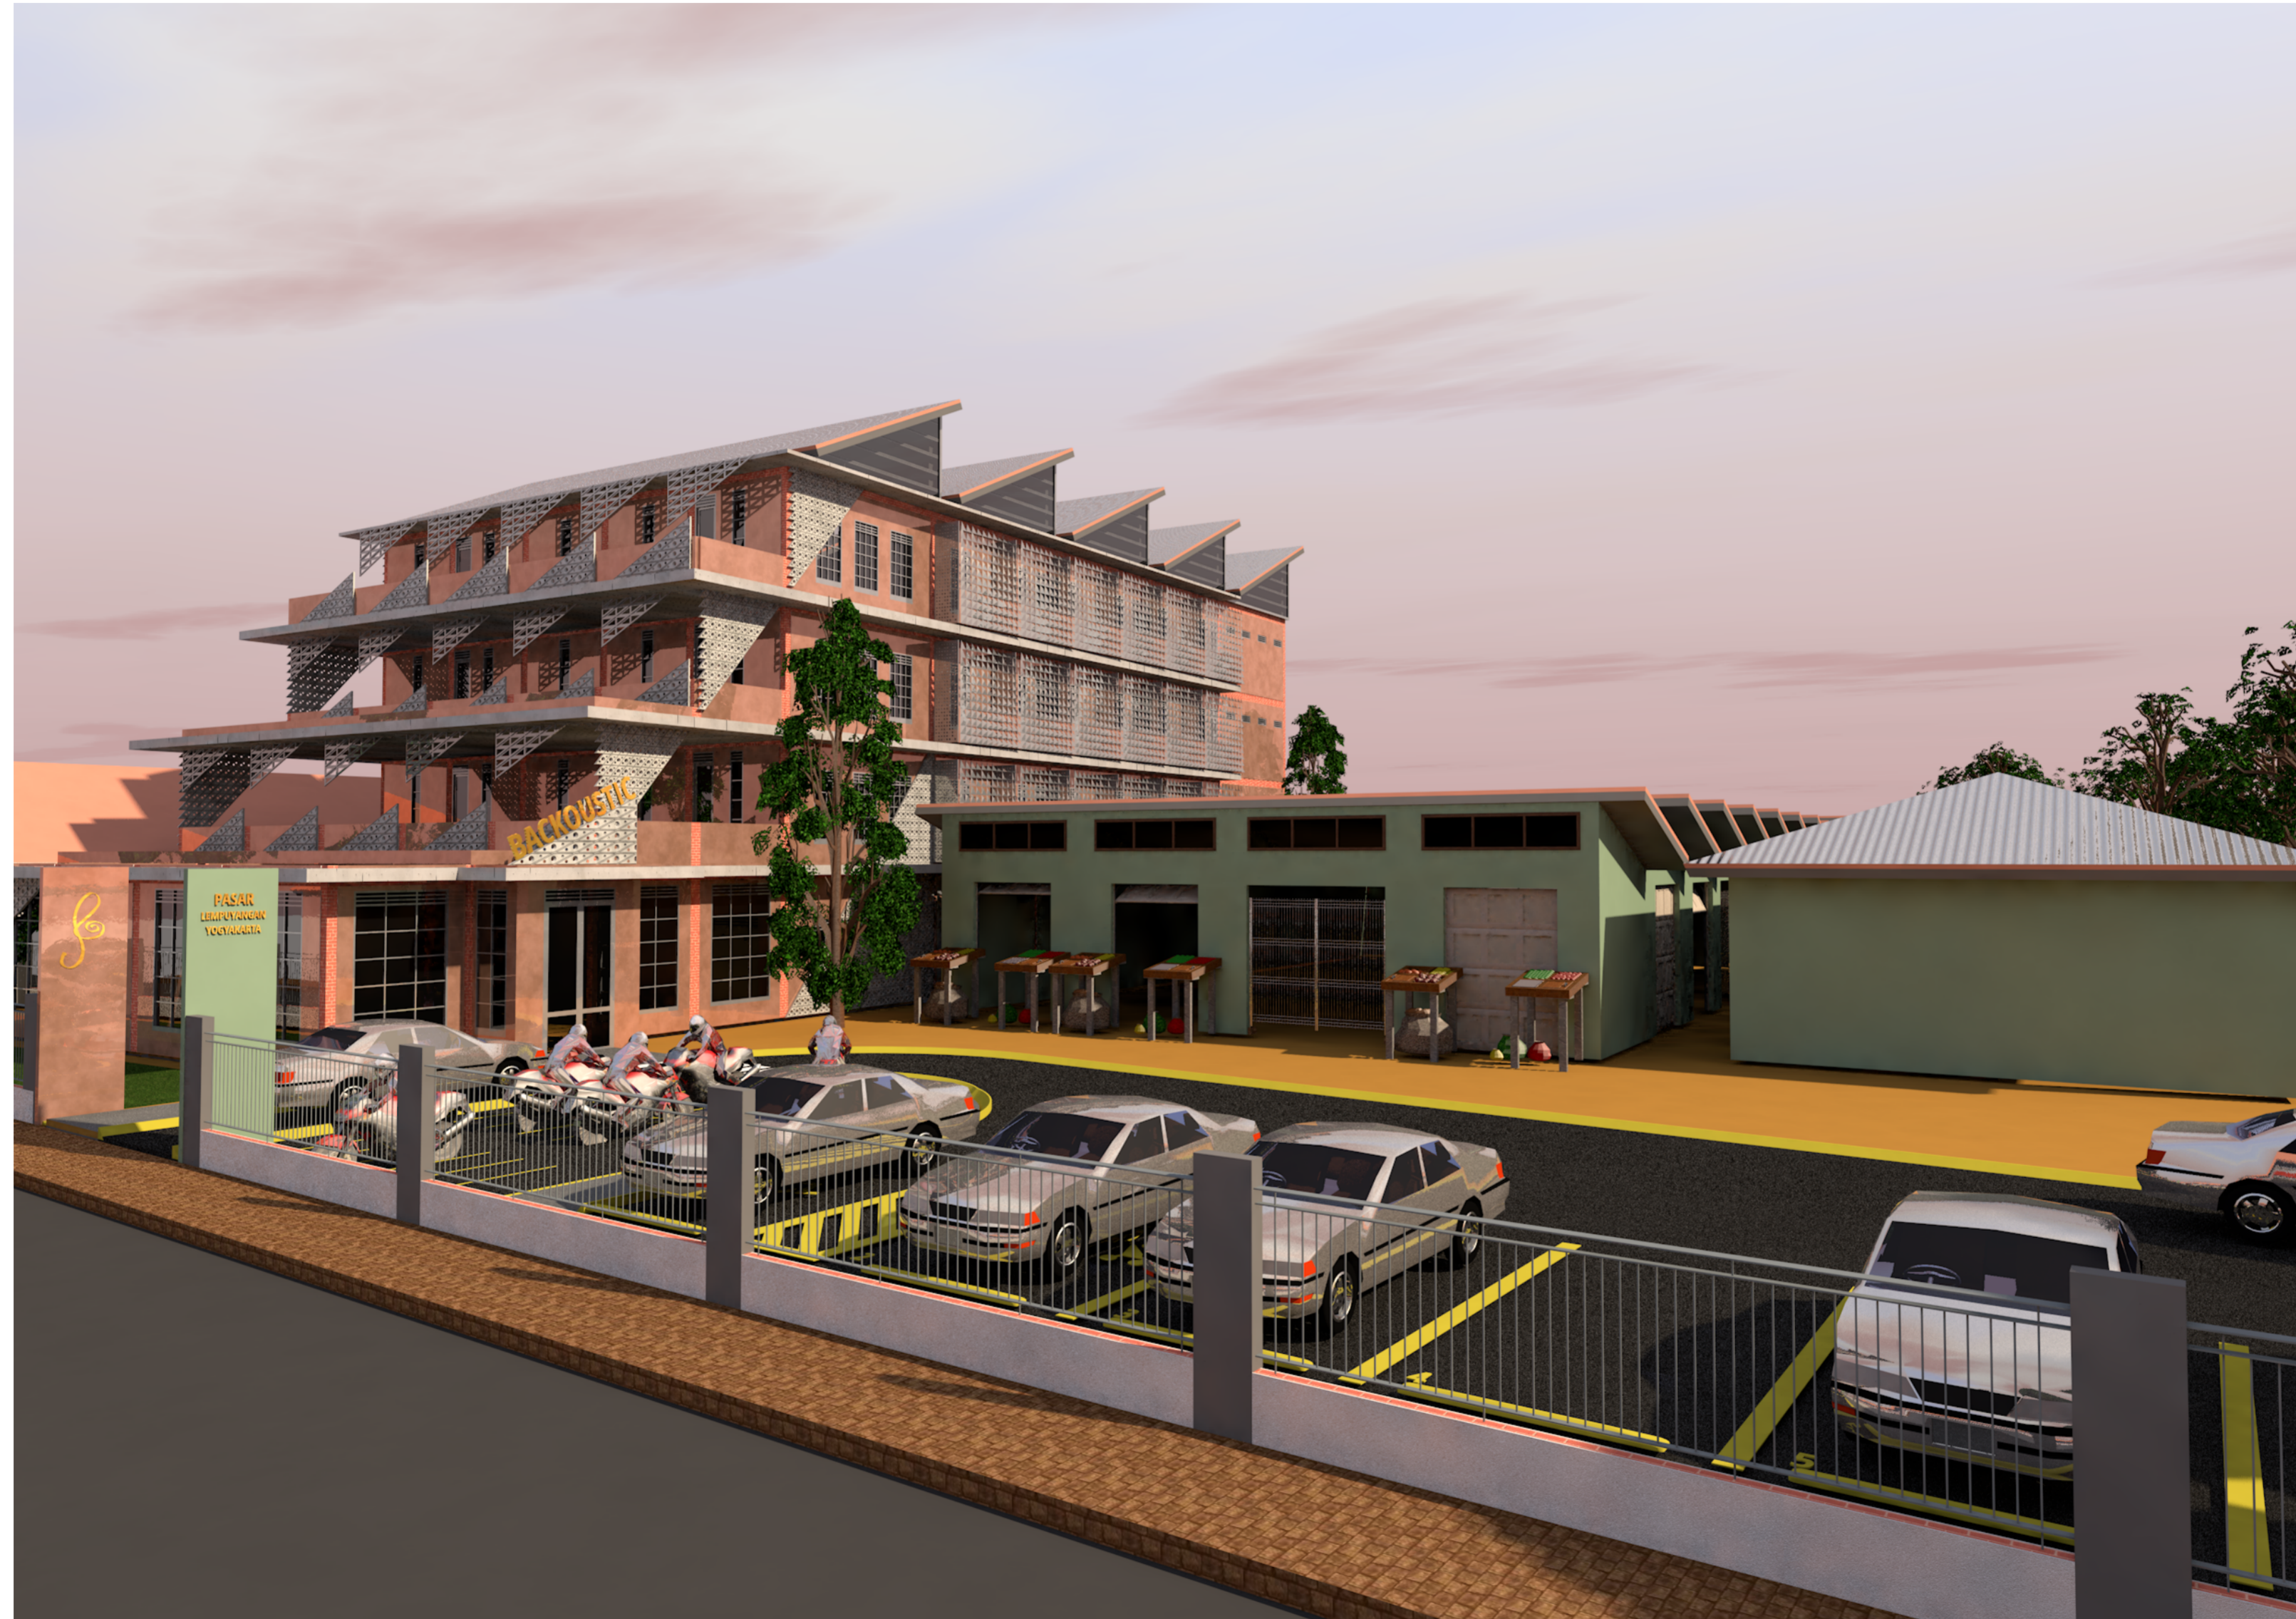

NOTES

THESE DRAWINGS ARE AN INSTRUMENT OF SERVICE AND ARE THE PROPERTY OF THE CREATOR. ANY USE OF THE DRAWINGS WITHOUT THE PRIOR EXPRESS WRITTEN PERMISSION OF THE CREATOR IS A VIOLATION OF COPYRIGHT AND WILL BE LIABLE TO PROSECUTION. DO NOT SCALE FROM DRAWINGS. USE ONLY GIVEN DIMENSIONS. ALL DIMENSIONS ARE IN MILLIMETERS UNLESS OTHERWISE NOTED.

- △
- △
- △
- △

REV	DATE	REVISION STATUS	STATUS

PROJECT		
HOTEL BACKPACKER DI PASAR LEMPUNGAN YOGYAKARTA		
INSTITUTION		
DEPARTMENT OF ARCHITECTURE FACULTY OF CIVIL AND ENGINEERING PLANNING, UII.		
NAME		STUDENT IDENTITY
FARA HAJAR P ARCHITECT		14512041

DRAWING TITLE
PERSPECTIVE EXTERIOR 1


DRAWING BY
FARA HAJAR P


STATUS
PRELIMINARY DESIGN

SKALA

DRAWING NO.

	NAME	SIGN	DATE
DRAWN BY	FARA HAJAR P		
CHECKED BY			
APPROVED BY			

 

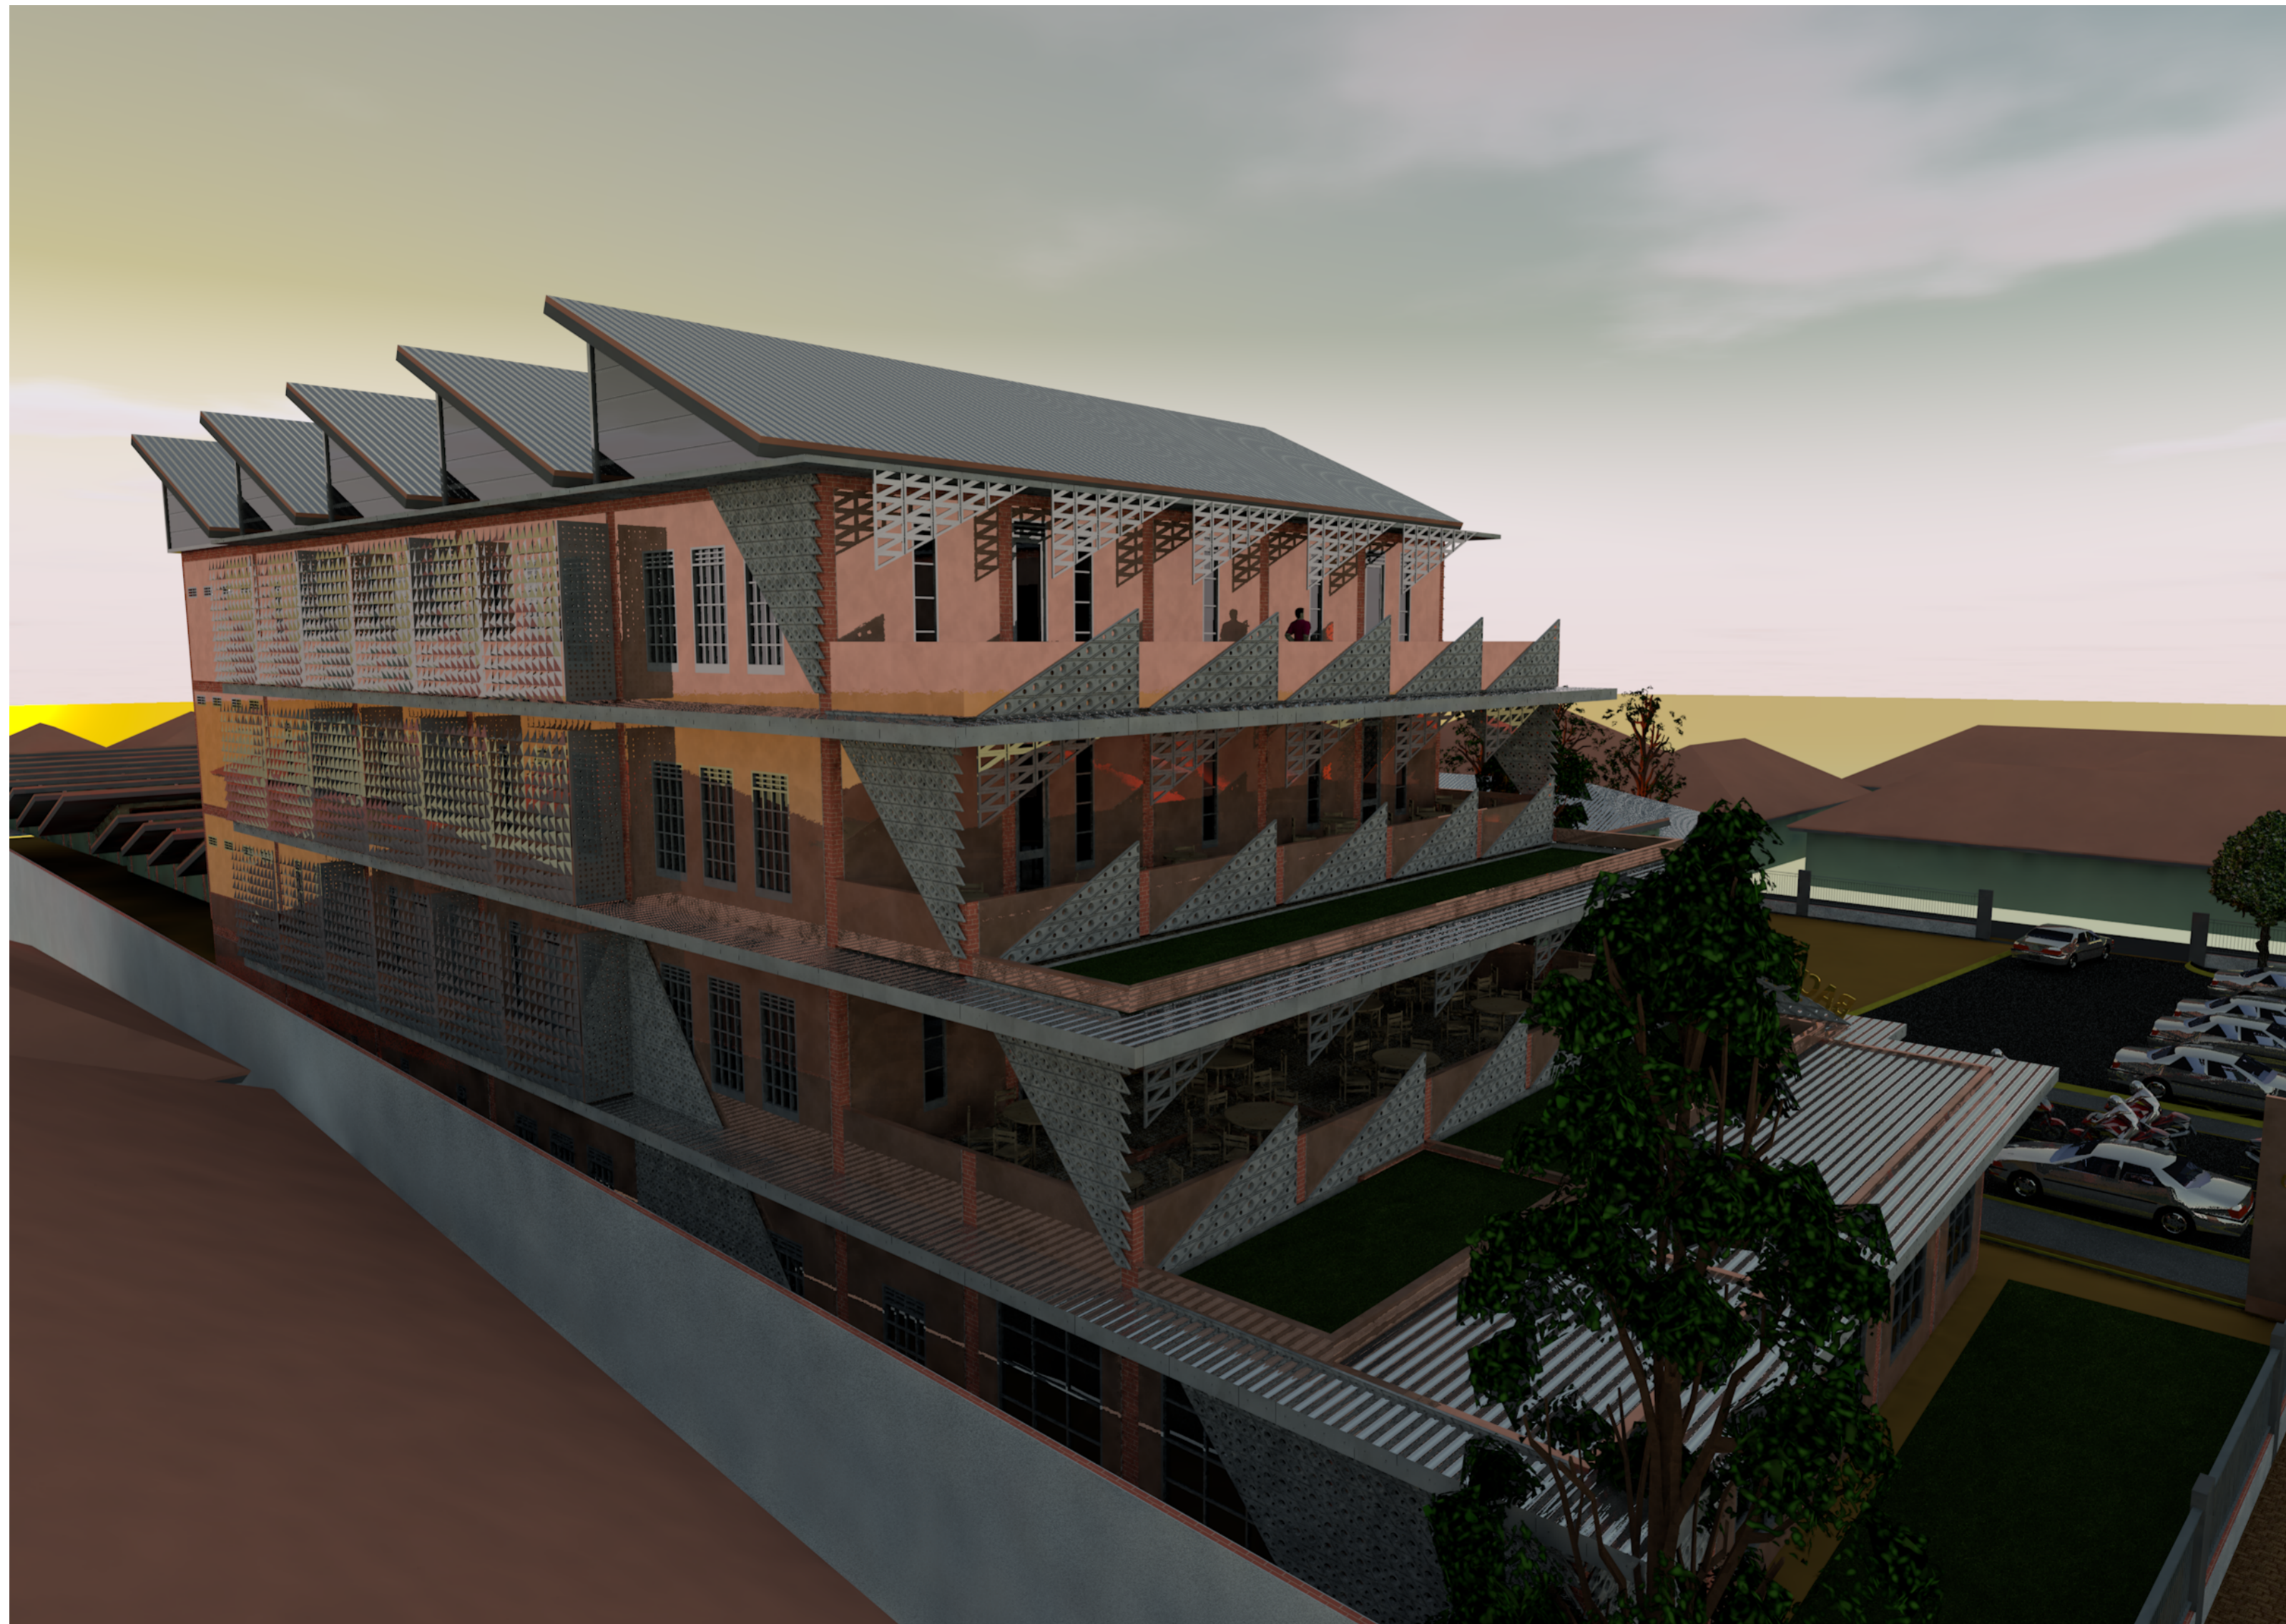 N	PAGE	24
	TOTAL PAGE	29



NOTES
 THESE DRAWINGS ARE AN INSTRUMENT OF SERVICE AND ARE THE PROPERTY OF THE CREATOR. ANY USE OF THE DRAWINGS WITHOUT THE PRIOR EXPRESS WRITTEN PERMISSION OF THE CREATOR IS A VIOLATION OF COPYRIGHT AND WILL BE LIABLE TO PROSECUTION. DO NOT SCALE FROM DRAWINGS. USE ONLY GIVEN DIMENSIONS. ALL DIMENSIONS ARE IN MILLIMETERS UNLESS OTHERWISE NOTED.

△			
△			
△			
△			

REV	DATE	REVISION STATUS	STATUS

PROJECT		
HOTEL BACKPACKER DI PASAR LEMPUYANGAN YOGYAKARTA		
INSTITUTION		
DEPARTMENT OF ARCHITECTURE FACULTY OF CIVIL AND ENGINEERING PLANNING, UII.		
NAME	STUDENT IDENTITY	
FARA HAJAR P ARCHITECT	14512041	

DRAWING TITLE
 PERSPECTIVE EXTERIOR 2


DRAWING BY
 FARA HAJAR P

STATUS
 PRELIMINARY DESIGN

SKALA

DRAWING NO.

	NAME	SIGN	DATE
DRAWN BY	FARA HAJAR P		
CHECKED BY			
APPROVED BY			

 

 N	PAGE	25
	TOTAL PAGE	29



NOTES
 THESE DRAWINGS ARE AN INSTRUMENT OF SERVICE AND ARE THE PROPERTY OF THE CREATOR. ANY USE OF THE DRAWINGS WITHOUT THE PRIOR EXPRESS WRITTEN PERMISSION OF THE CREATOR IS A VIOLATION OF COPYRIGHT AND WILL BE LIABLE TO PROSECUTION. DO NOT SCALE FROM DRAWINGS. USE ONLY GIVEN DIMENSIONS. ALL DIMENSIONS ARE IN MILLIMETERS UNLESS OTHERWISE NOTED.

△			
△			
△			
△			

REV	DATE	REVISION STATUS	STATUS
-----	------	-----------------	--------

PROJECT		
HOTEL BACKPACKER DI PASAR LEMPUYANGAN YOGYAKARTA		
INSTITUTION		
DEPARTMENT OF ARCHITECTURE FACULTY OF CIVIL AND ENGINEERING PLANNING, UII.		
NAME	STUDENT IDENTITY	
FARA HAJAR P ARCHITECT	14512041	

DRAWING TITLE
 PERSPECTIVE EXTERIOR 3

DRAWING BY
 FARA HAJAR P

STATUS
 PRELIMINARY DESIGN

SKALA

DRAWING NO.



	NAME	SIGN	DATE
DRAWN BY	FARA HAJAR P		
CHECKED BY			
APPROVED BY			



NOTES
 THESE DRAWINGS ARE AN INSTRUMENT OF SERVICE AND ARE THE PROPERTY OF THE CREATOR. ANY USE OF THE DRAWINGS WITHOUT THE PRIOR EXPRESS WRITTEN PERMISSION OF THE CREATOR IS A VIOLATION OF COPYRIGHT AND WILL BE LIABLE TO PROSECUTION. DO NOT SCALE FROM DRAWINGS. USE ONLY GIVEN DIMENSIONS. ALL DIMENSIONS ARE IN MILLIMETERS UNLESS OTHERWISE NOTED.

△			
△			
△			
△			

REV	DATE	REVISION STATUS	STATUS

PROJECT		
HOTEL BACKPACKER DI PASAR LEMPUYANGAN YOGYAKARTA		
INSTITUTION		
DEPARTMENT OF ARCHITECTURE FACULTY OF CIVIL AND ENGINEERING PLANNING, UII.		
NAME	STUDENT IDENTITY	
FARA HAJAR P ARCHITECT	14512041	

DRAWING TITLE
 PERSPECTIVE INTERIOR 1


DRAWING BY
 FARA HAJAR P


STATUS
 PRELIMINARY DESIGN

SKALA

DRAWING NO.

	NAME	SIGN	DATE
DRAWN BY	FARA HAJAR P		
CHECKED BY			
APPROVED BY			

  N	PAGE	27
	TOTAL PAGE	29

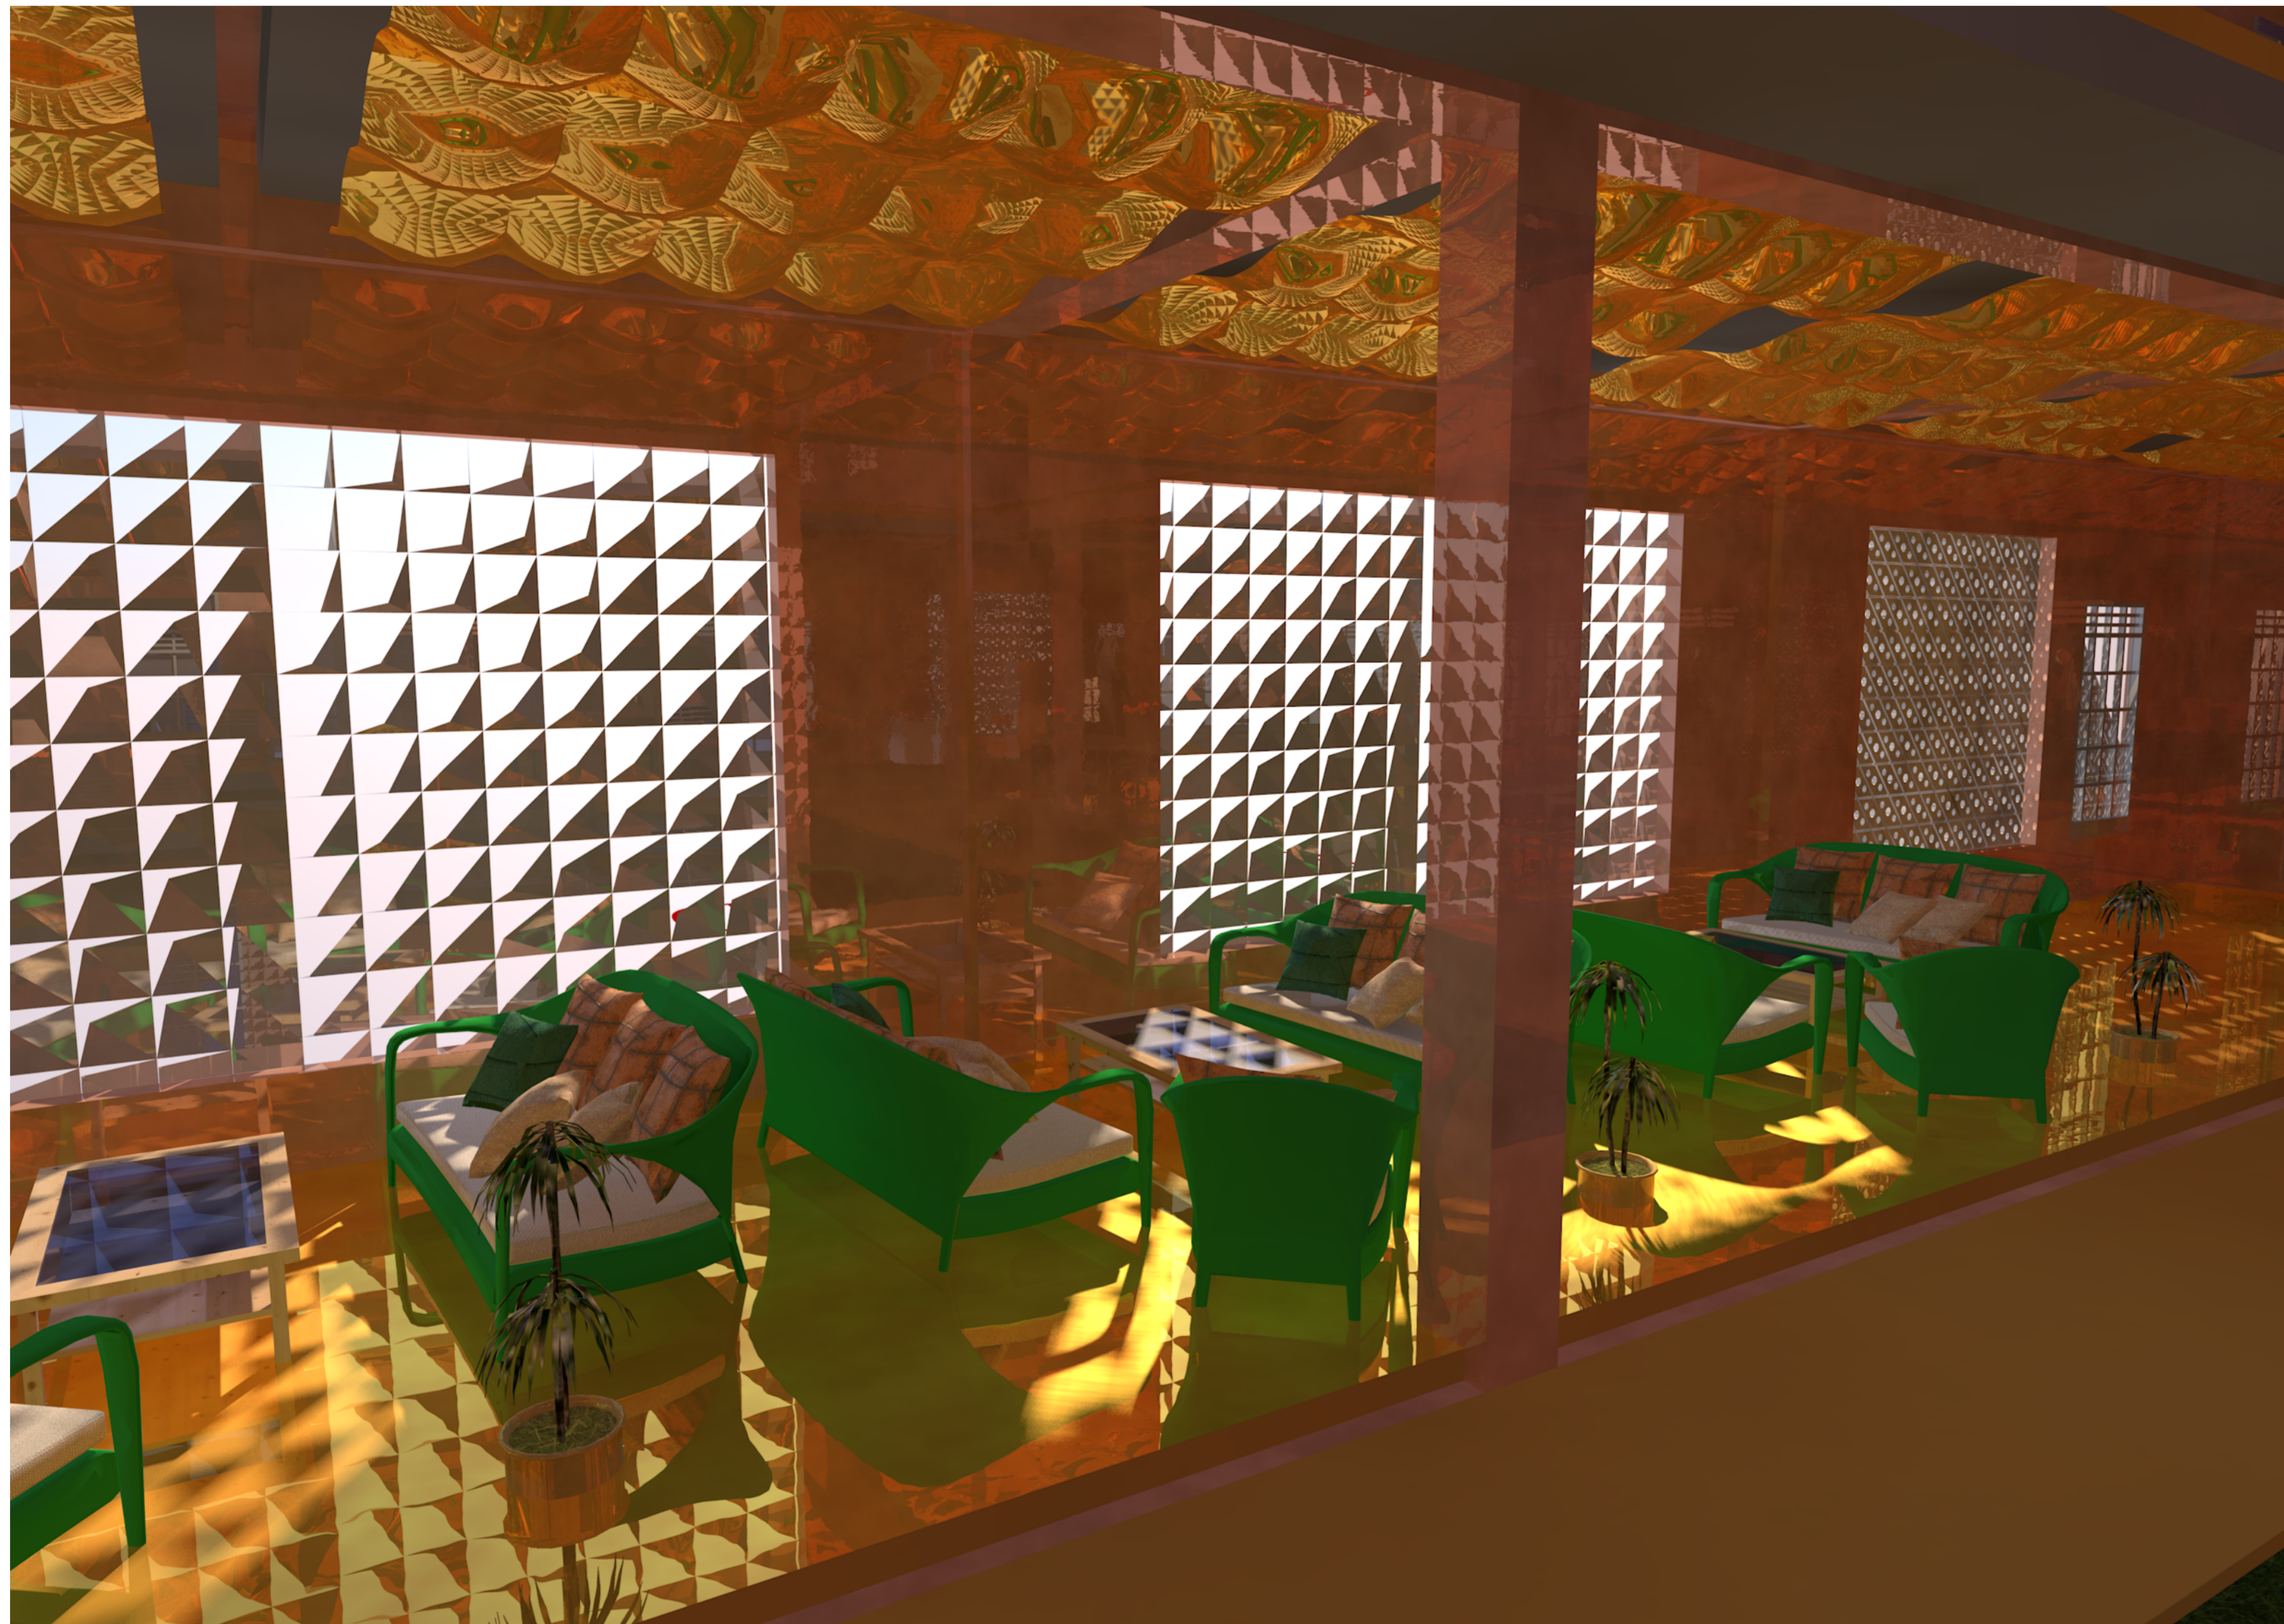



NOTES

THESE DRAWINGS ARE AN INSTRUMENT OF SERVICE AND ARE THE PROPERTY OF THE CREATOR. ANY USE OF THE DRAWINGS WITHOUT THE PRIOR EXPRESS WRITTEN PERMISSION OF THE CREATOR IS A VIOLATION OF COPYRIGHT AND WILL BE LIABLE TO PROSECUTION. DO NOT SCALE FROM DRAWINGS. USE ONLY GIVEN DIMENSIONS. ALL DIMENSIONS ARE IN MILLIMETERS UNLESS OTHERWISE NOTED.

- △
- △
- △
- △

REV	DATE	REVISION STATUS	STATUS

PROJECT		
HOTEL BACKPACKER DI PASAR LEMPUNGAN YOGYAKARTA		
INSTITUTION		
DEPARTMENT OF ARCHITECTURE FACULTY OF CIVIL AND ENGINEERING PLANNING, UII.		
NAME	STUDENT IDENTITY	
FARA HAJAR P ARCHITECT	14512041	

DRAWING TITLE
PERSPECTIVE INTERIOR 2


DRAWING BY
FARA HAJAR P

STATUS
PRELIMINARY DESIGN

SKALA

DRAWING NO.

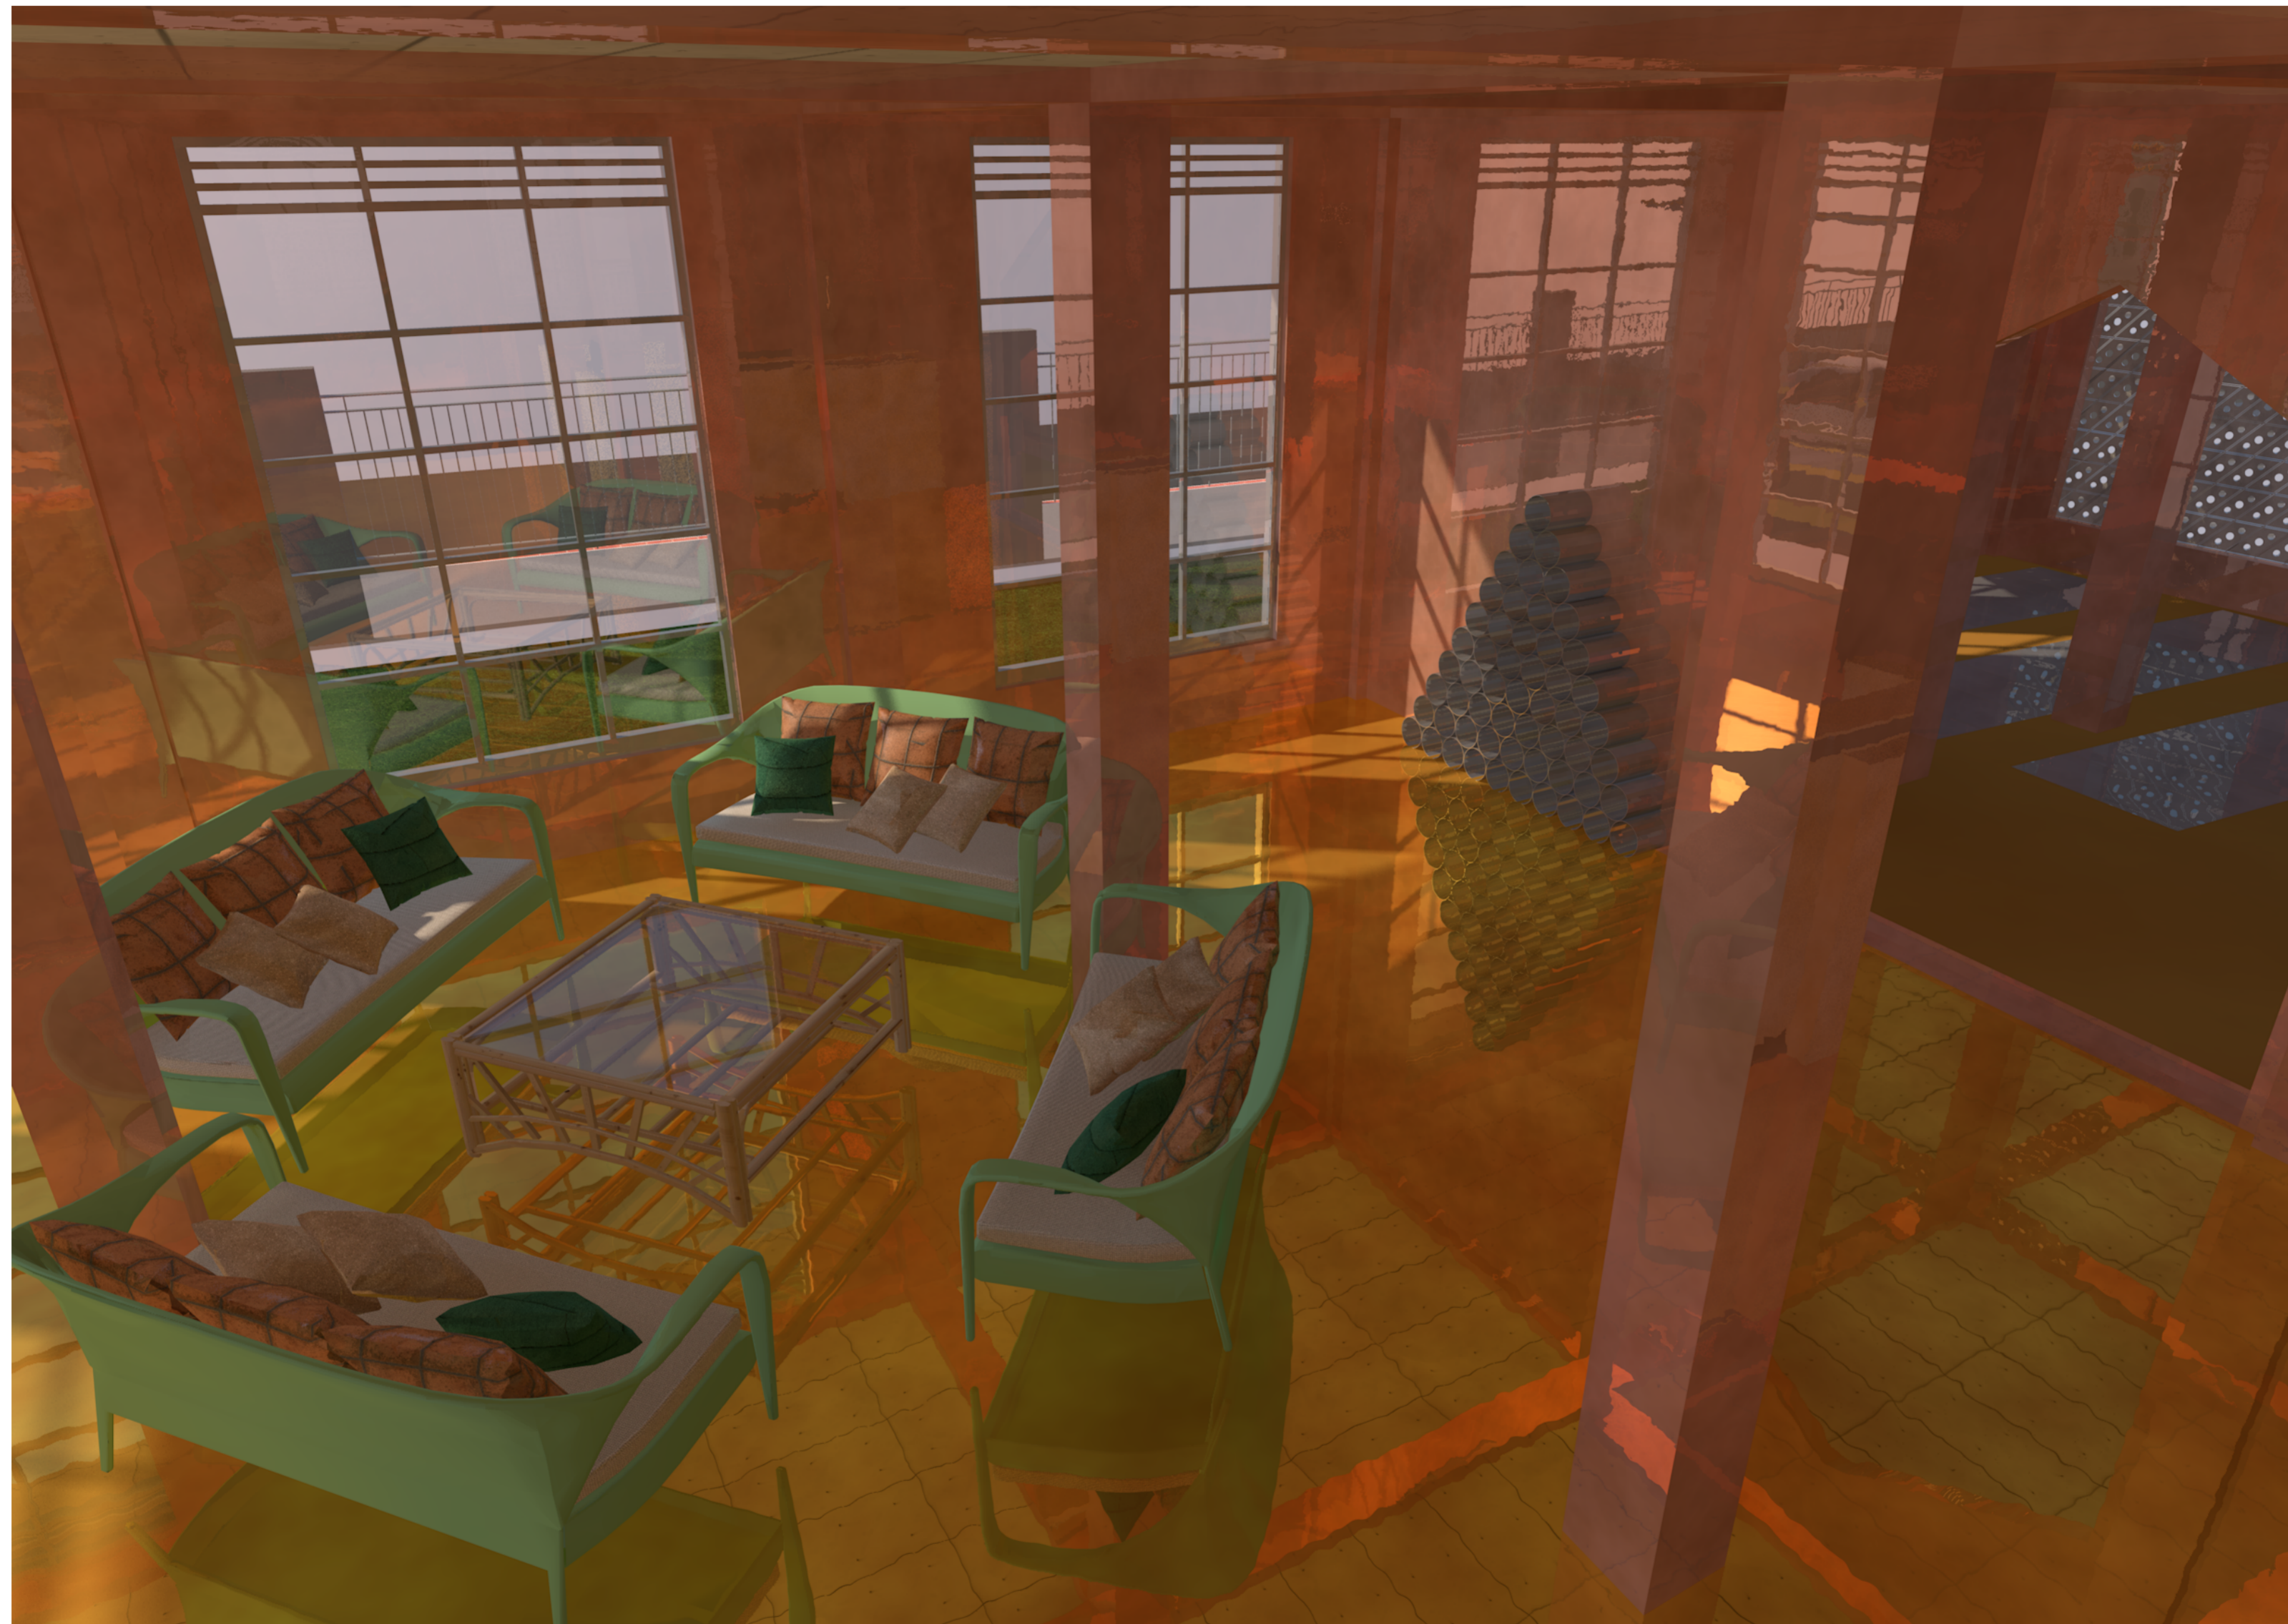

	NAME	SIGN	DATE
DRAWN BY	FARA HAJAR P		
CHECKED BY			
APPROVED BY			



NOTES
 THESE DRAWINGS ARE AN INSTRUMENT OF SERVICE AND ARE THE PROPERTY OF THE CREATOR. ANY USE OF THE DRAWINGS WITHOUT THE PRIOR EXPRESS WRITTEN PERMISSION OF THE CREATOR IS A VIOLATION OF COPYRIGHT AND WILL BE LIABLE TO PROSECUTION. DO NOT SCALE FROM DRAWINGS. USE ONLY GIVEN DIMENSIONS. ALL DIMENSIONS ARE IN MILLIMETERS UNLESS OTHERWISE NOTED.

△			
△			
△			
△			

REV	DATE	REVISION STATUS	STATUS

PROJECT		
HOTEL BACKPACKER DI PASAR LEMPUNGAN YOGYAKARTA		
INSTITUTION		
DEPARTMENT OF ARCHITECTURE FACULTY OF CIVIL AND ENGINEERING PLANNING, UII.		
NAME	STUDENT IDENTITY	
FARA HAJAR P ARCHITECT	14512041	

DRAWING TITLE
 PERSPECTIVE INTERIOR 3

DRAWING BY
 FARA HAJAR P

STATUS
 PRELIMINARY DESIGN

SKALA

DRAWING NO.

	NAME	SIGN	DATE
DRAWN BY	FARA HAJAR P		
CHECKED BY			
APPROVED BY			